
 

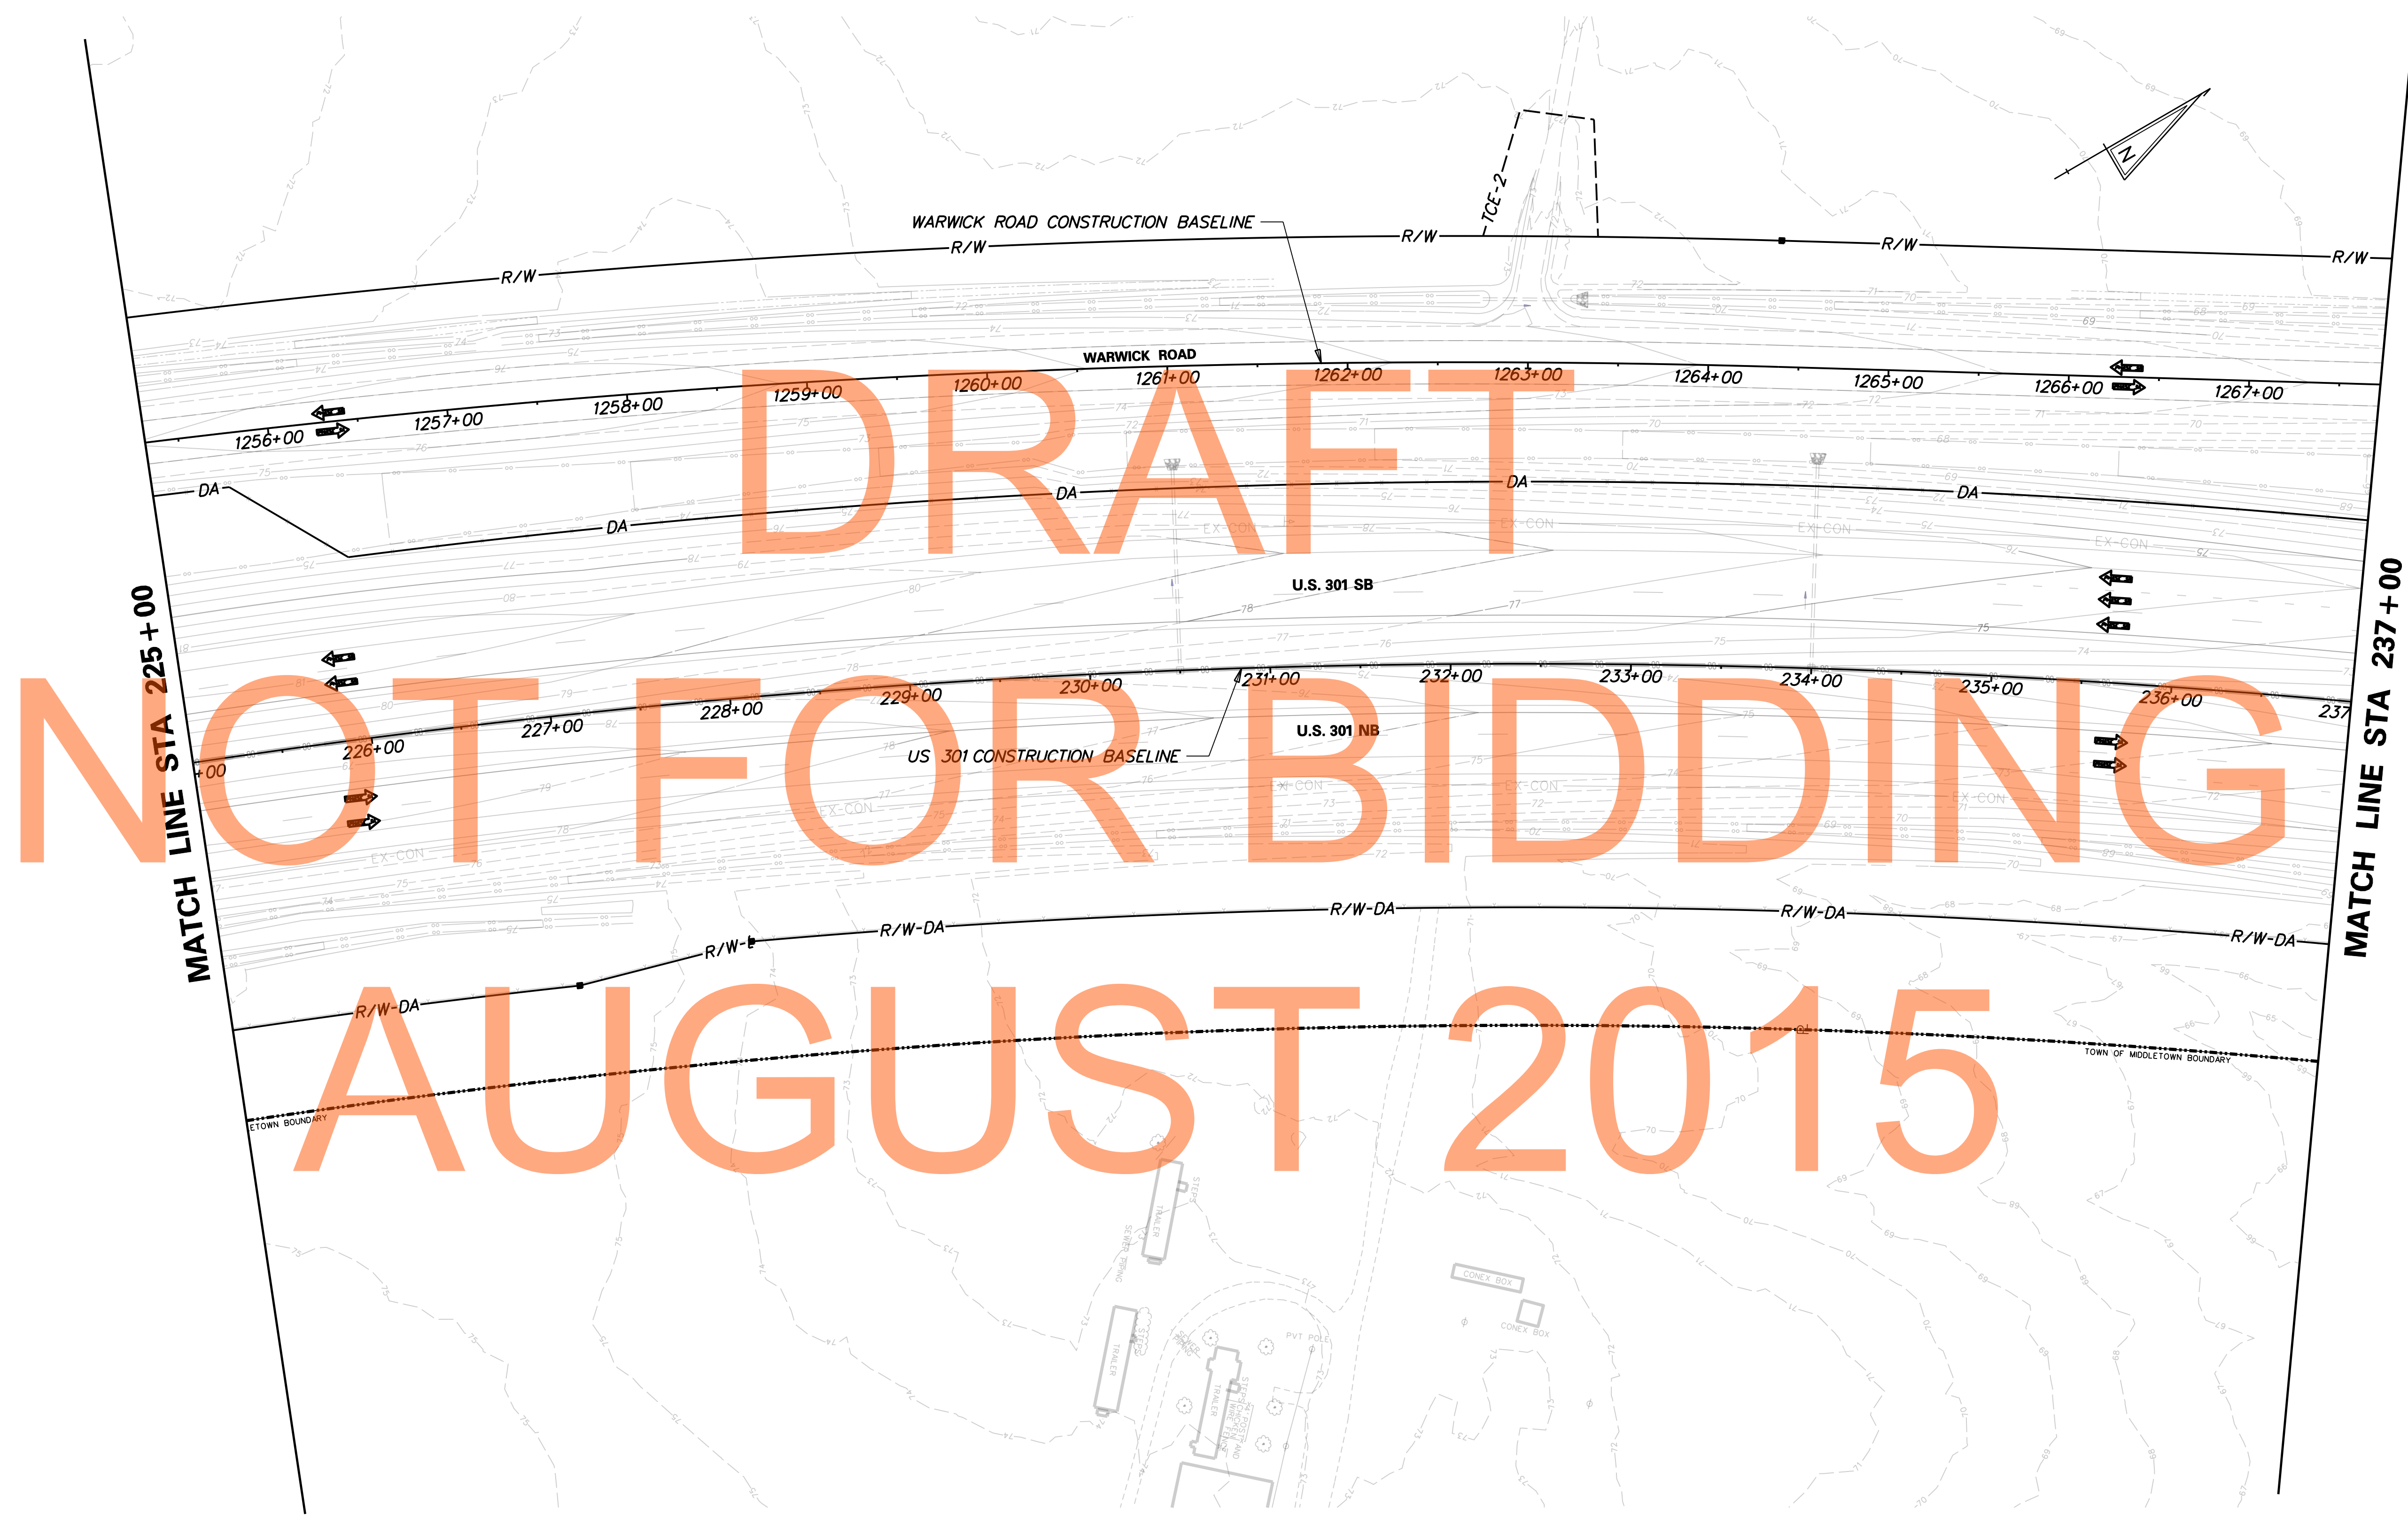


CONSTRUCTION PHASING LEGEND	
	WORK AREA THIS PHASE
	TEMPORARY CONSTRUCTION
	TEMPORARY PAVEMENT MARKING ARROW



J:\2008 PROJECTS\E3X34801\700CADD\DESIGN_SECTION_2_PLANS\MD_301DS2_027.DGN



ADDENDUMS / REVISIONS	


 



**US 301
MARYLAND STATE LINE
TO LEVELS ROAD**

CONTRACT T200911303	BRIDGE NO.
COUNTY NEW CASTLE	DESIGNED BY: MFM
	CHECKED BY: SKH


**CONSTRUCTION PHASING,
M.O.T., AND EROSION
CONTROL PLAN - PHASE 3A**

MD-27
SHEET NO. 1139
TOTAL SHTS. 1256

CONSTRUCTION PHASING LEGEND	
	WORK AREA THIS PHASE
	TEMPORARY CONSTRUCTION
	TEMPORARY PAVEMENT MARKING ARROW




J:\2008 PROJECTS\E3\34801\700CADD\DESIGN_SECTION_2_PLANS\MD_301DS2_028.DGN



DELAWARE
DEPARTMENT OF TRANSPORTATION

ADDENDUMS / REVISIONS	

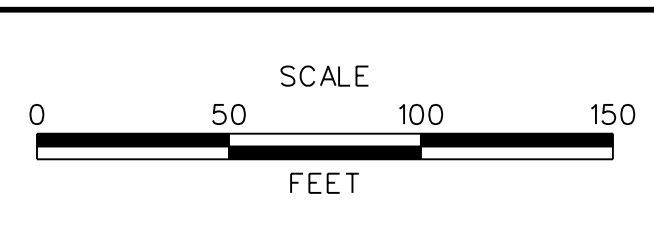


 

US 301
MARYLAND STATE LINE
TO LEVELS ROAD

CONTRACT T200911303	BRIDGE NO.
COUNTY NEW CASTLE	DESIGNED BY: MFM
	CHECKED BY: SKH

CONSTRUCTION PHASING,
M.O.T., AND EROSION
CONTROL PLAN - PHASE 3A


MD-28
SHEET NO. 1140
TOTAL SHTS. 1256

CONSTRUCTION PHASING LEGEND


	WORK AREA THIS PHASE
	TEMPORARY CONSTRUCTION
	TEMPORARY PAVEMENT MARKING ARROW

NOTES:

1. AT THE TIME THAT THE ENTIRE US 301 MAINLINE FROM THE MARYLAND STATE LINE TO SRI IS READY TO BE OPEN TO PUBLIC TRAFFIC, DELDOT MAY DECIDE TO ALLOW PUBLIC USE OF THE US 301 FACILITY FOR A SHORT PERIOD OF TIME BEFORE STARTING TO COLLECT TOLLS. THE DETERMINATION IF THIS TOLL GRACE PERIOD IS TO BE USED AND THE DURATION WILL BE MADE BY DELDOT AT THE TIME THE ENTIRE US 301 FACILITY IS READY TO BE OPEN TO PUBLIC TRAFFIC. THE CMS DEVICES SHOWN ON THIS SHEET SHALL BE IMPLEMENTED IF THE TOLL GRACE PERIOD IS USED.

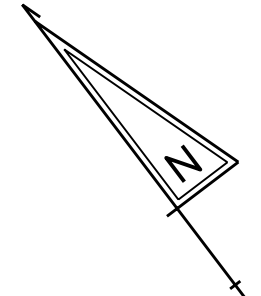

DRAFT
NOT FOR BIDDING
AUGUST 2015

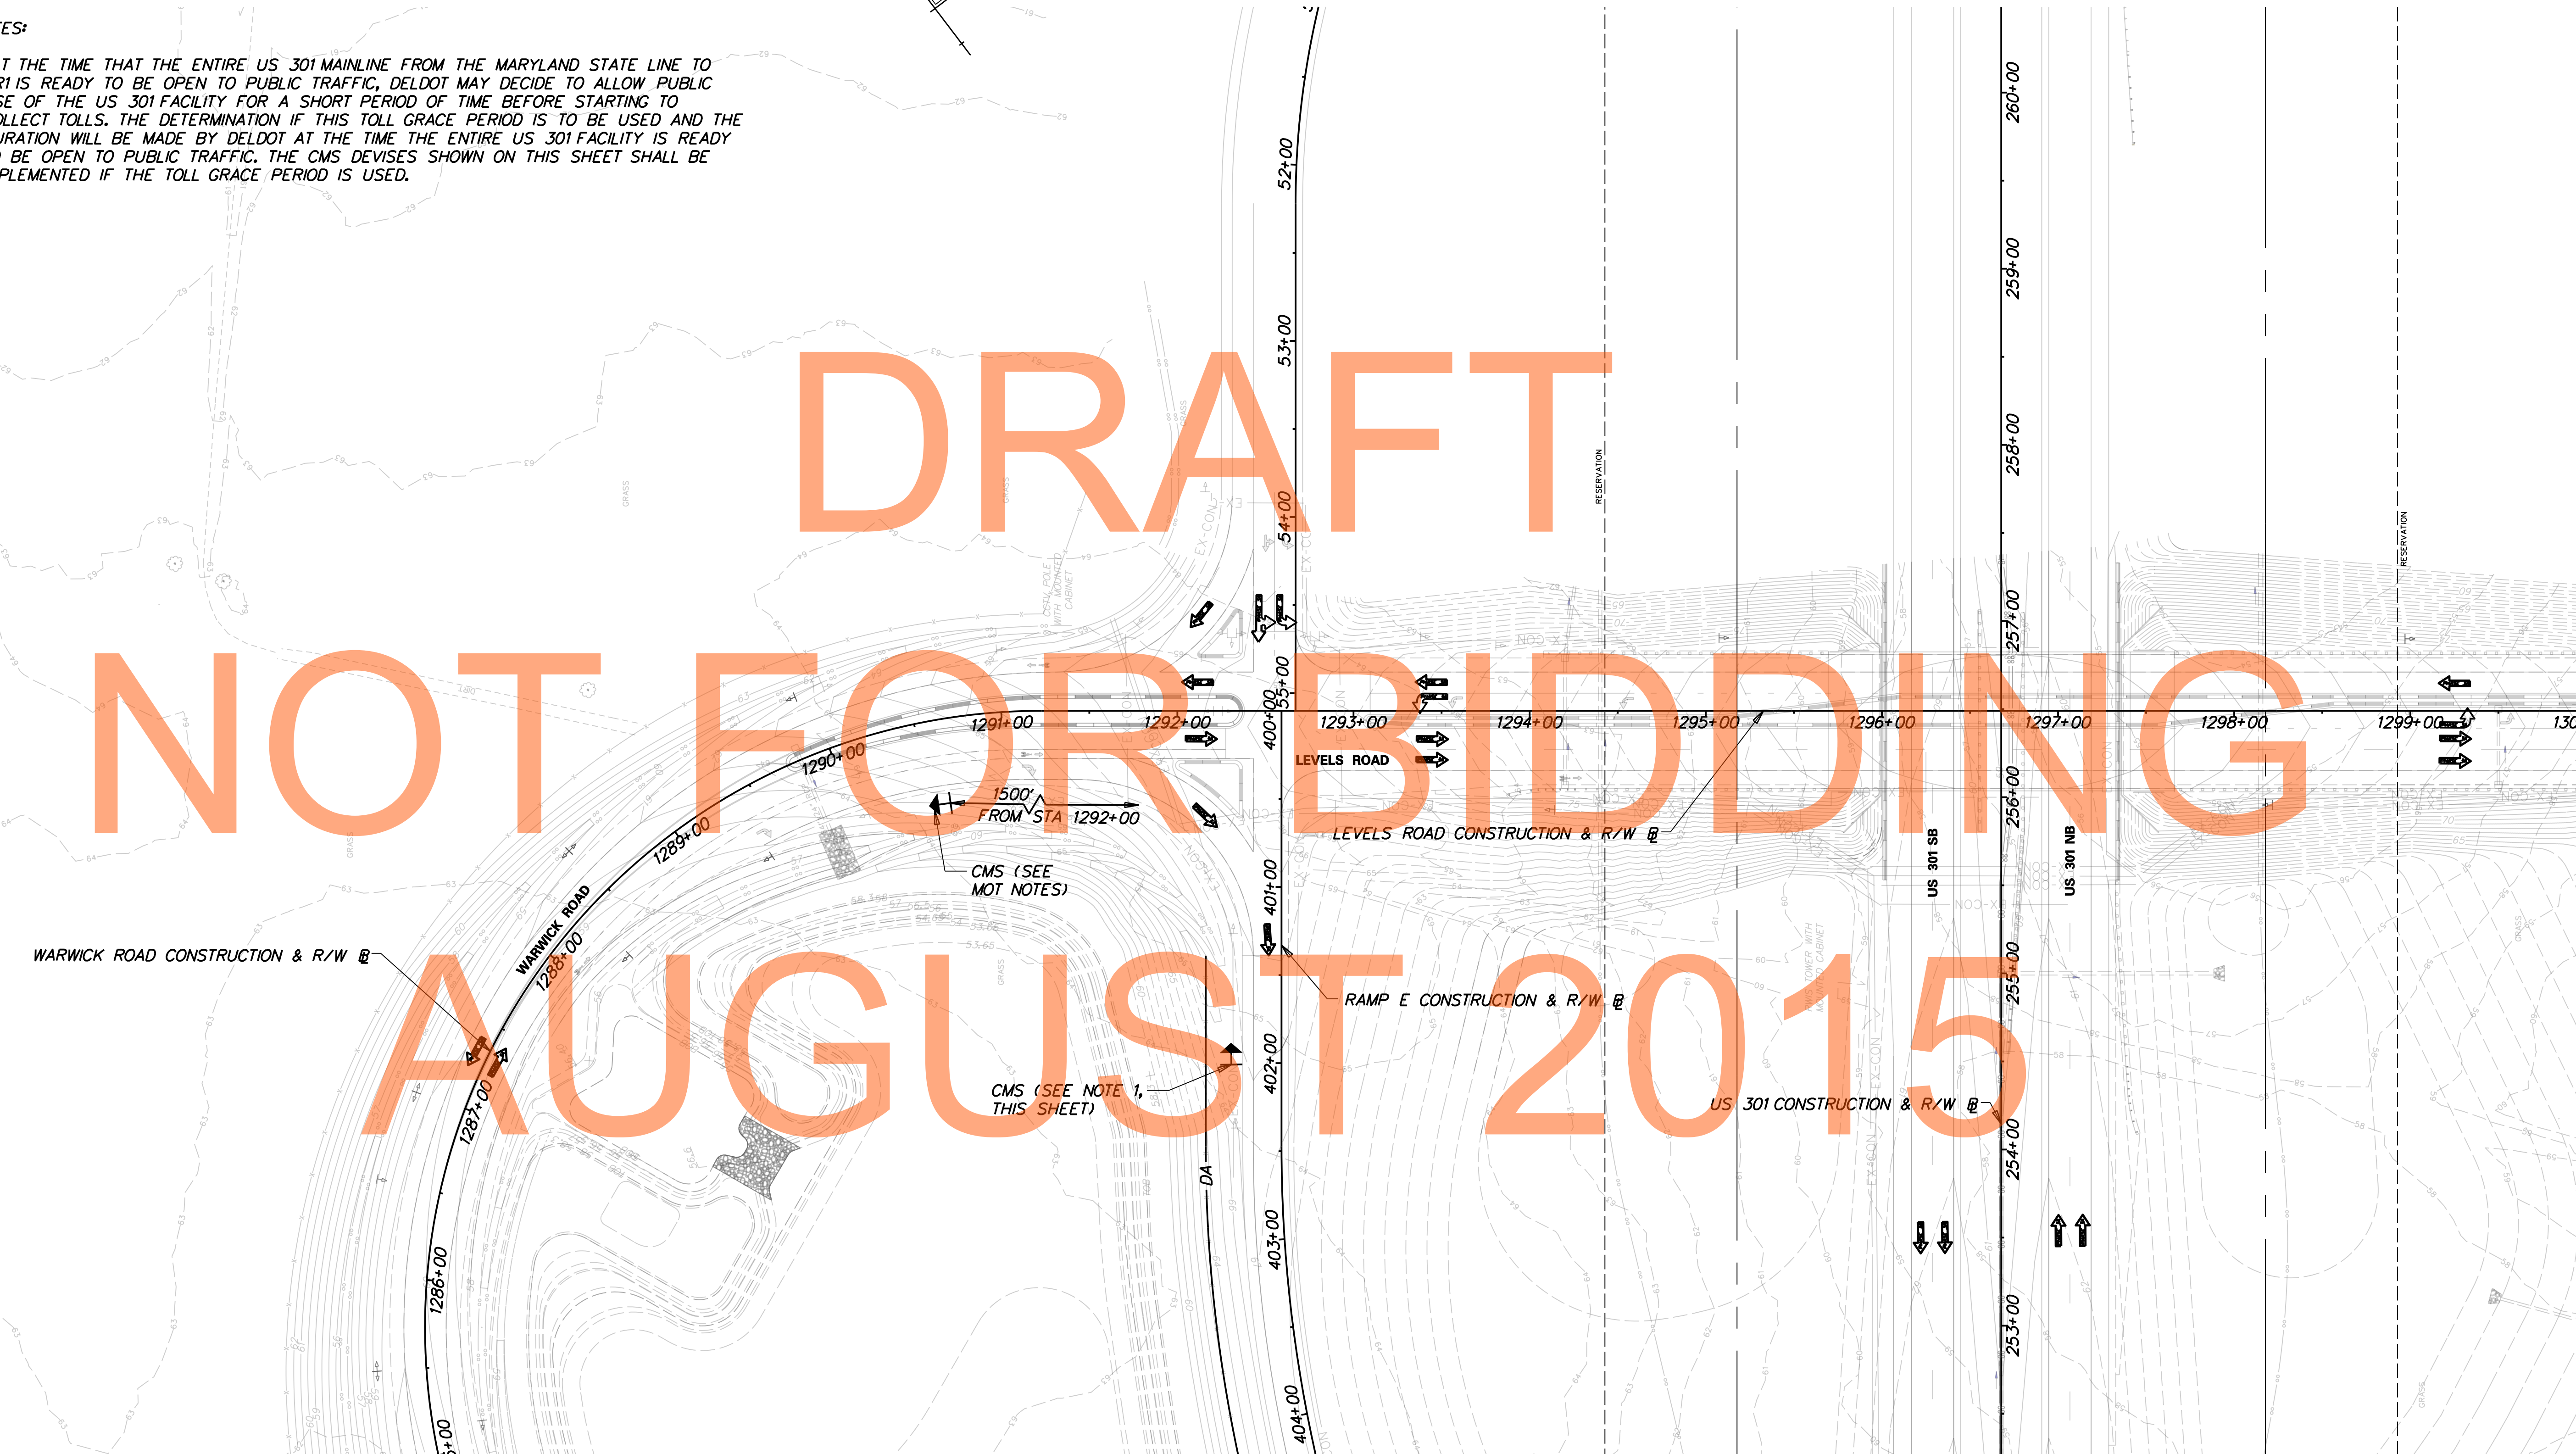


J:\2008 PROJECTS\E3X34801\700CADD\702ROAD\DESIGN_SECTION_2_PLANS\MD_301DS2_029.DGN

MATCH LINE STA 1300+00



ADDENDUMS / REVISIONS	

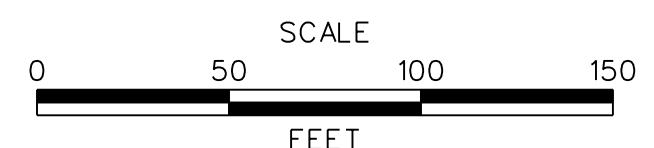




**US 301
MARYLAND STATE LINE
TO LEVELS ROAD**


CONTRACT T200911303	BRIDGE NO.
COUNTY NEW CASTLE	DESIGNED BY: MFM
	CHECKED BY: SKH

**CONSTRUCTION PHASING,
M.O.T., AND EROSION
CONTROL PLAN - PHASE 3A**

MD-29
SHEET NO. 1141
TOTAL SHTS. 1256

CONSTRUCTION PHASING LEGEND


	WORK AREA THIS PHASE
	TEMPORARY CONSTRUCTION
	TEMPORARY PAVEMENT MARKING ARROW

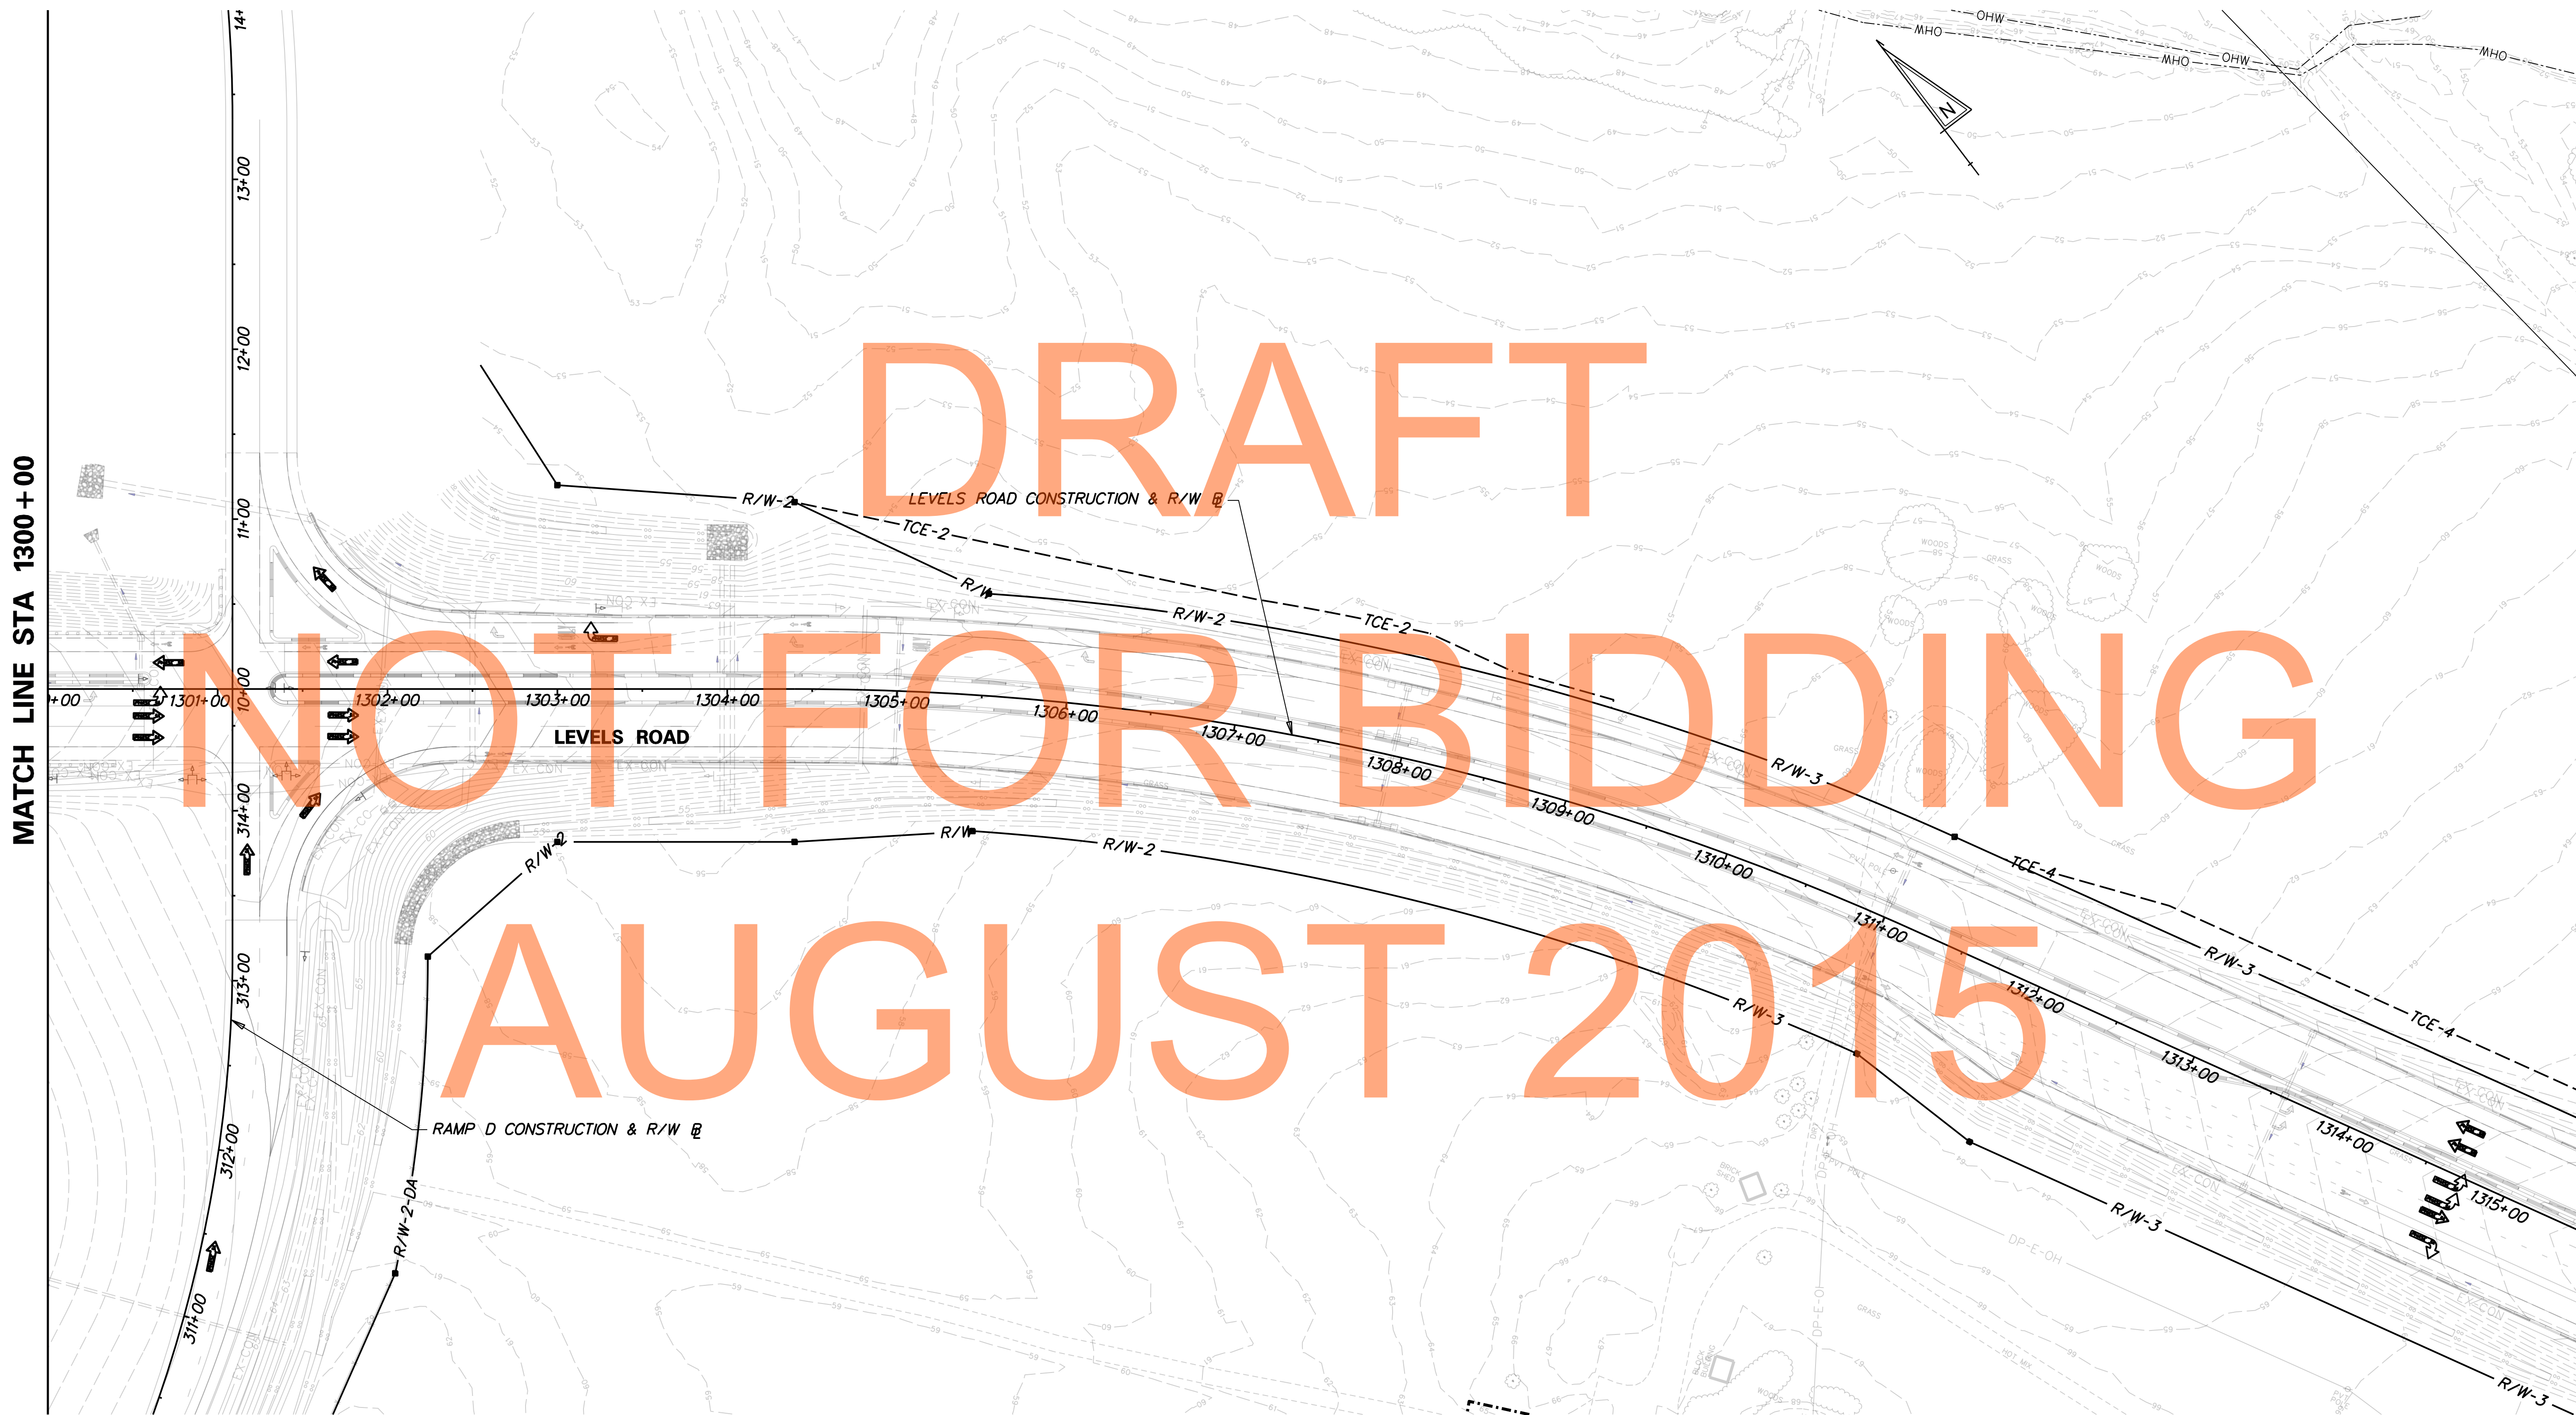

J:\2008 PROJECTS\E3X34801\700CADD\750AET\DESIGN_SECTION_2_PLANS\MD_301AETDS2_030.DGN

DELAWARE DEPARTMENT OF TRANSPORTATION

ADDENDUMS / REVISIONS	

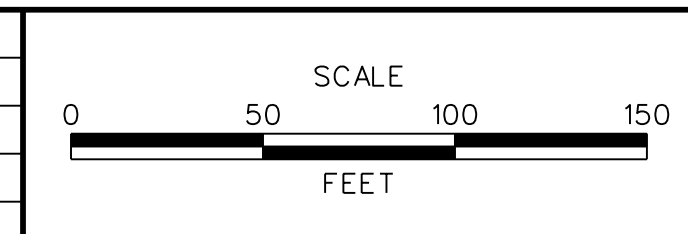


 

US 301 MARYLAND STATE LINE TO LEVELS ROAD

CONTRACT T200911303	BRIDGE NO.
COUNTY NEW CASTLE	DESIGNED BY: MFM
	CHECKED BY: SKH

CONSTRUCTION PHASING, M.O.T., AND EROSION CONTROL PLAN - PHASE 3A

MD-30
SHEET NO. 1142
TOTAL SHTS. 1256

CONSTRUCTION PHASING LEGEND



	WORK AREA THIS PHASE
	TEMPORARY CONSTRUCTION
	TEMPORARY PAVEMENT MARKING ARROW

SEQUENCE OF CONSTRUCTION: PHASE 3B

OBJECTIVE: COMPLETE TEMPORARY CROSSOVER REMOVAL AND MEDIAN RESTORATION.

1. INSTALL ALL TEMPORARY TRAFFIC CONTROL DEVICES AS SHOWN AND IMPLEMENT PHASE 3B TRAFFIC CONTROL SCHEME.
2. INSPECT AND MAINTAIN ALL EXISTING EROSION AND SEDIMENT CONTROL FACILITIES AND FEATURES. THE ENGINEER MUST GRANT APPROVAL PRIOR TO THE REMOVAL OF ANY EROSION AND SEDIMENT CONTROL DEVICE.
3. INSTALL LANE CLOSURES DURING OFF-PEAK HOURS.
4. REMOVE TEMPORARY CROSSOVER WITHIN THE MEDIAN.
5. REMOVE TEMPORARY PIPE AND CONVERT EXISTING JUNCTION BOX TO CATCH BASIN AT STATION 171+00. COMPLETE ROADSIDE GRADING.

NOTE: UPON COMPLETION OR TEMPORARY CESSATION OF AN EARTH DISTURBANCE ACTIVITY, OR ANY STAGE THEREOF, THE PROJECT SITE SHALL BE IMMEDIATELY STABILIZED WITH THE APPROPRIATE TEMPORARY OR PERMANENT STABILIZATION.

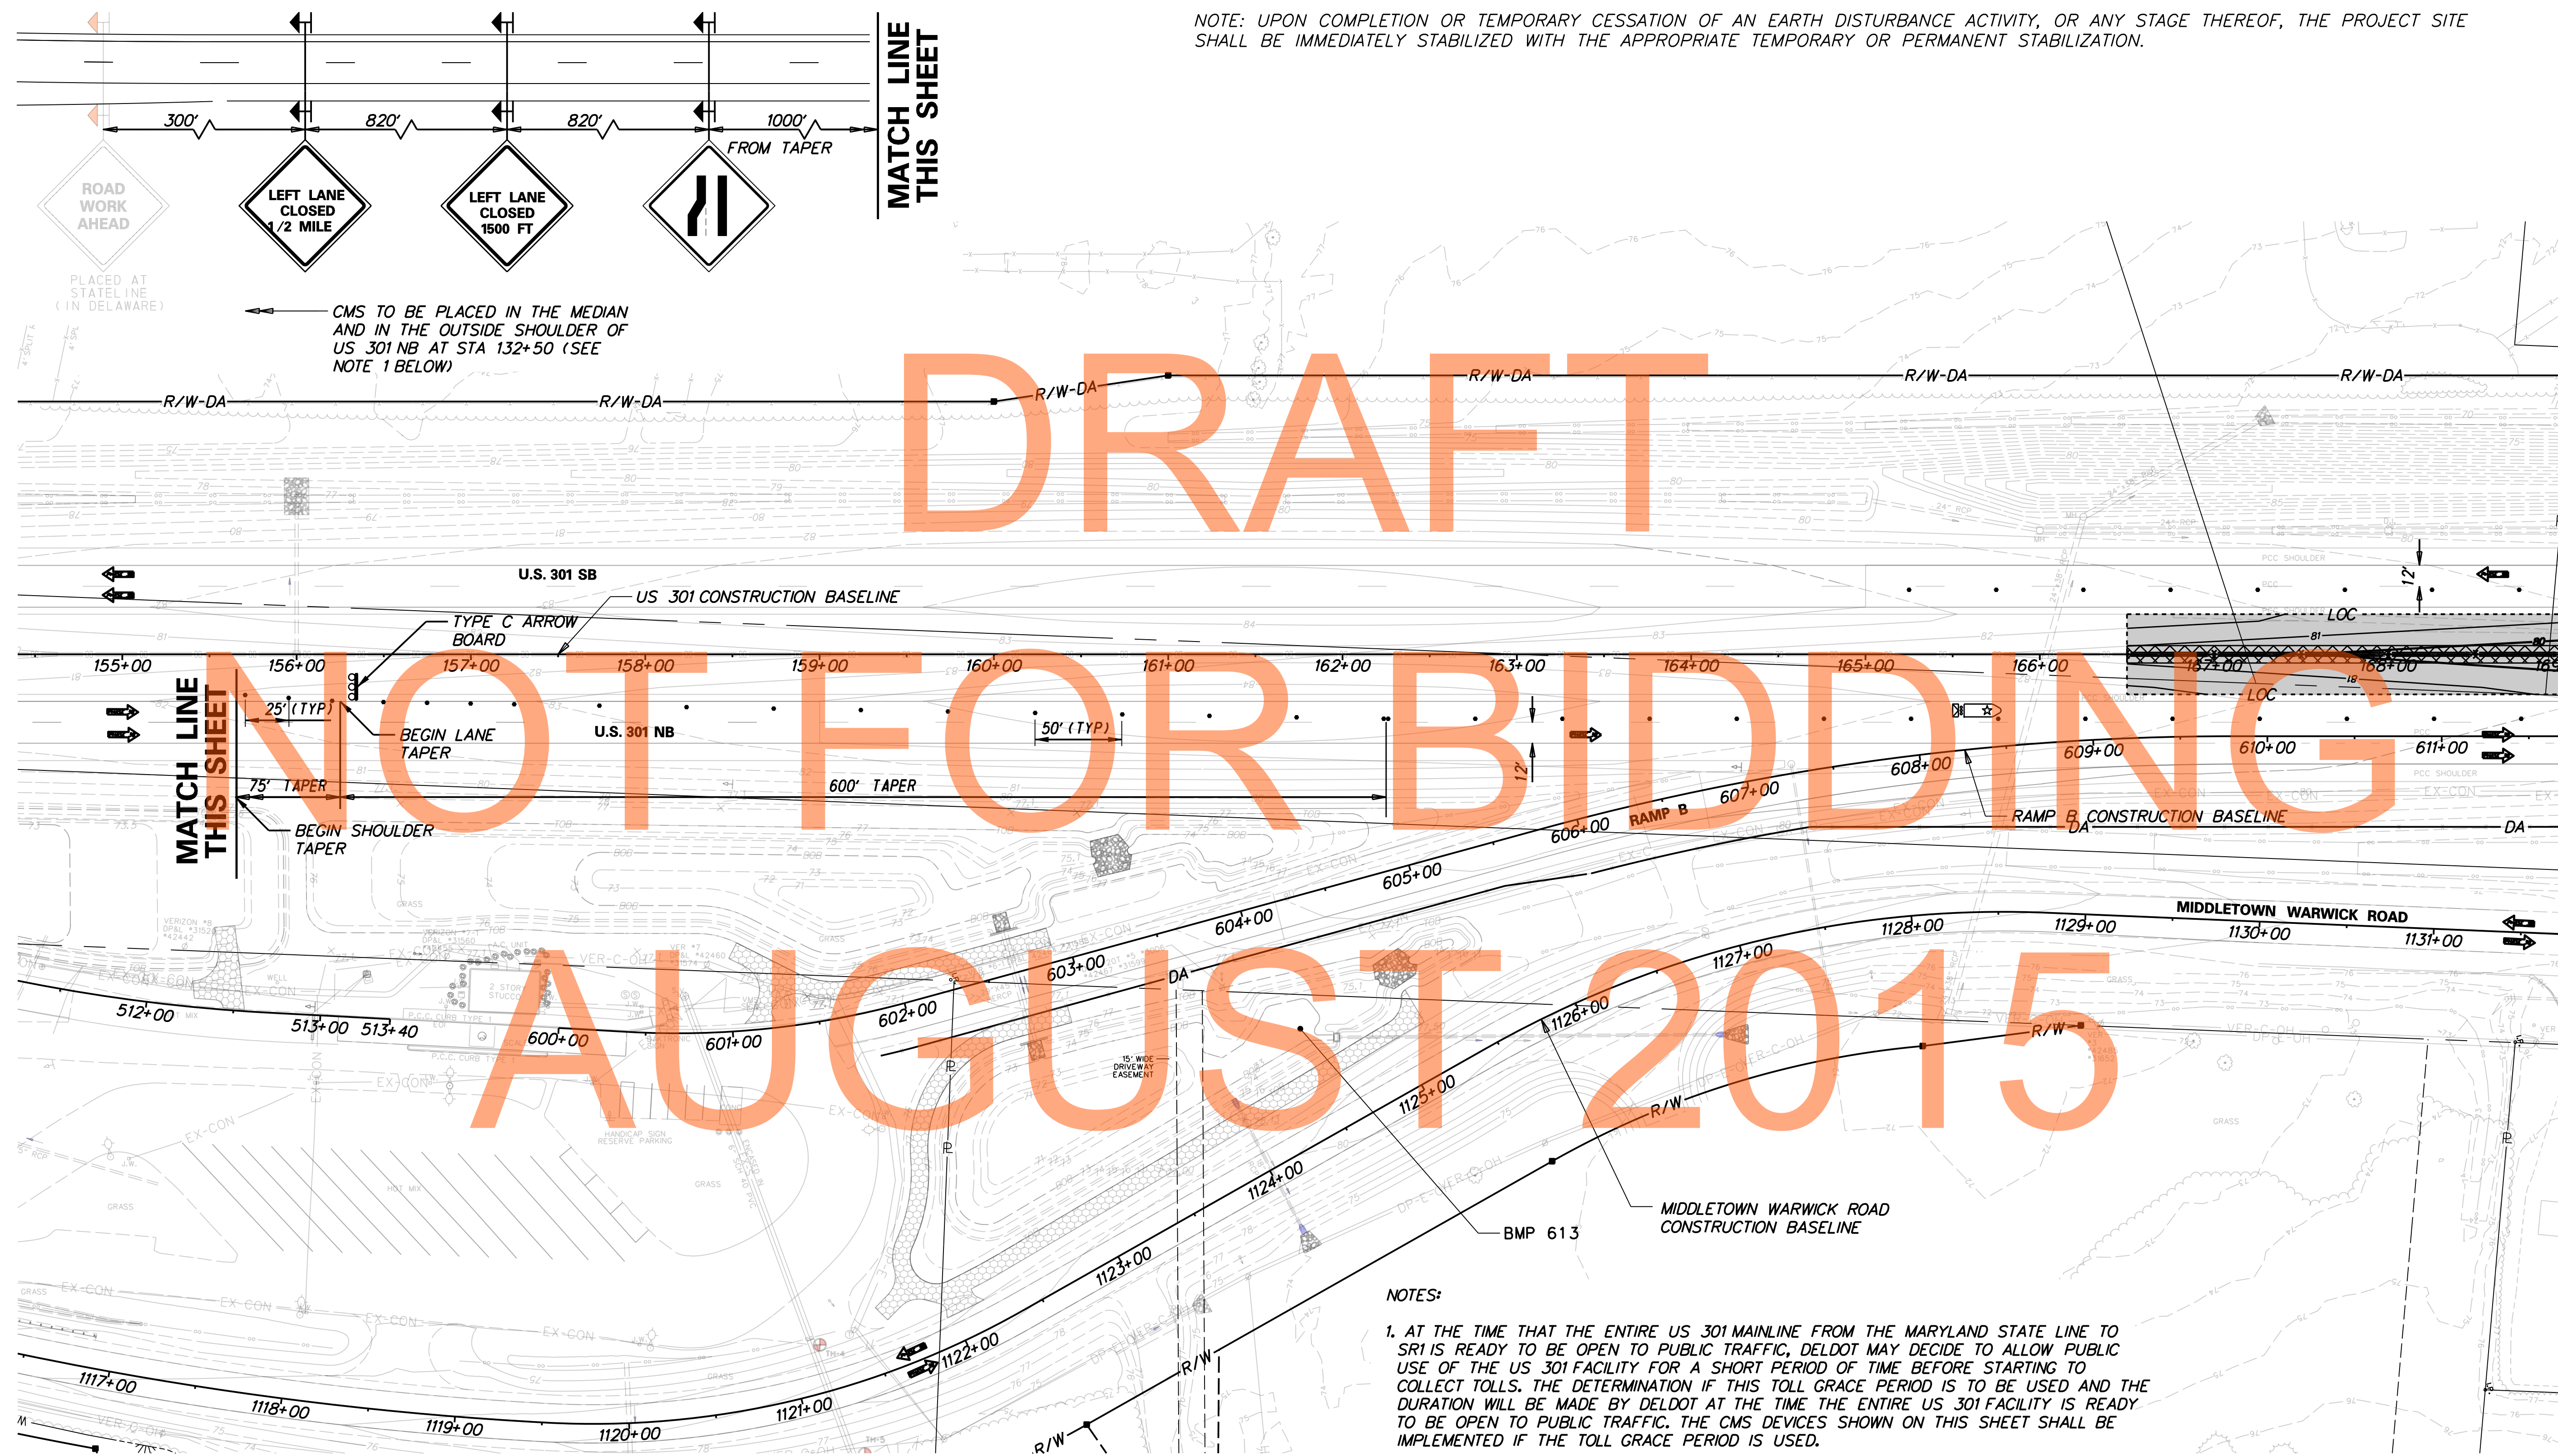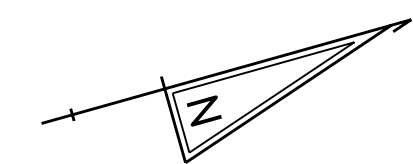

MATCH LINE THIS SHEET

MATCH LINE THIS SHEET

MATCH LINE STA 169+00

DRAFT
NOT FOR BIDDING
AUGUST 2015

NOTES:


1. AT THE TIME THAT THE ENTIRE US 301 MAINLINE FROM THE MARYLAND STATE LINE TO SR1 IS READY TO BE OPEN TO PUBLIC TRAFFIC, DELDOT MAY DECIDE TO ALLOW PUBLIC USE OF THE US 301 FACILITY FOR A SHORT PERIOD OF TIME BEFORE STARTING TO COLLECT TOLLS. THE DETERMINATION IF THIS TOLL GRACE PERIOD IS TO BE USED AND THE DURATION WILL BE MADE BY DELDOT AT THE TIME THE ENTIRE US 301 FACILITY IS READY TO BE OPEN TO PUBLIC TRAFFIC. THE CMS DEVICES SHOWN ON THIS SHEET SHALL BE IMPLEMENTED IF THE TOLL GRACE PERIOD IS USED.

J:\2008 PROJECTS\E3X34801\700CADD\750AET\DESIGN_SECTION_2_PLANS\MD_301AETDS2_031.DGN



DELAWARE DEPARTMENT OF TRANSPORTATION

ADDENDUMS / REVISIONS	

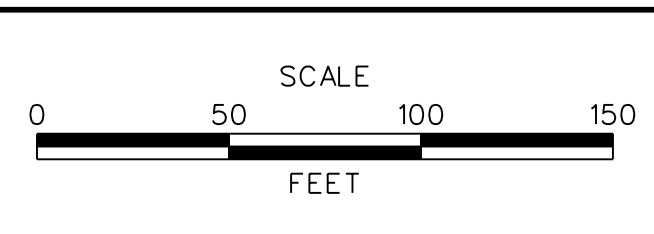


 

**US 301
MARYLAND STATE LINE
TO LEVELS ROAD**



CONTRACT T200911303	BRIDGE NO.
COUNTY NEW CASTLE	DESIGNED BY: MFM
	CHECKED BY: SKH

**CONSTRUCTION PHASING,
M.O.T., AND EROSION
CONTROL PLAN - PHASE 3B**

MD-31
SHEET NO. 1143
TOTAL SHTS. 1256

CONSTRUCTION PHASING LEGEND

	WORK AREA THIS PHASE
	TEMPORARY CONSTRUCTION
	TEMPORARY PAVEMENT MARKING ARROW

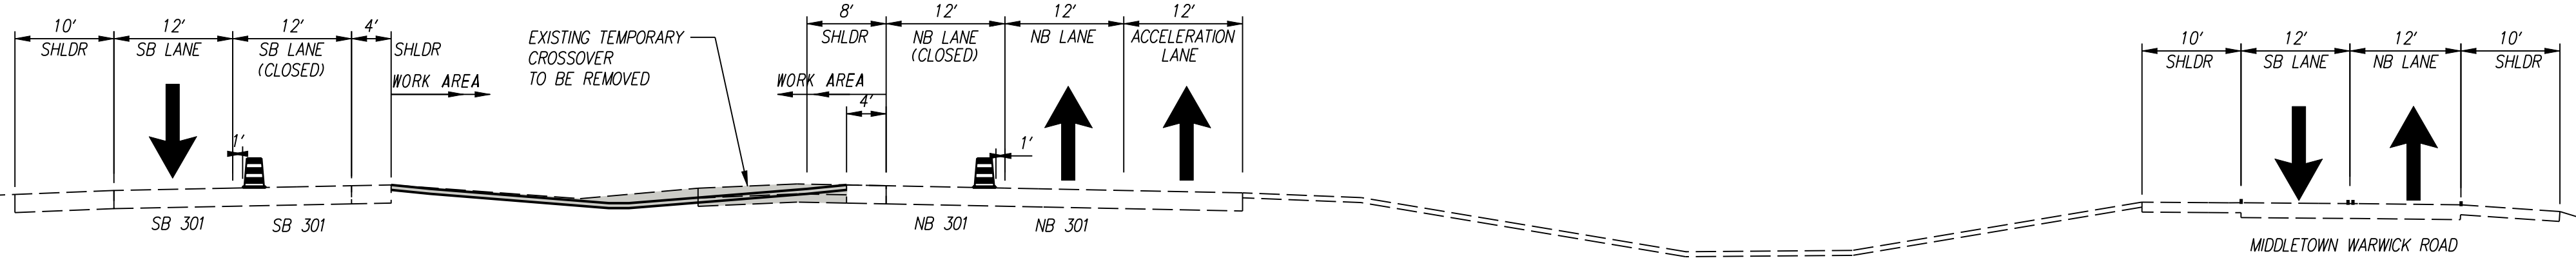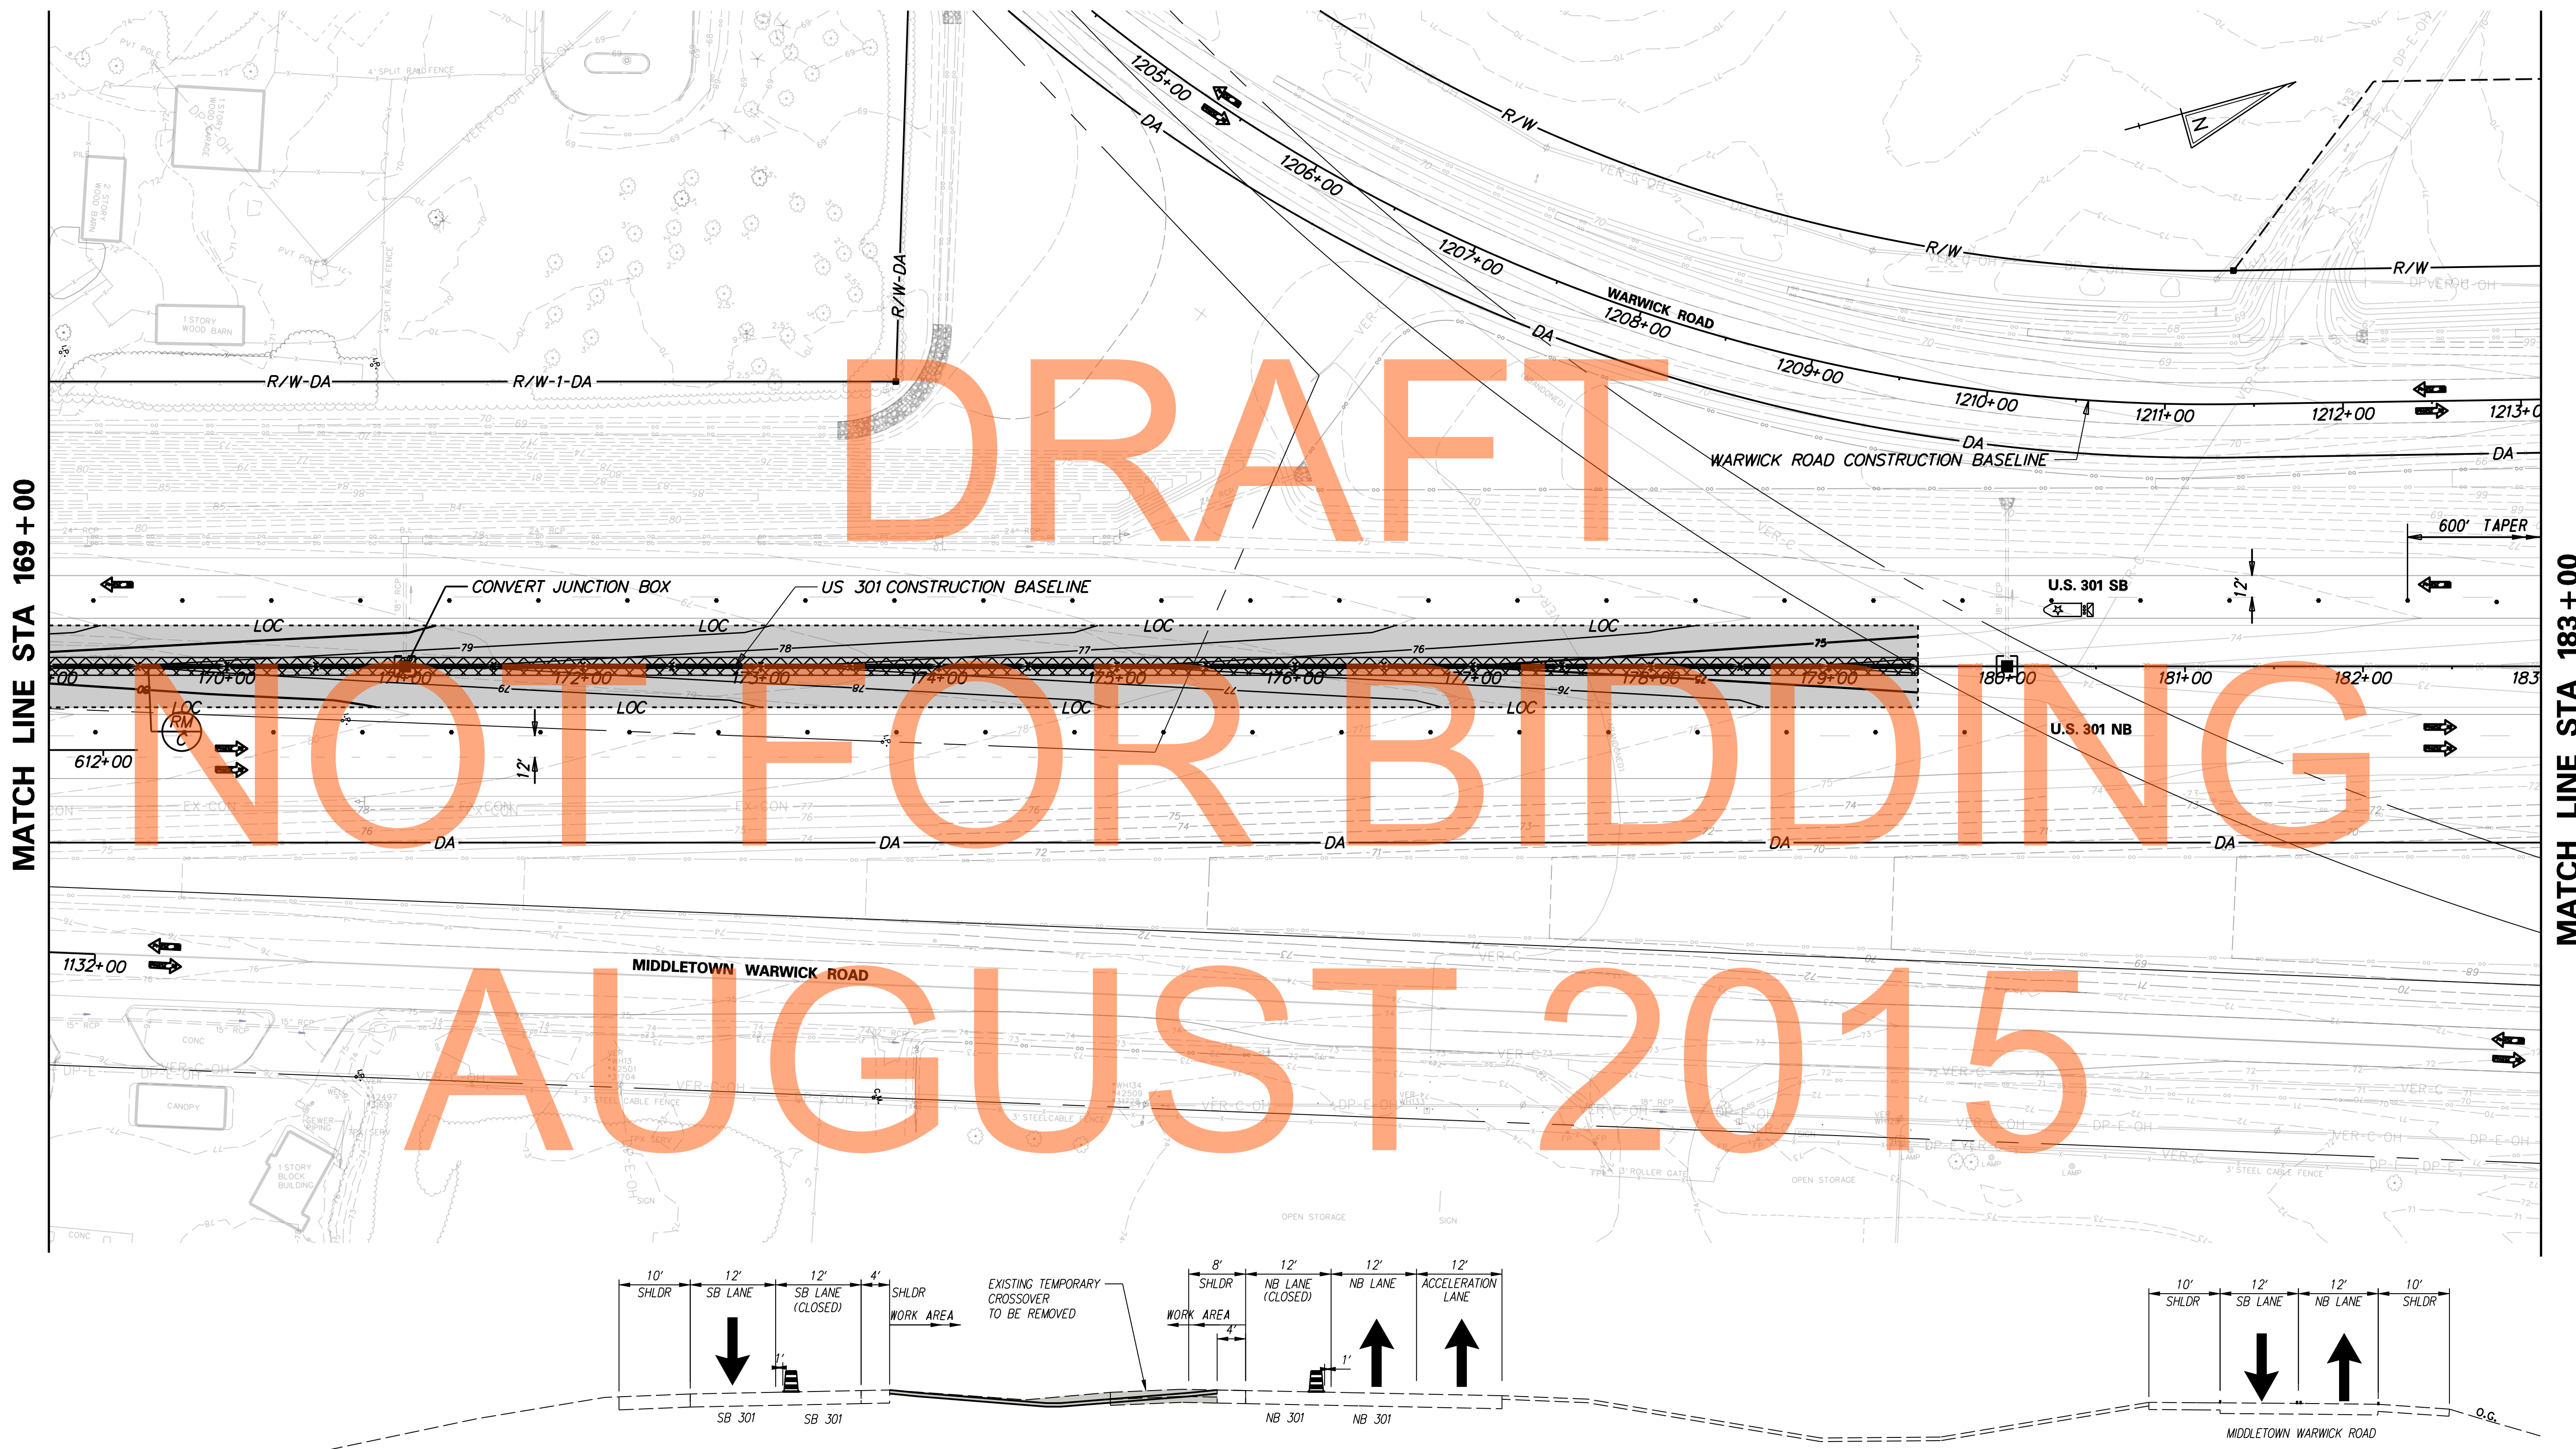


US 301 MOT TYPICAL SECTION
STATION 166+50 TO STATION 179+50

J:\2008 PROJECTS\E3X34801\700CADD\702ROAD\DESIGN_SECTION_2_PLANS\MD_301DS2_032.DGN



ADDENDUMS / REVISIONS	

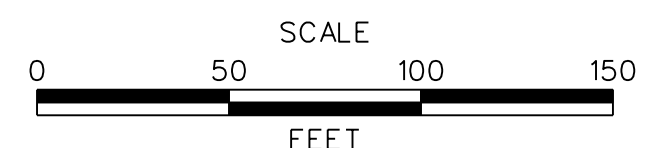


 

US 301
MARYLAND STATE LINE
TO LEVELS ROAD


CONTRACT	BRIDGE NO.
T200911303	
COUNTY	DESIGNED BY: MFM
NEW CASTLE	CHECKED BY: SKH

CONSTRUCTION PHASING,
M.O.T., AND EROSION
CONTROL PLAN - PHASE 3B

MD-32
SHEET NO.
1144
TOTAL SHTS.
1256

CONSTRUCTION PHASING LEGEND

	WORK AREA THIS PHASE
	TEMPORARY CONSTRUCTION
	TEMPORARY PAVEMENT MARKING ARROW

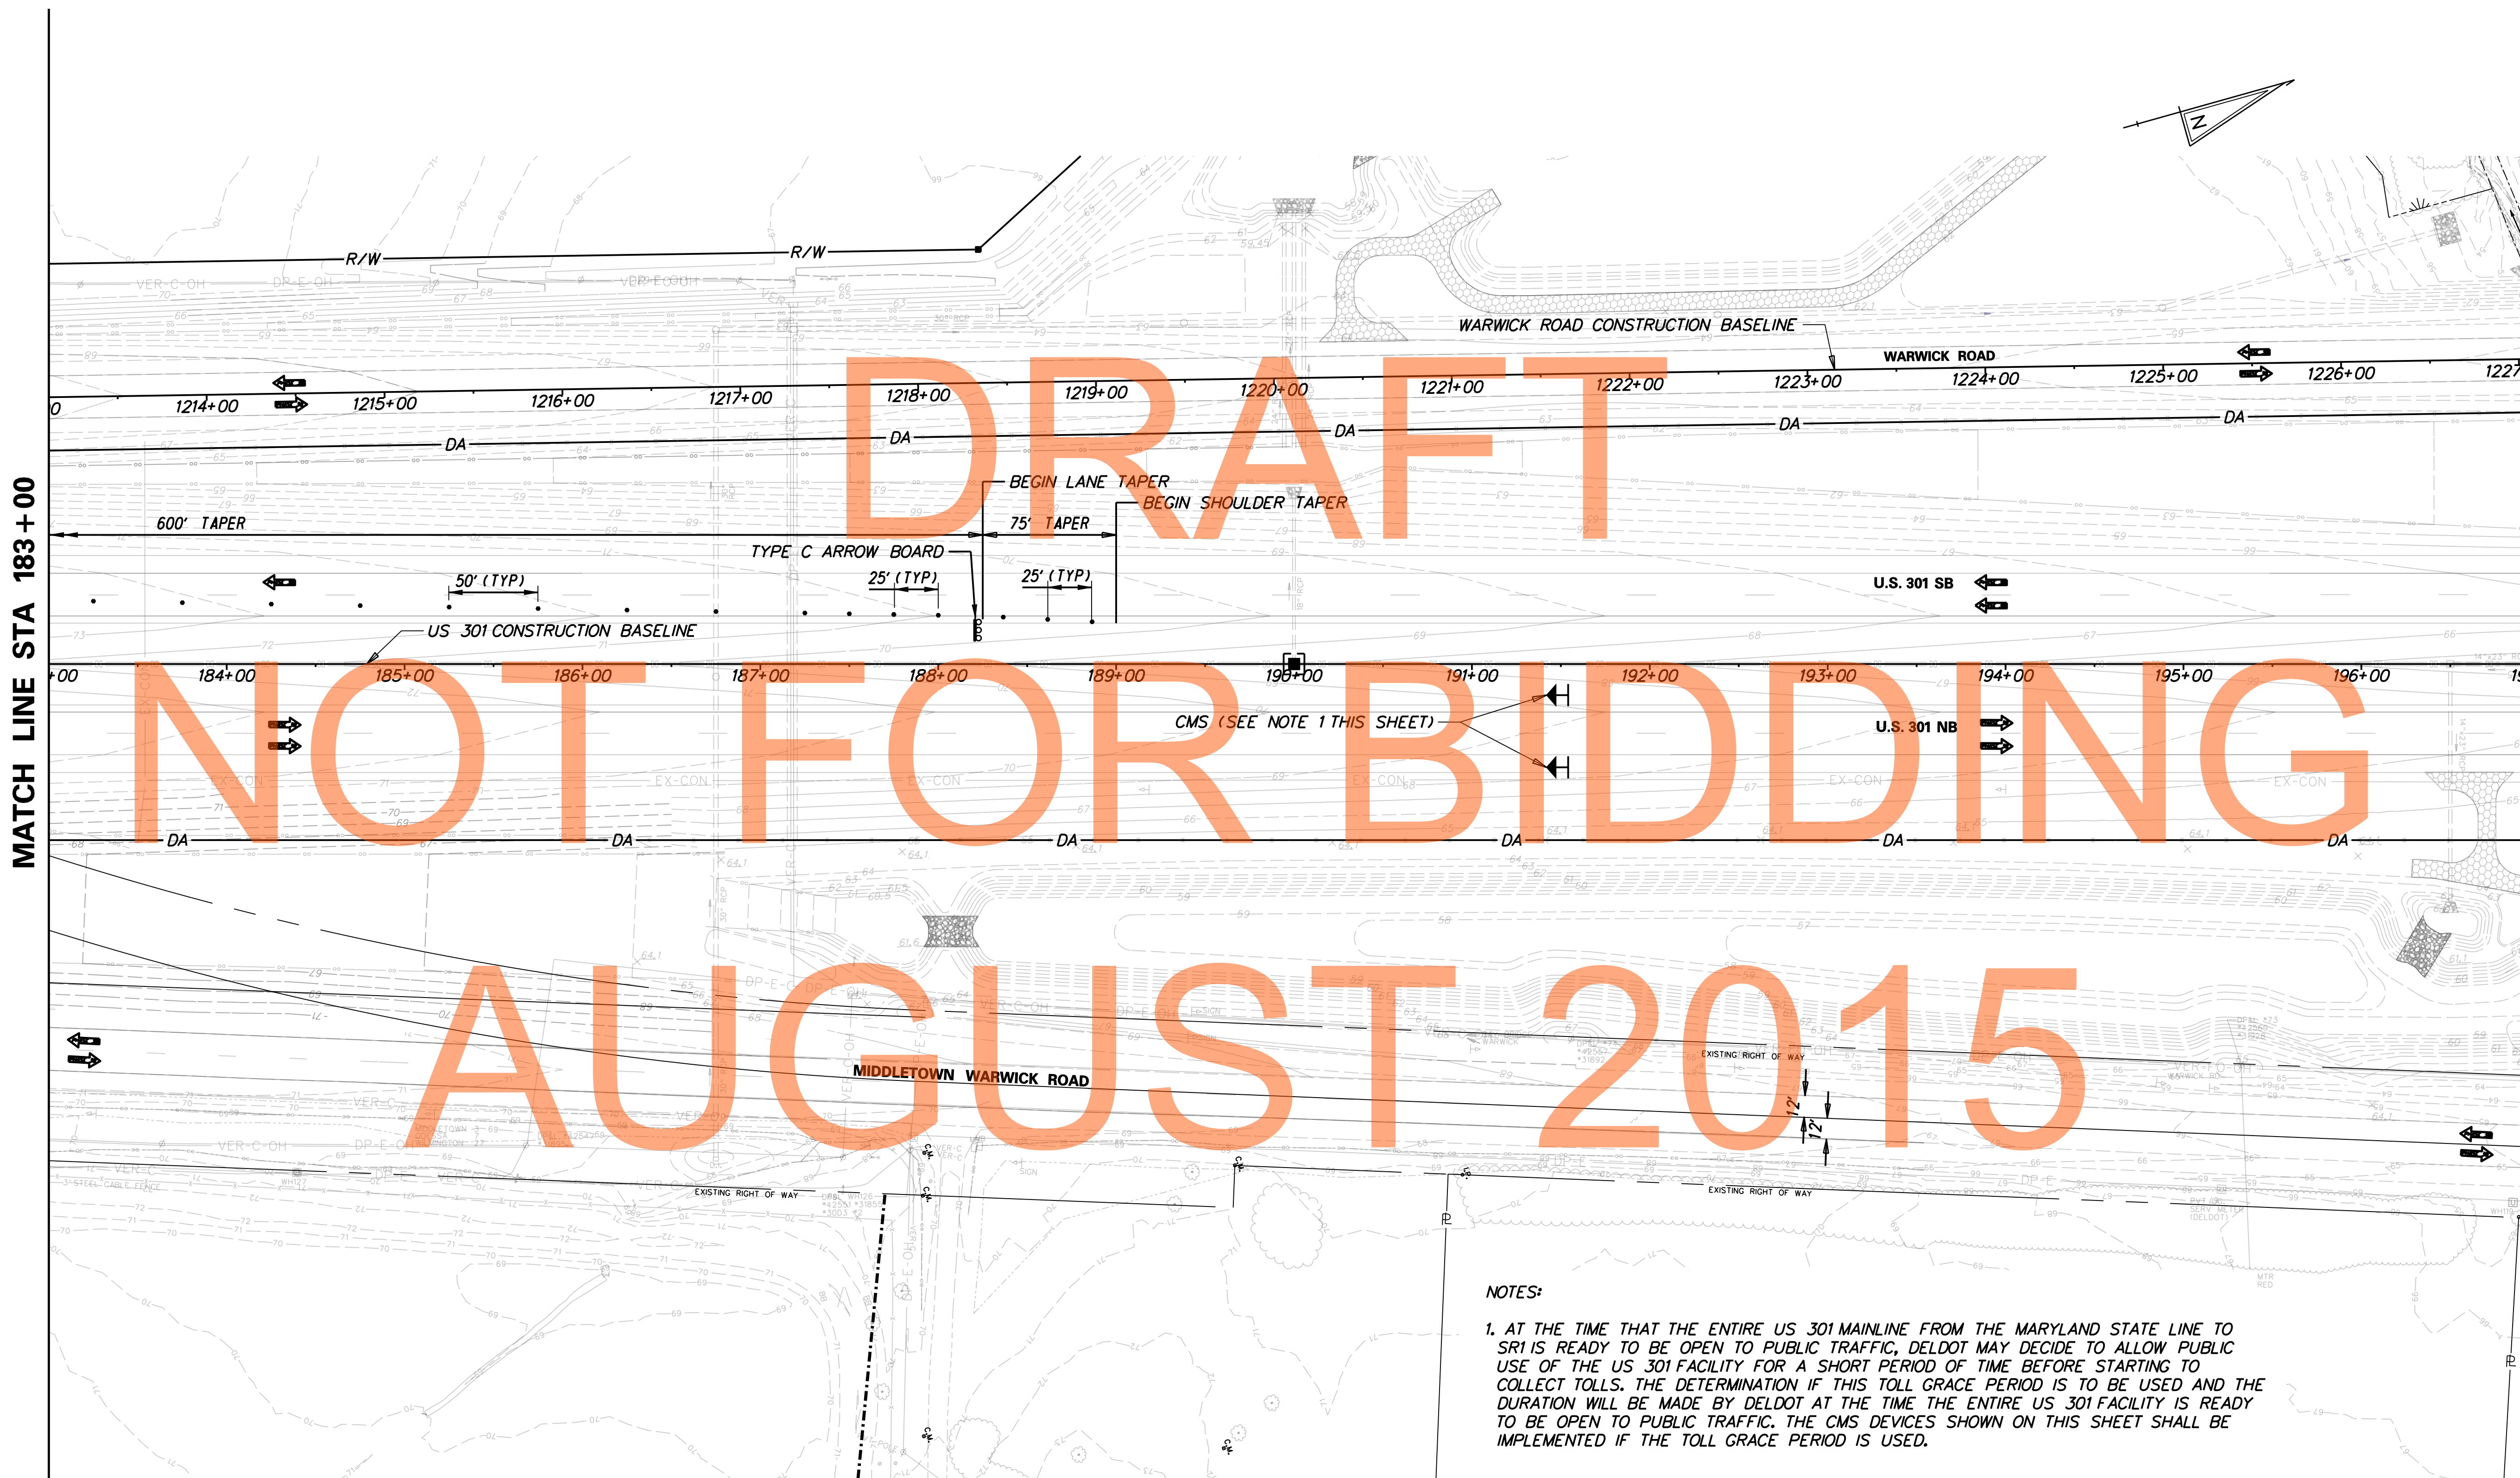

DRAFT

NOT FOR BIDDING

AUGUST 2015

NOTES:


1. AT THE TIME THAT THE ENTIRE US 301 MAINLINE FROM THE MARYLAND STATE LINE TO SRI IS READY TO BE OPEN TO PUBLIC TRAFFIC, DELDOT MAY DECIDE TO ALLOW PUBLIC USE OF THE US 301 FACILITY FOR A SHORT PERIOD OF TIME BEFORE STARTING TO COLLECT TOLLS. THE DETERMINATION IF THIS TOLL GRACE PERIOD IS TO BE USED AND THE DURATION WILL BE MADE BY DELDOT AT THE TIME THE ENTIRE US 301 FACILITY IS READY TO BE OPEN TO PUBLIC TRAFFIC. THE CMS DEVICES SHOWN ON THIS SHEET SHALL BE IMPLEMENTED IF THE TOLL GRACE PERIOD IS USED.

J:\2008 PROJECTS\E3\34801\700CADD\750AET\DESIGN_SECTION_2_PLANS\MD_301AETDS2_033.DGN



**DELAWARE
DEPARTMENT OF TRANSPORTATION**

ADDENDUMS / REVISIONS	

 
 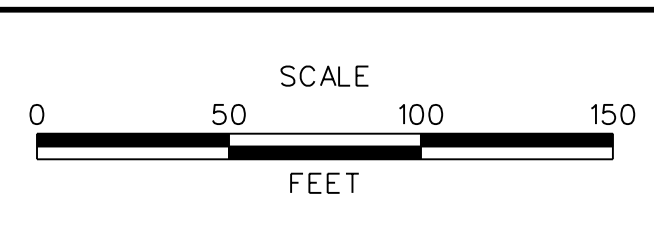



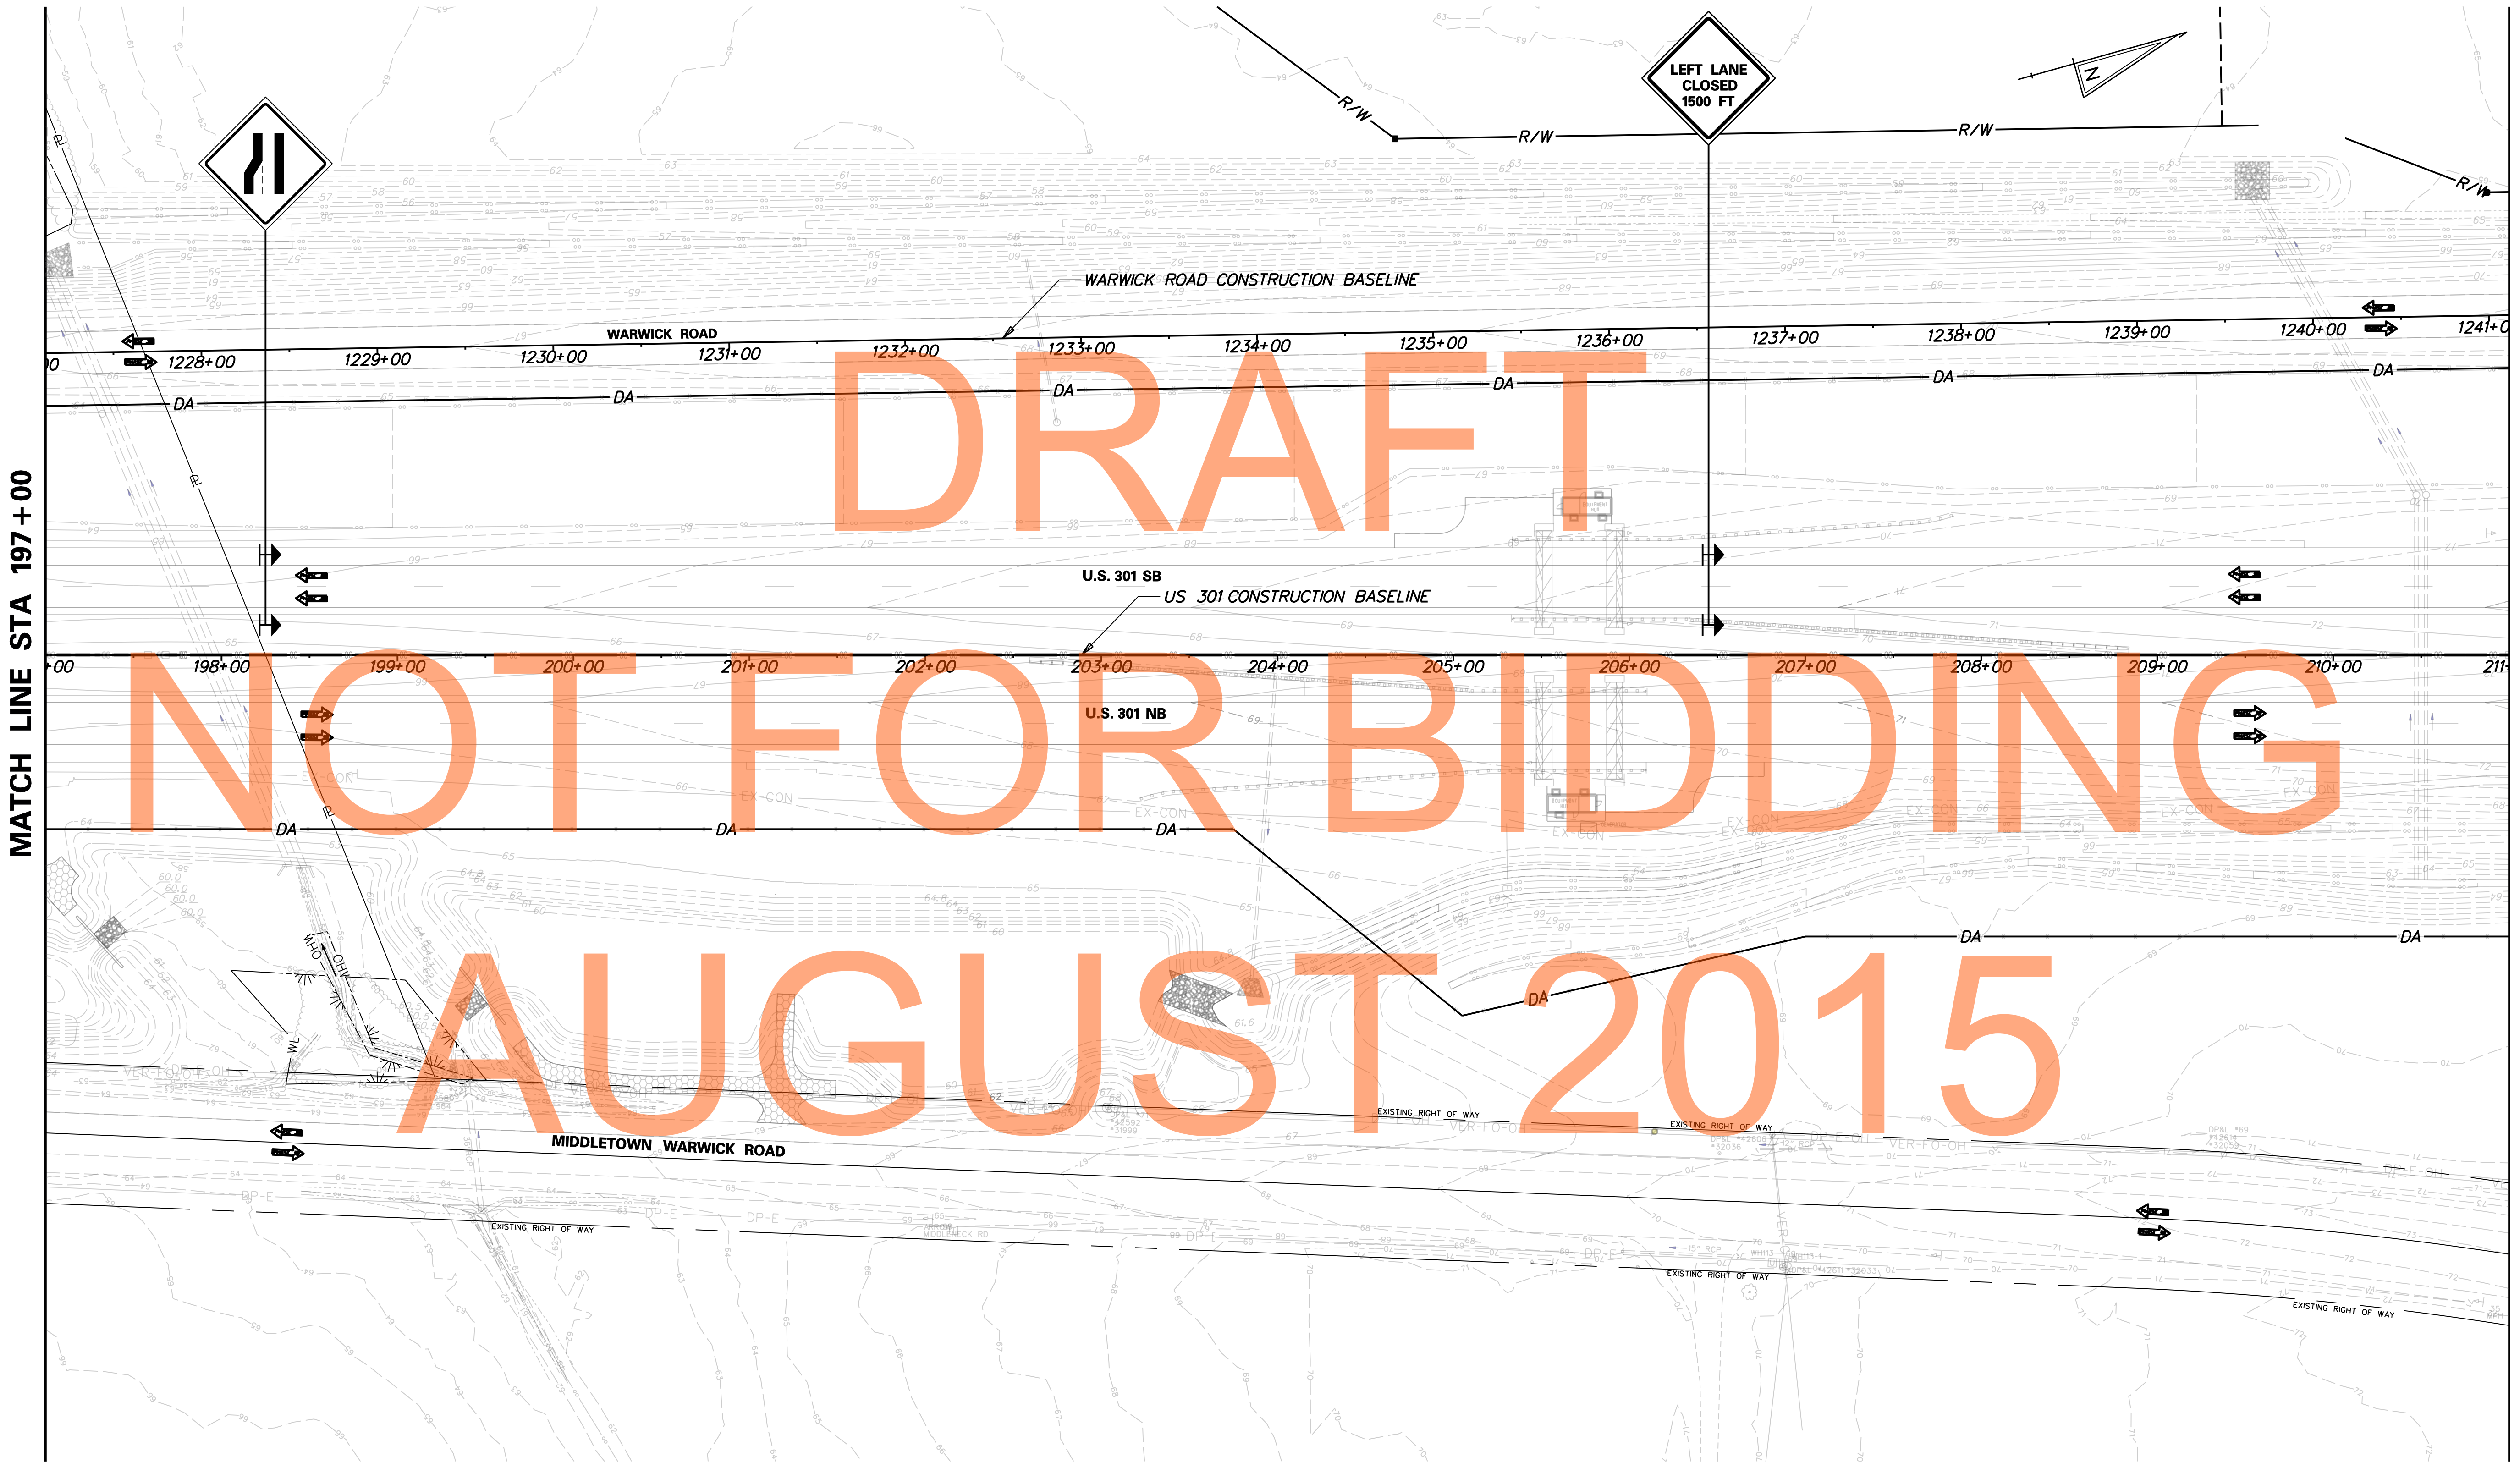
**US 301
MARYLAND STATE LINE
TO LEVELS ROAD**

CONTRACT T200911303	BRIDGE NO.
COUNTY NEW CASTLE	DESIGNED BY: MFM
	CHECKED BY: SKH

**CONSTRUCTION PHASING,
M.O.T., AND EROSION
CONTROL PLAN - PHASE 3B**

MD-33
SHEET NO. 1145
TOTAL SHTS. 1256

CONSTRUCTION PHASING LEGEND	
	WORK AREA THIS PHASE
	TEMPORARY CONSTRUCTION
	TEMPORARY PAVEMENT MARKING ARROW




J:\2008 PROJECTS\E3\34801\700CADD\750AET\DESIGN_SECTION_2_PLANS\MD_301AETDS2_034.DGN



**DELAWARE
DEPARTMENT OF TRANSPORTATION**

ADDENDUMS / REVISIONS	

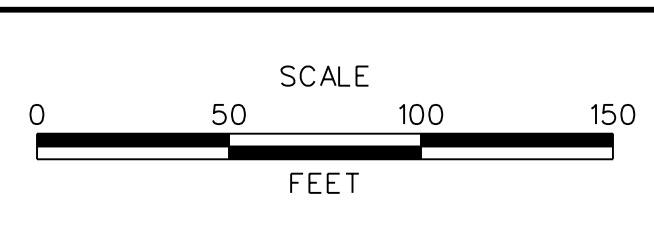




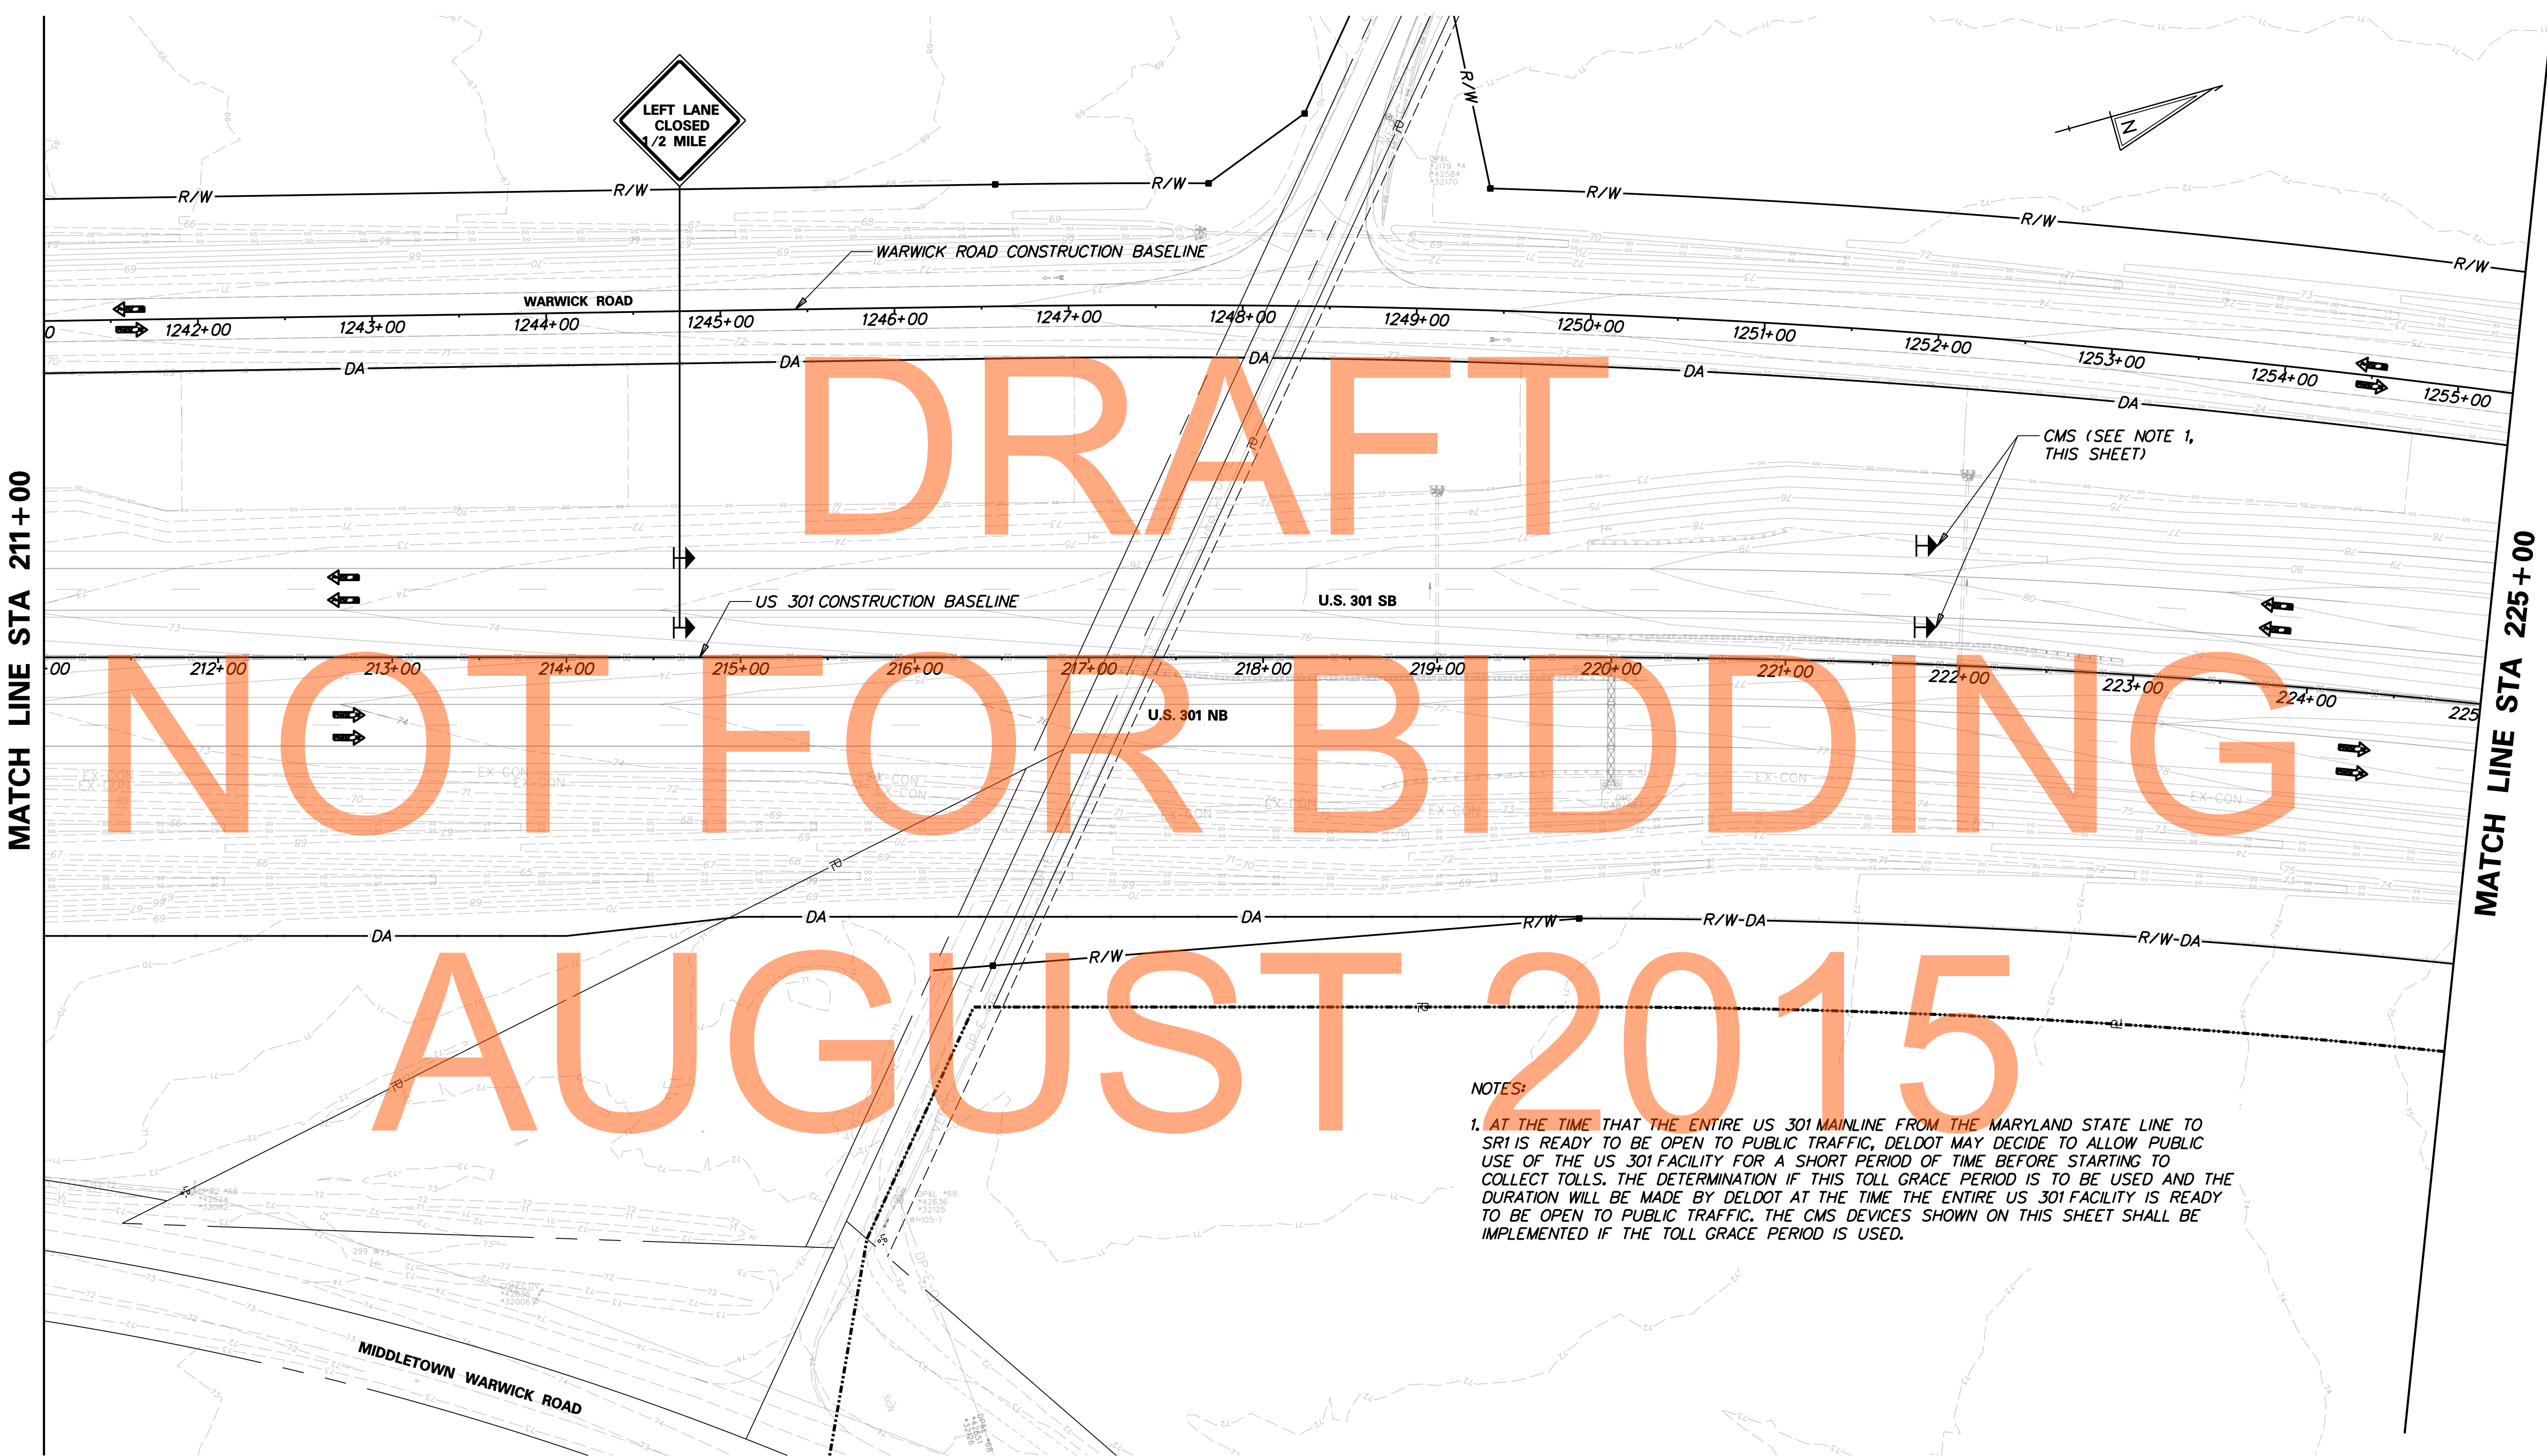
**US 301
MARYLAND STATE LINE
TO LEVELS ROAD**

CONTRACT T200911303	BRIDGE NO.
COUNTY NEW CASTLE	DESIGNED BY: MFM
	CHECKED BY: SKH

**CONSTRUCTION PHASING,
M.O.T., AND EROSION
CONTROL PLAN - PHASE 3B**

MD-34
SHEET NO. 1146
TOTAL SHTS. 126

CONSTRUCTION PHASING LEGEND	
	WORK AREA THIS PHASE
	TEMPORARY CONSTRUCTION
	TEMPORARY PAVEMENT MARKING ARROW




NOTES:
 1. AT THE TIME THAT THE ENTIRE US 301 MAINLINE FROM THE MARYLAND STATE LINE TO SR1 IS READY TO BE OPEN TO PUBLIC TRAFFIC, DELDOT MAY DECIDE TO ALLOW PUBLIC USE OF THE US 301 FACILITY FOR A SHORT PERIOD OF TIME BEFORE STARTING TO COLLECT TOLLS. THE DETERMINATION IF THIS TOLL GRACE PERIOD IS TO BE USED AND THE DURATION WILL BE MADE BY DELDOT AT THE TIME THE ENTIRE US 301 FACILITY IS READY TO BE OPEN TO PUBLIC TRAFFIC. THE CMS DEVICES SHOWN ON THIS SHEET SHALL BE IMPLEMENTED IF THE TOLL GRACE PERIOD IS USED.

J:\2008 PROJECTS\E3X34801\700CADD\DESIGN SECTION 2 PLANS\MD_301DS2_035.DGN



DELAWARE
 DEPARTMENT OF TRANSPORTATION

ADDENDUMS / REVISIONS

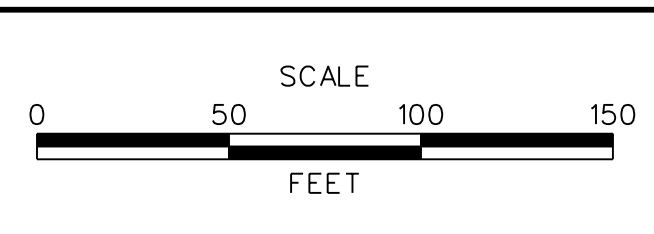
 



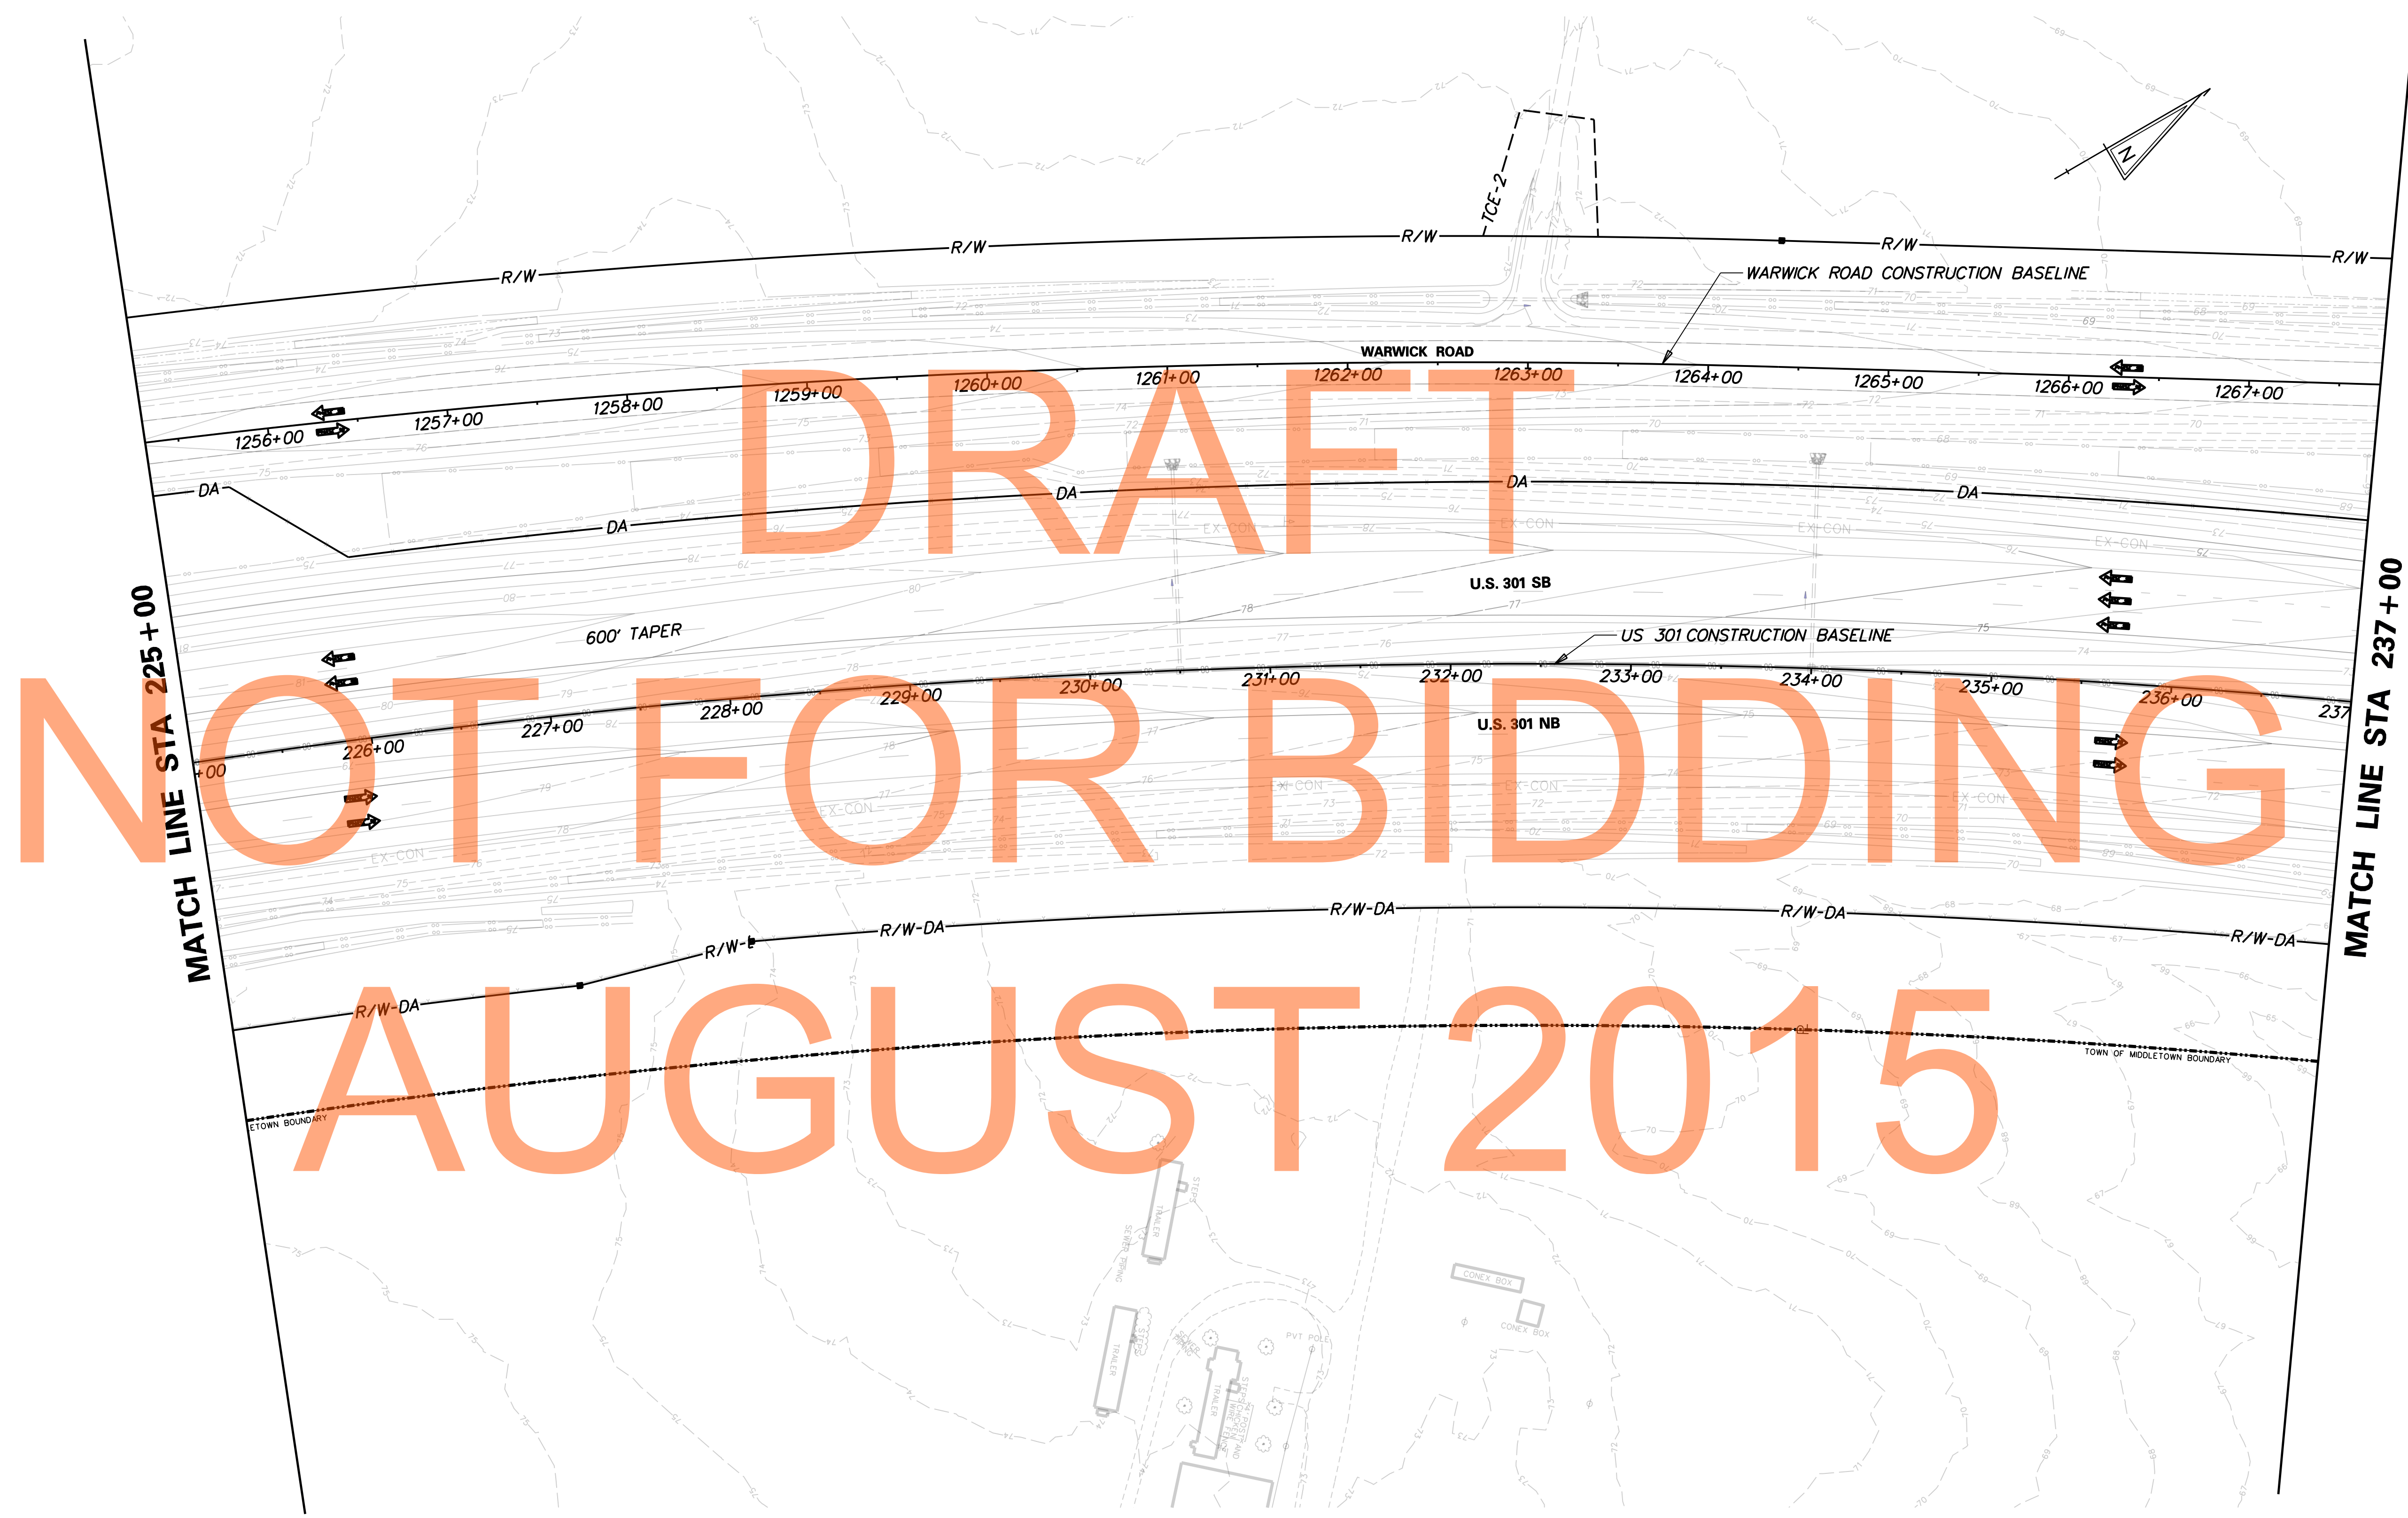
US 301
MARYLAND STATE LINE
TO LEVELS ROAD

CONTRACT T200911303	BRIDGE NO.
COUNTY NEW CASTLE	DESIGNED BY: MFM CHECKED BY: SKH


CONSTRUCTION PHASING,
M.O.T., AND EROSION
CONTROL PLAN - PHASE 3B

MD-35
SHEET NO. 1147
TOTAL SHTS. 1256

CONSTRUCTION PHASING LEGEND	
	WORK AREA THIS PHASE
	TEMPORARY CONSTRUCTION
	TEMPORARY PAVEMENT MARKING ARROW




J:\2008 PROJECTS\E3X34801\700CADD\702ROAD\DESIGN_SECTION_2_PLANS\MD_301DS2_036.DGN



DELAWARE
DEPARTMENT OF TRANSPORTATION

ADDENDUMS / REVISIONS	

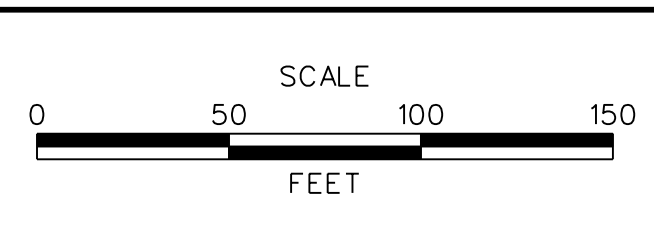
 



US 301
MARYLAND STATE LINE
TO LEVELS ROAD

CONTRACT T200911303	BRIDGE NO.
COUNTY NEW CASTLE	DESIGNED BY: MFM
	CHECKED BY: SKH

CONSTRUCTION PHASING,
M.O.T., AND EROSION
CONTROL PLAN - PHASE 3B

MD-36
SHEET NO. 1148
TOTAL SHTS. 1256

CONSTRUCTION PHASING LEGEND	
	WORK AREA THIS PHASE
	TEMPORARY CONSTRUCTION
	TEMPORARY PAVEMENT MARKING ARROW



DRAFT


NOT FOR BIDDING

AUGUST 2015

J:\2008 PROJECTS\E3X34801\700CADD\DESIGN_SECTION_2_PLANS\MD_301DS2_037.DGN



ADDENDUMS / REVISIONS	

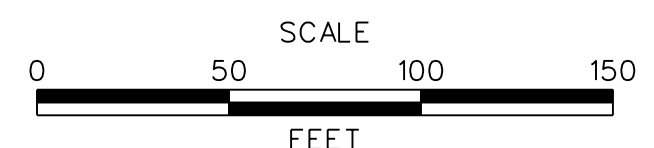




**US 301
MARYLAND STATE LINE
TO LEVELS ROAD**

CONTRACT T200911303	BRIDGE NO.
COUNTY NEW CASTLE	DESIGNED BY: MFM
	CHECKED BY: SKH

**CONSTRUCTION PHASING,
M.O.T., AND EROSION
CONTROL PLAN - PHASE 3B**

MD-37
SHEET NO. 1149
TOTAL SHTS. 1256

CONSTRUCTION PHASING LEGEND


	WORK AREA THIS PHASE
	TEMPORARY CONSTRUCTION
	TEMPORARY PAVEMENT MARKING ARROW

SEQUENCE OF CONSTRUCTION: PHASE 3C

OBJECTIVE: MAINTAIN TRAFFIC THROUGH E-ZPASS LANES FOR DURATION OF TOLL GRACE PERIOD

1. INSTALL ALL TRAFFIC CONTROL DEVICES AS SHOWN AND IMPLEMENT PHASE 3C TRAFFIC CONTROL SCHEME.
2. INSPECT AND MAINTAIN ALL EXISTING EROSION AND SEDIMENT CONTROL FACILITIES AND FEATURES. THE ENGINEER MUST GRANT APPROVAL PRIOR TO THE REMOVAL OF ANY EROSION AND SEDIMENT CONTROL DEVICE.

NOTE: UPON COMPLETION OR TEMPORARY CESSATION OF AN EARTH DISTURBANCE ACTIVITY, OR ANY STAGE THEREOF, THE PROJECT SITE SHALL BE IMMEDIATELY STABILIZED WITH THE APPROPRIATE TEMPORARY OR PERMANENT STABILIZATION.

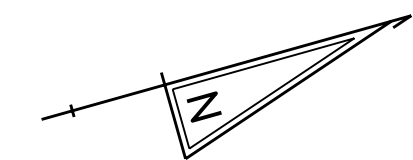

CMS TO BE PLACED IN THE MEDIAN AND IN THE OUTSIDE SHOULDER OF US 301 NB AT STA 132+50 (SEE NOTE 1 BELOW)

DRAFT
NOT FOR BIDDING
AUGUST 2015

MATCH LINE STA 169+00

NOTES:


1. AT THE TIME THAT THE ENTIRE US 301 MAINLINE FROM THE MARYLAND STATE LINE TO SR1 IS READY TO BE OPEN TO PUBLIC TRAFFIC, DELDOT MAY DECIDE TO ALLOW PUBLIC USE OF THE US 301 FACILITY FOR A SHORT PERIOD OF TIME BEFORE STARTING TO COLLECT TOLLS. THE DETERMINATION IF THIS TOLL GRACE PERIOD IS TO BE USED AND THE DURATION WILL BE MADE BY DELDOT AT THE TIME THE ENTIRE US 301 FACILITY IS READY TO BE OPEN TO PUBLIC TRAFFIC. THE CMS DEVICES SHOWN ON THIS SHEET SHALL BE IMPLEMENTED IF THE TOLL GRACE PERIOD IS USED.

J:\2008 PROJECTS\E3X34801\700CADD\750AET\DESIGN_SECTION_2_PLANS\MD_301AETDS2_038.DGN



**DELAWARE
DEPARTMENT OF TRANSPORTATION**

ADDENDUMS / REVISIONS	

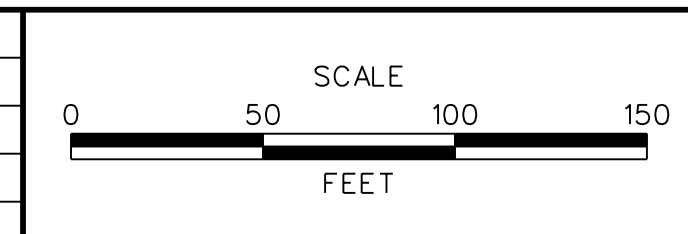


 

**US 301
MARYLAND STATE LINE
TO LEVELS ROAD**


CONTRACT T200911303	BRIDGE NO.
COUNTY NEW CASTLE	DESIGNED BY: MFM
	CHECKED BY: SKH

**CONSTRUCTION PHASING,
M.O.T., AND EROSION
CONTROL PLAN - PHASE 3C**

MD-38
SHEET NO. 1150
TOTAL SHTS. 1256

CONSTRUCTION PHASING LEGEND

	WORK AREA THIS PHASE
	TEMPORARY CONSTRUCTION
	TEMPORARY PAVEMENT MARKING ARROW

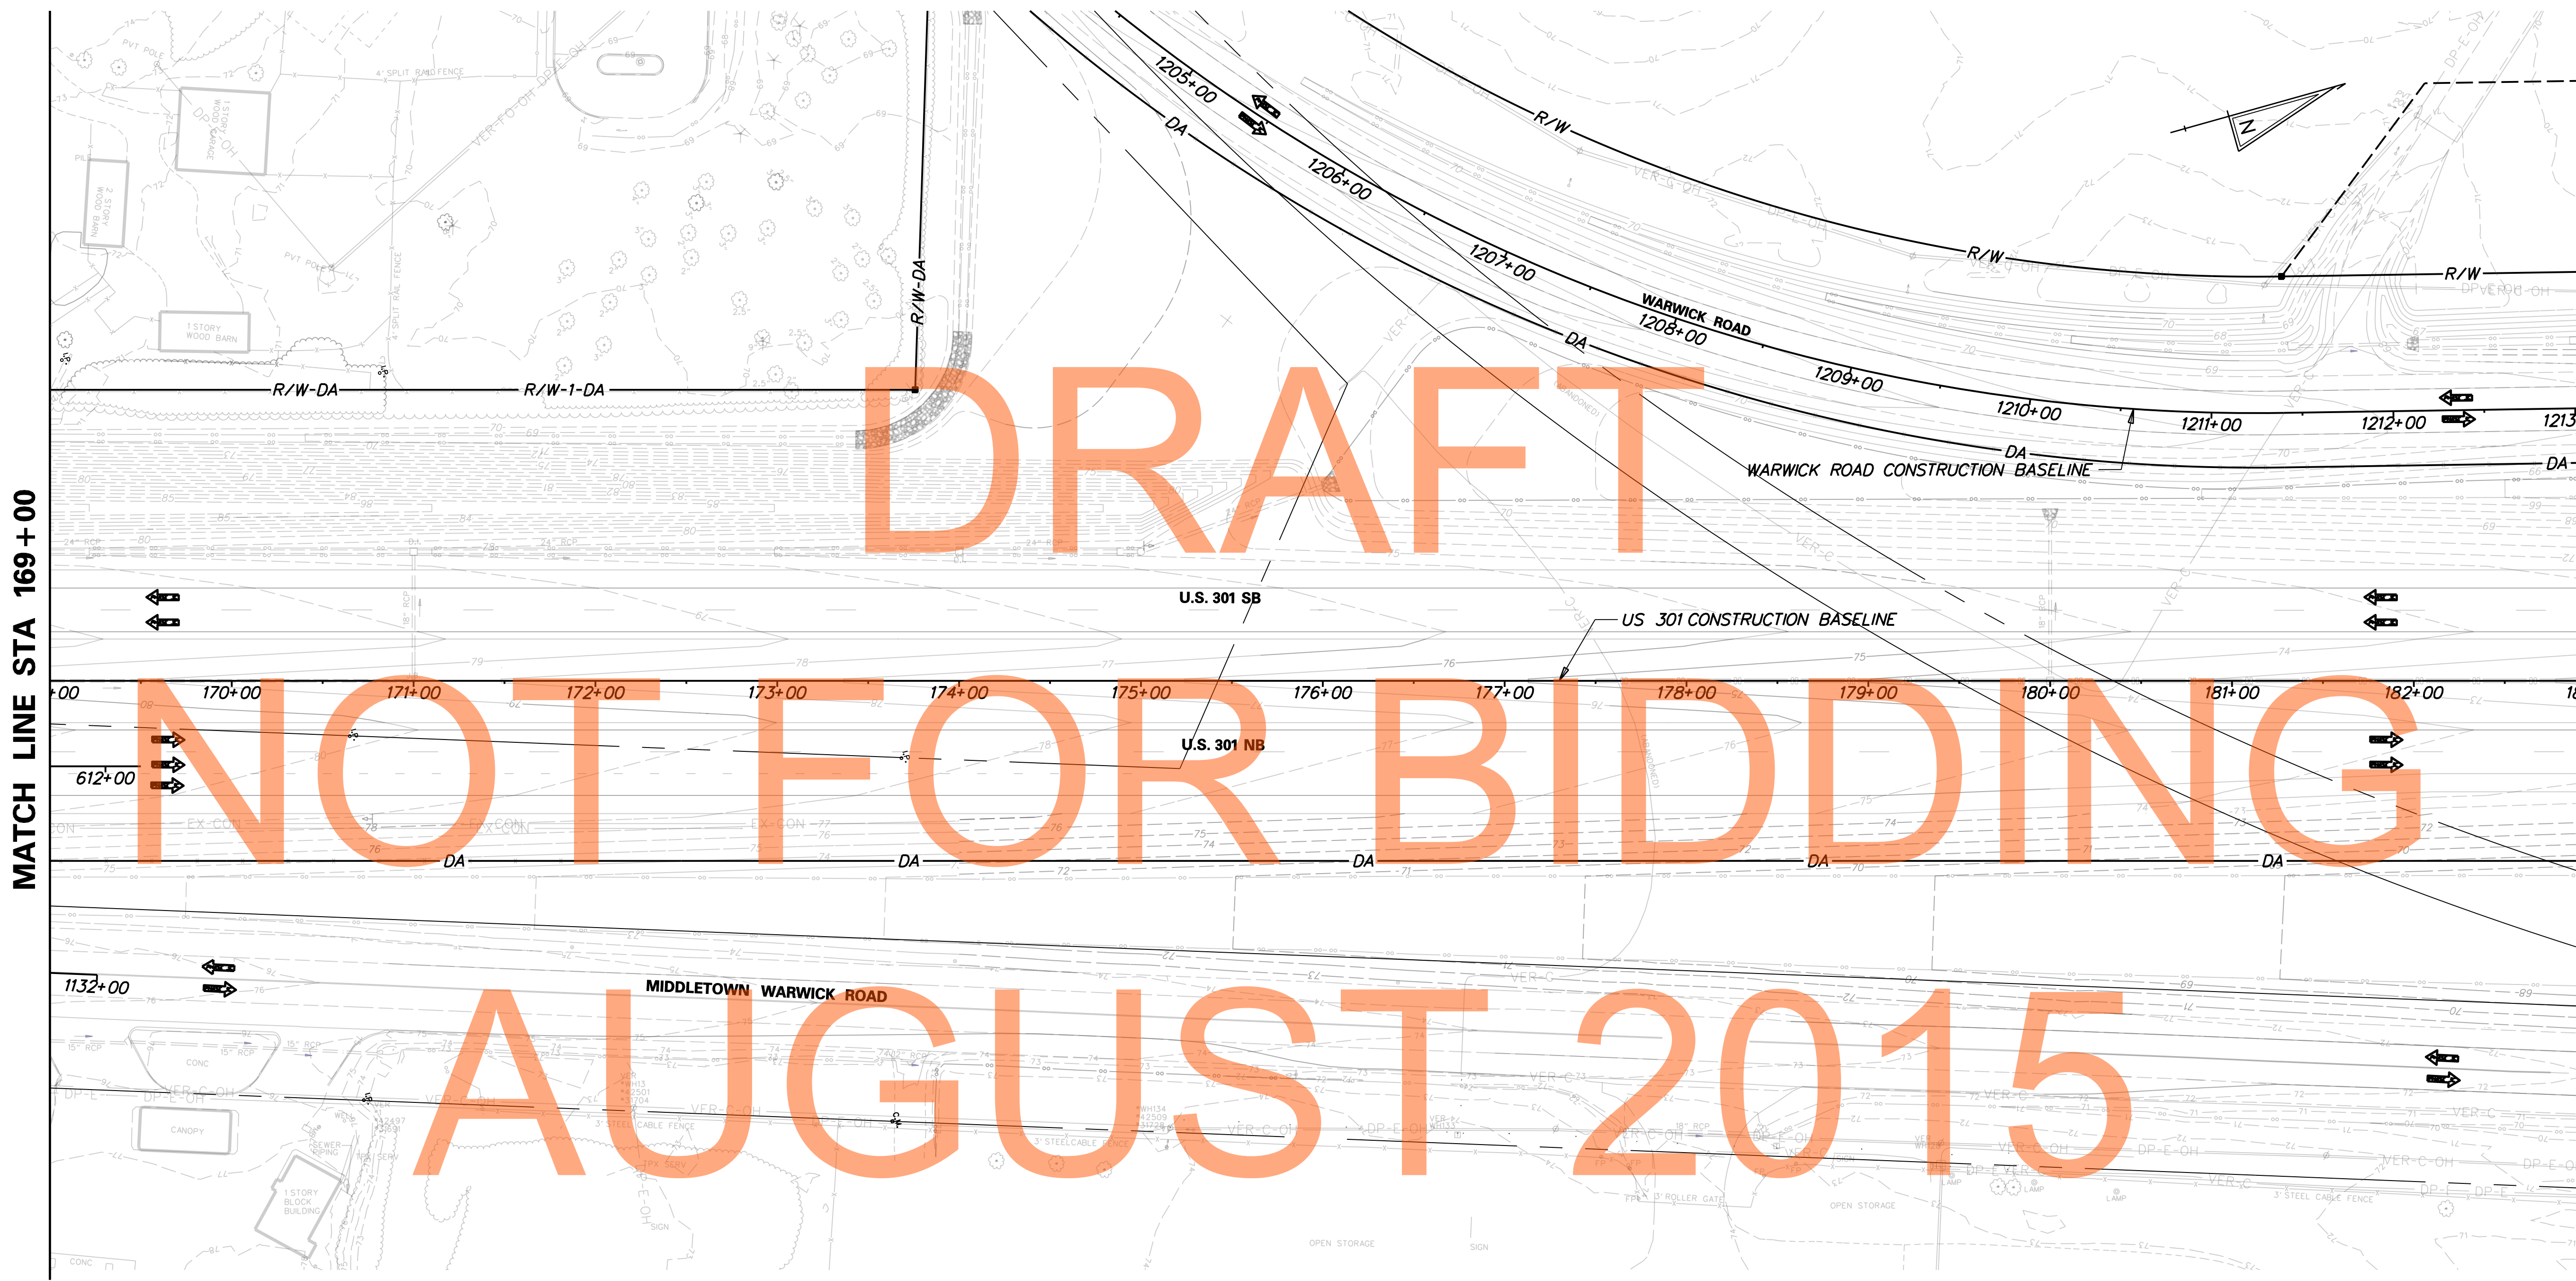

MATCH LINE STA 169+00

MATCH LINE STA 183+00

J:\2008 PROJECTS\E3\34801\700CADD\DESIGN_SECTION_2_PLANS\MD_301DS2_039.DGN



ADDENDUMS / REVISIONS	






**US 301
MARYLAND STATE LINE
TO LEVELS ROAD**


CONTRACT T200911303	BRIDGE NO.
COUNTY NEW CASTLE	DESIGNED BY: MFM
	CHECKED BY: SKH

CONSTRUCTION PHASING, M.O.T., AND EROSION CONTROL PLAN - PHASE 3C
TOTAL SHTS. 1256

MD-39
SHEET NO. 1151
TOTAL SHTS. 1256

CONSTRUCTION PHASING LEGEND

	WORK AREA THIS PHASE
	TEMPORARY CONSTRUCTION
	TEMPORARY PAVEMENT MARKING ARROW

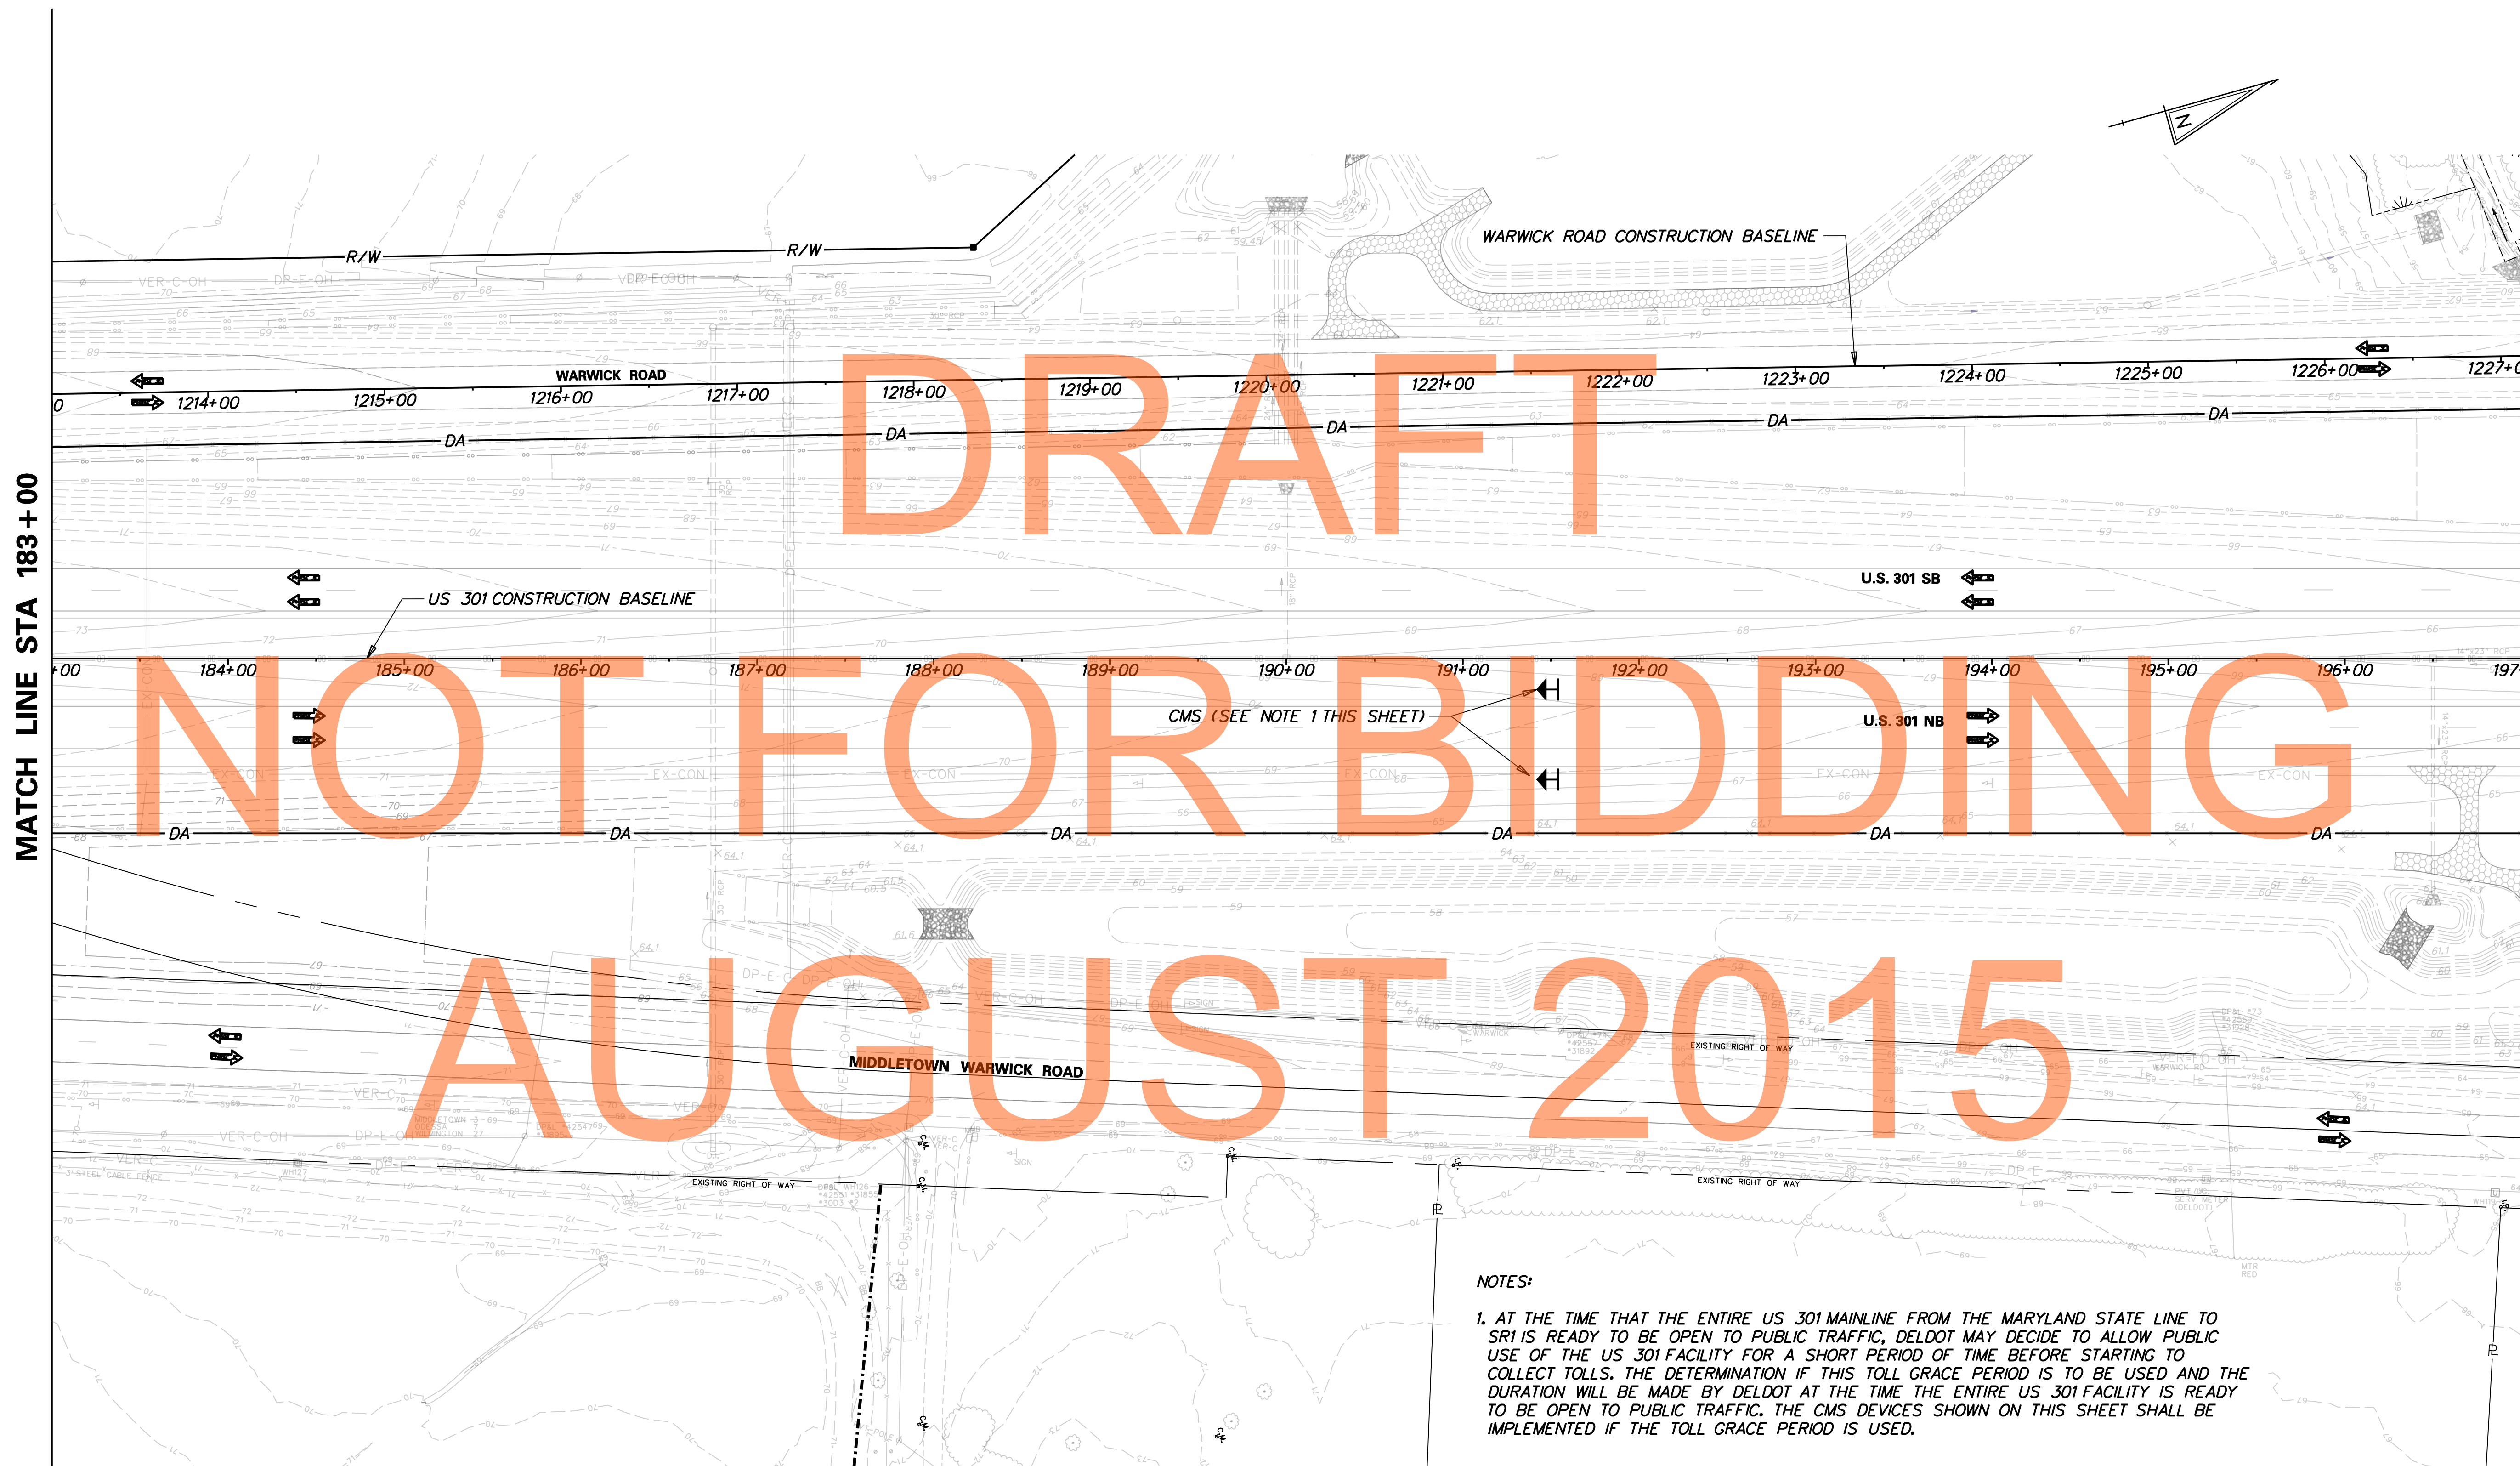

CMS (SEE NOTE 1 THIS SHEET)


NOTES:

1. AT THE TIME THAT THE ENTIRE US 301 MAINLINE FROM THE MARYLAND STATE LINE TO SRI IS READY TO BE OPEN TO PUBLIC TRAFFIC, DELDOT MAY DECIDE TO ALLOW PUBLIC USE OF THE US 301 FACILITY FOR A SHORT PERIOD OF TIME BEFORE STARTING TO COLLECT TOLLS. THE DETERMINATION IF THIS TOLL GRACE PERIOD IS TO BE USED AND THE DURATION WILL BE MADE BY DELDOT AT THE TIME THE ENTIRE US 301 FACILITY IS READY TO BE OPEN TO PUBLIC TRAFFIC. THE CMS DEVICES SHOWN ON THIS SHEET SHALL BE IMPLEMENTED IF THE TOLL GRACE PERIOD IS USED.

J:\2008 PROJECTS\E3\34801\700CADD\750AET\DESIGN_SECTION_2_PLANS\MD_301AETDS2_040.DGN



ADDENDUMS / REVISIONS

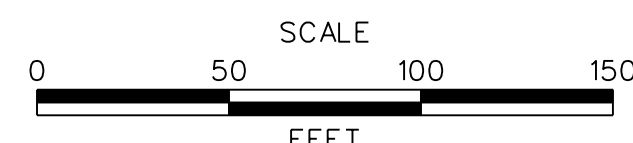


 

**US 301
MARYLAND STATE LINE
TO LEVELS ROAD**


CONTRACT	BRIDGE NO.
T200911303	
COUNTY	DESIGNED BY: MFM
NEW CASTLE	CHECKED BY: SKH

**CONSTRUCTION PHASING,
M.O.T., AND EROSION
CONTROL PLAN - PHASE 3C**


MD-40
SHEET NO. 1152
TOTAL SHTS. 1256

CONSTRUCTION PHASING LEGEND

	WORK AREA THIS PHASE
	TEMPORARY CONSTRUCTION
	TEMPORARY PAVEMENT MARKING ARROW

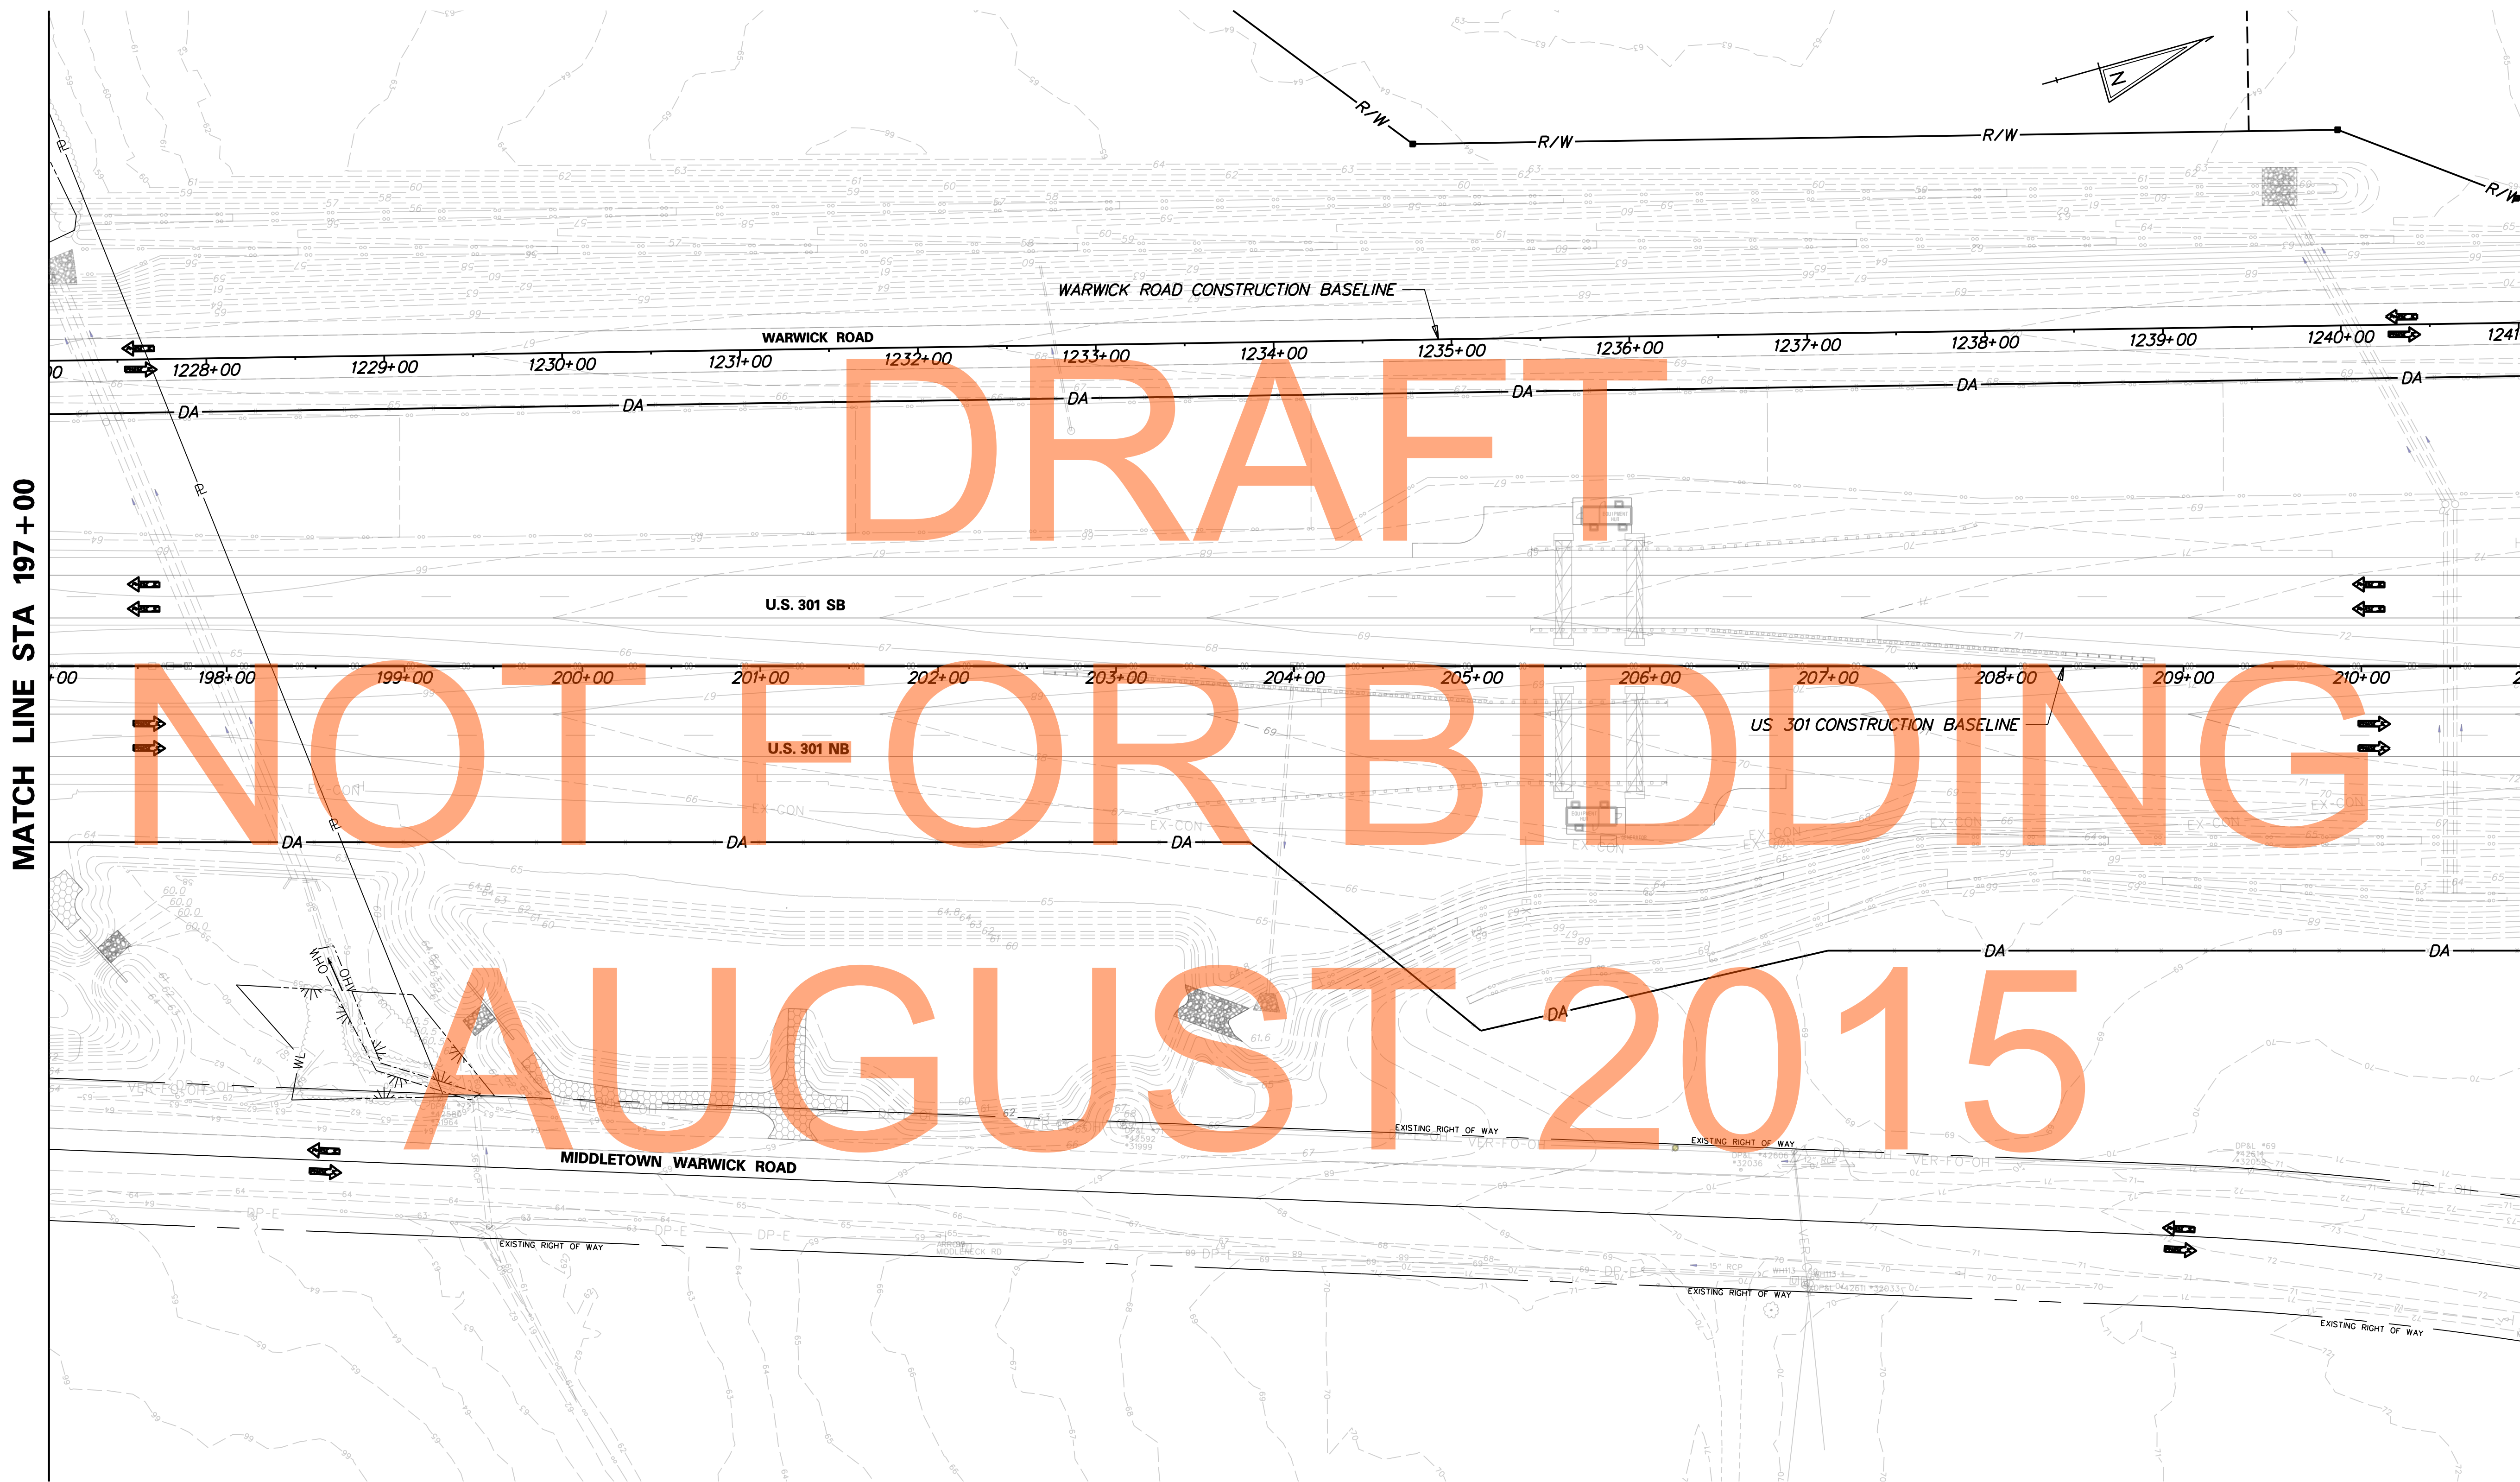


J:\2008 PROJECTS\E3\34801\700CADD\750AET\DESIGN_SECTION_2_PLANS\MD_301AETDS2_041.DGN



**DELAWARE
DEPARTMENT OF TRANSPORTATION**

ADDENDUMS / REVISIONS	

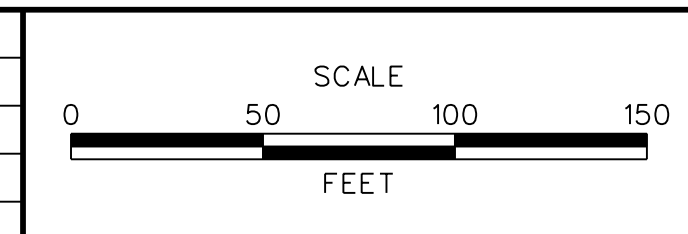


 

**US 301
MARYLAND STATE LINE
TO LEVELS ROAD**


CONTRACT T200911303	BRIDGE NO.
COUNTY NEW CASTLE	DESIGNED BY: MFM
	CHECKED BY: SKH

**CONSTRUCTION PHASING,
M.O.T., AND EROSION
CONTROL PLAN - PHASE 3C**

MD-41
SHEET NO. 1153
TOTAL SHTS. 1256

CONSTRUCTION PHASING LEGEND

	WORK AREA THIS PHASE
	TEMPORARY CONSTRUCTION
	TEMPORARY PAVEMENT MARKING ARROW

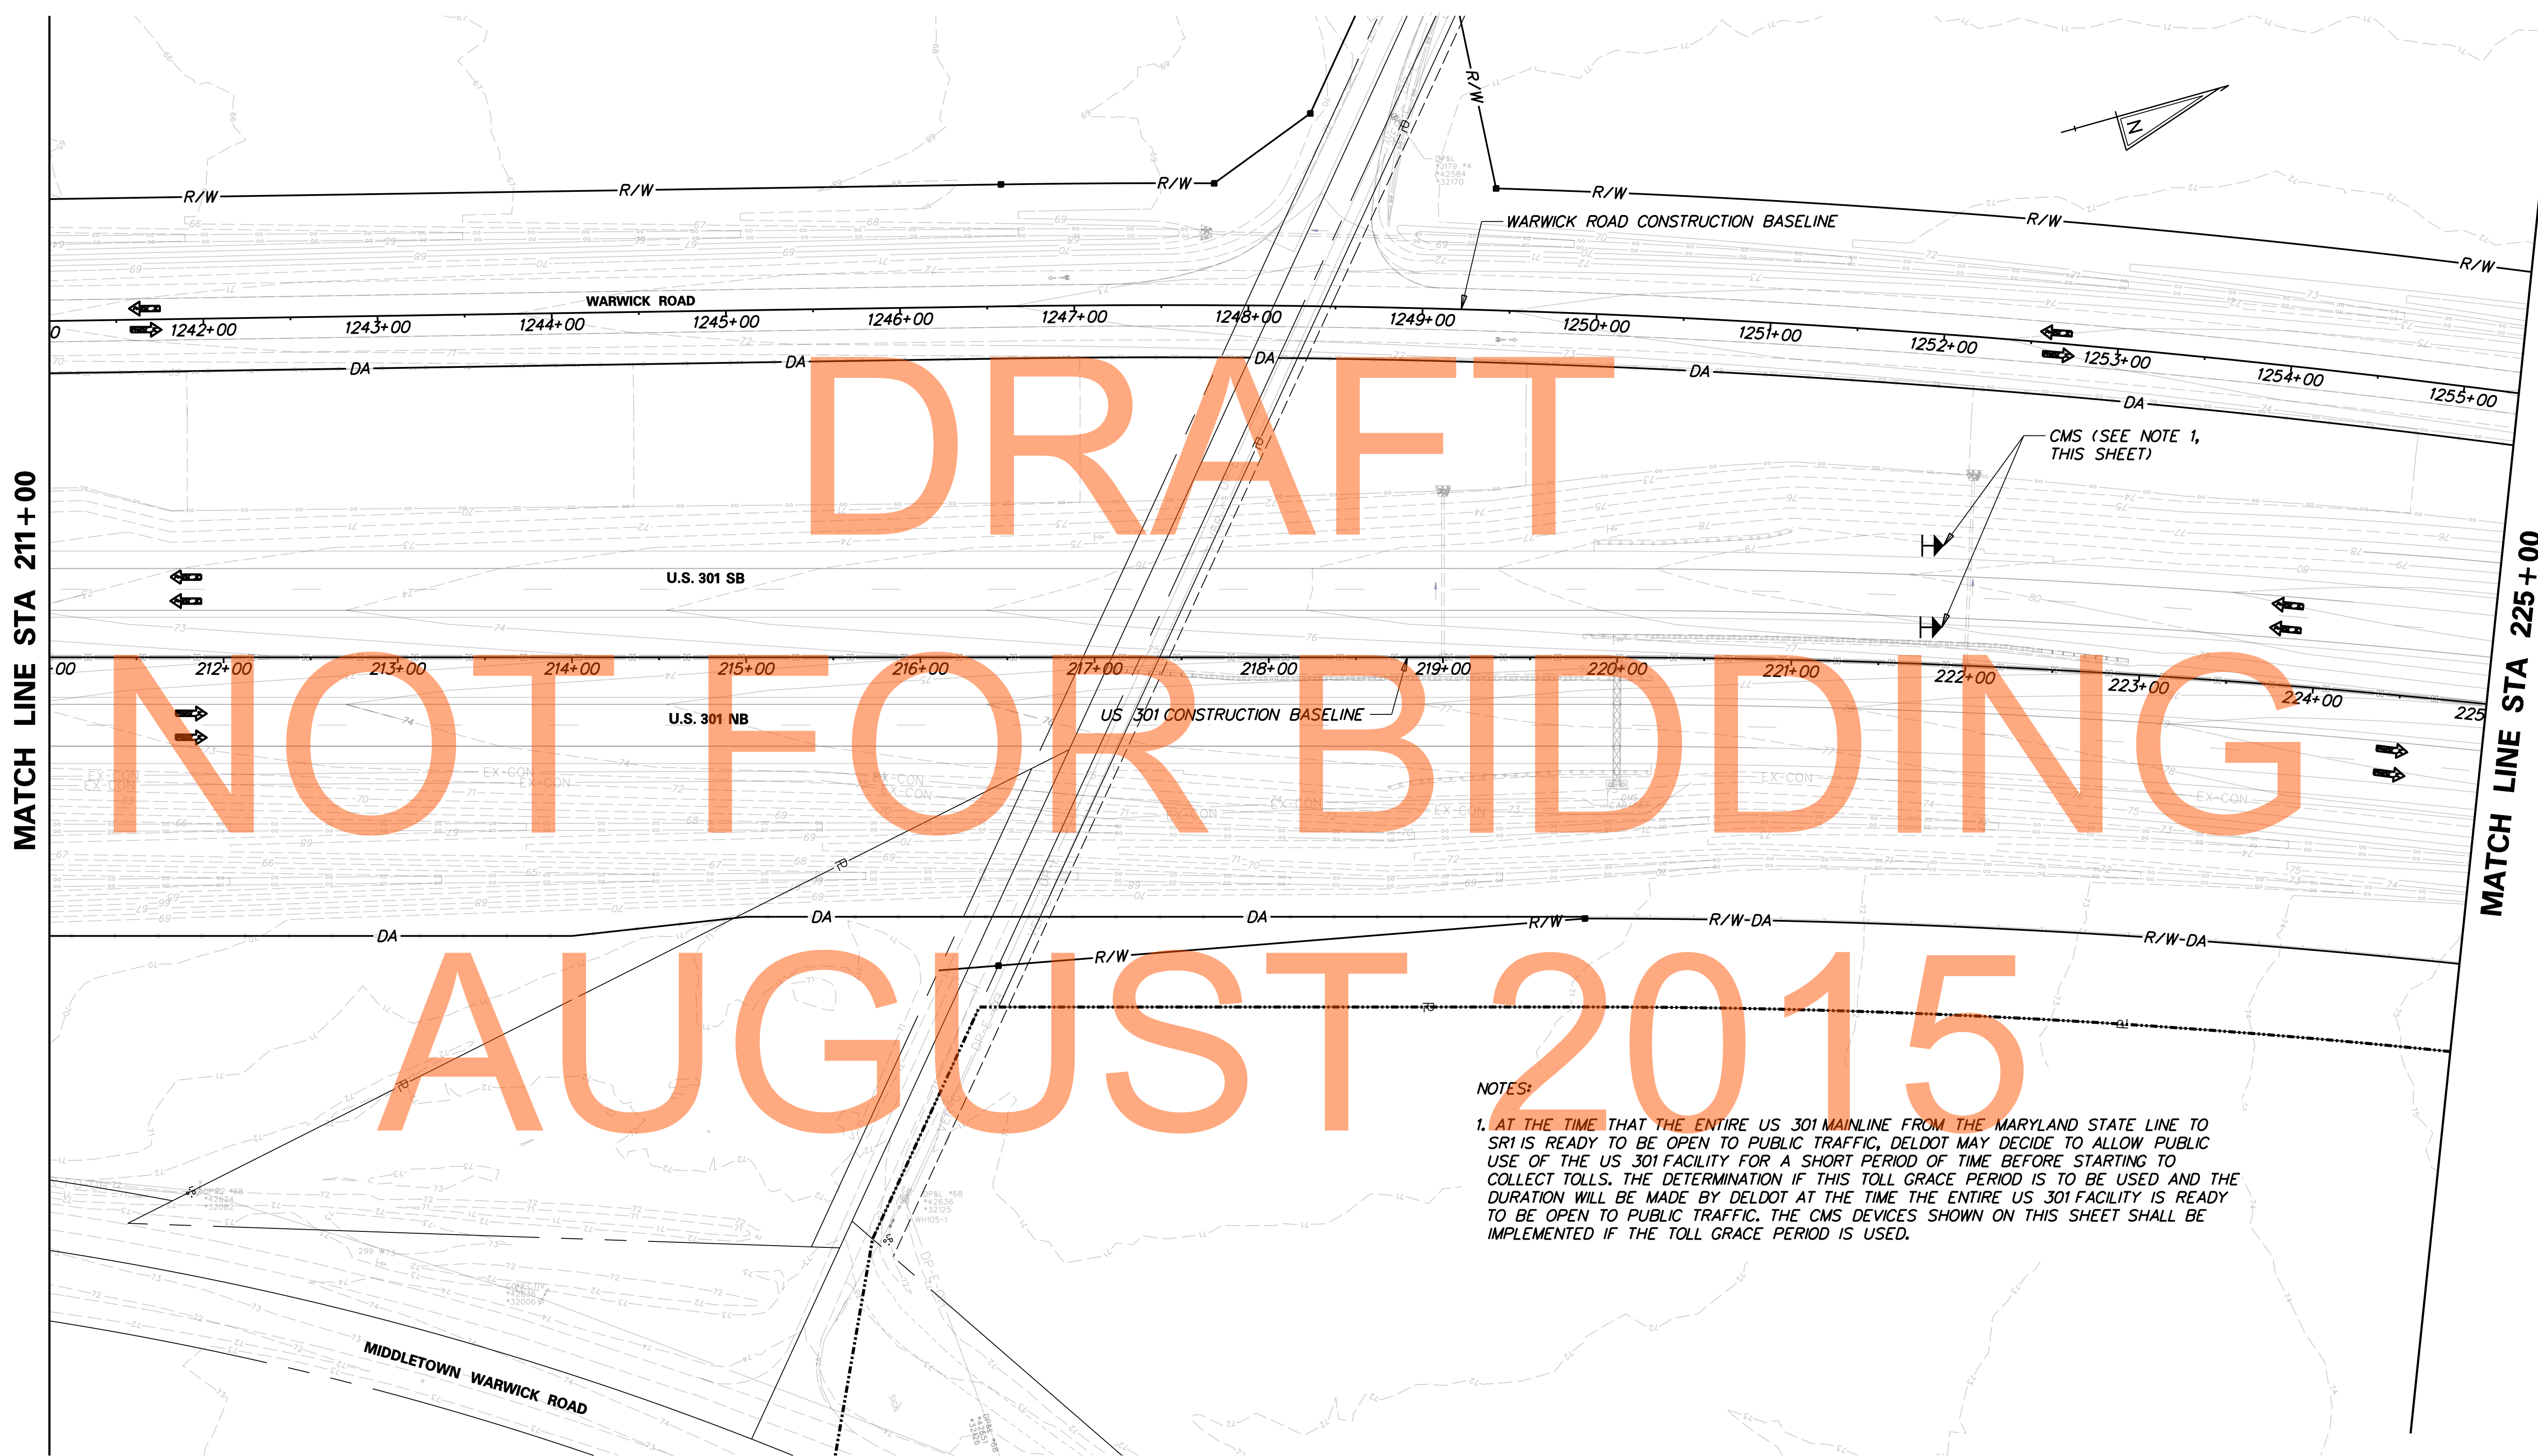

DRAFT

NOT FOR BIDDING

AUGUST 2015


NOTES:

1. AT THE TIME THAT THE ENTIRE US 301 MAINLINE FROM THE MARYLAND STATE LINE TO SR1 IS READY TO BE OPEN TO PUBLIC TRAFFIC, DELDOT MAY DECIDE TO ALLOW PUBLIC USE OF THE US 301 FACILITY FOR A SHORT PERIOD OF TIME BEFORE STARTING TO COLLECT TOLLS. THE DETERMINATION IF THIS TOLL GRACE PERIOD IS TO BE USED AND THE DURATION WILL BE MADE BY DELDOT AT THE TIME THE ENTIRE US 301 FACILITY IS READY TO BE OPEN TO PUBLIC TRAFFIC. THE CMS DEVICES SHOWN ON THIS SHEET SHALL BE IMPLEMENTED IF THE TOLL GRACE PERIOD IS USED.

J:\2008 PROJECTS\E3X34801\700CADD\DESIGN SECTION 2 PLANS\MD_301DS2_042.DGN



ADDENDUMS / REVISIONS	

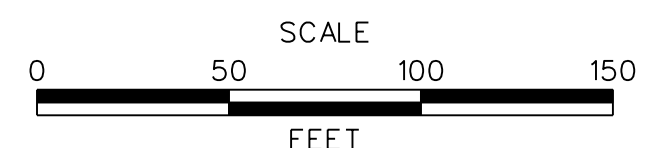
 



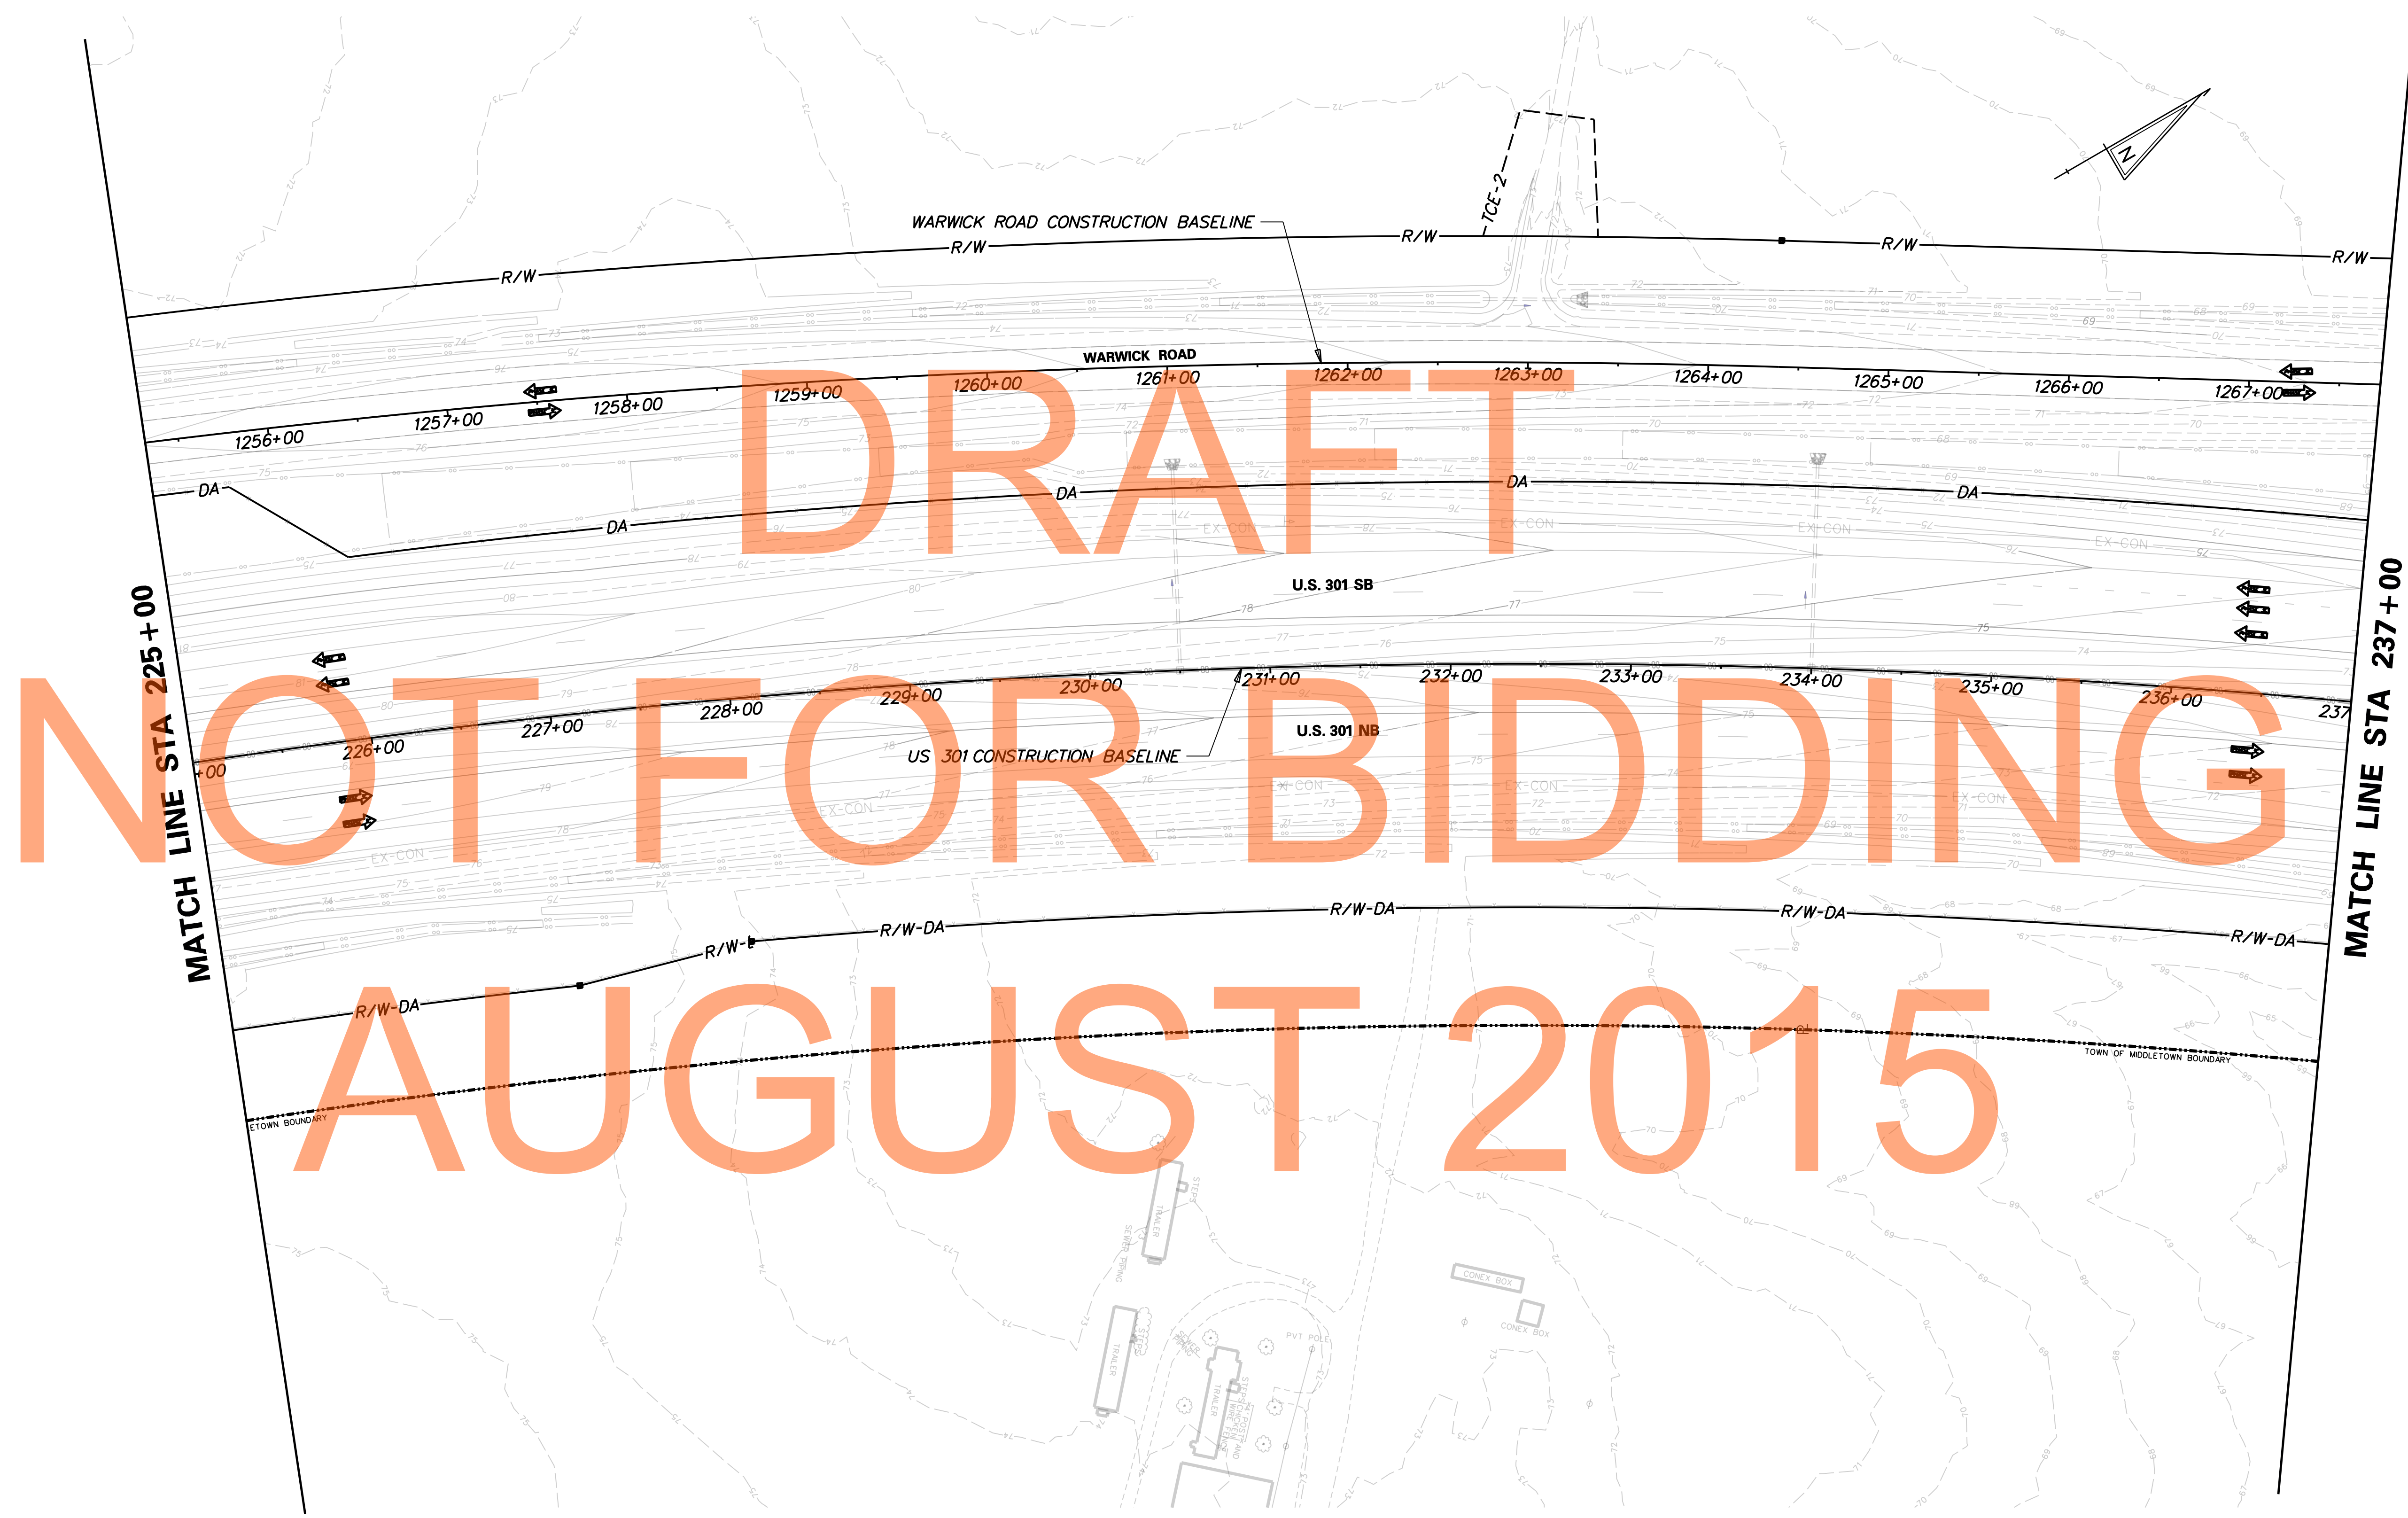
**US 301
MARYLAND STATE LINE
TO LEVELS ROAD**

CONTRACT	BRIDGE NO.
T200911303	
COUNTY	DESIGNED BY: MFM
NEW CASTLE	CHECKED BY: SKH

**CONSTRUCTION PHASING,
M.O.T., AND EROSION
CONTROL PLAN - PHASE 3C**

MD-42
SHEET NO. 1154
TOTAL SHTS. 1256

CONSTRUCTION PHASING LEGEND	
	WORK AREA THIS PHASE
	TEMPORARY CONSTRUCTION
	TEMPORARY PAVEMENT MARKING ARROW



DRAFT


NOT FOR BIDDING

AUGUST 2015

J:\2008 PROJECTS\E3X34801\700CADD\702ROAD\DESIGN_SECTION_2_PLANS\MD_301DS2_04.3.DGN



ADDENDUMS / REVISIONS	

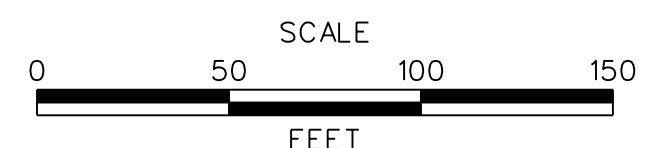
 



**US 301
MARYLAND STATE LINE
TO LEVELS ROAD**

CONTRACT T200911303	BRIDGE NO.
COUNTY NEW CASTLE	DESIGNED BY: MFM
	CHECKED BY: SKH

**CONSTRUCTION PHASING,
M.O.T., AND EROSION
CONTROL PLAN - PHASE 3C**

MD-43
SHEET NO. 1155
TOTAL SHTS. 1256


CONSTRUCTION PHASING LEGEND	
	WORK AREA THIS PHASE
	TEMPORARY CONSTRUCTION
	TEMPORARY PAVEMENT MARKING ARROW



J:\2008 PROJECTS\E3X34801\700CADD\750AET\DESIGN_SECTION_2_PLANS\MD_301AETDS2_044.DGN

 **DELAWARE DEPARTMENT OF TRANSPORTATION**

ADDENDUMS / REVISIONS	

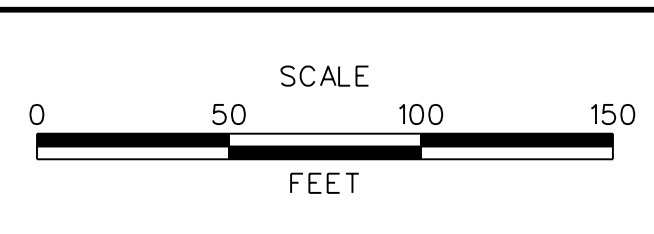

US 301 MARYLAND STATE LINE TO LEVELS ROAD



CONTRACT T200911303	BRIDGE NO.
COUNTY NEW CASTLE	DESIGNED BY: MFM
	CHECKED BY: SKH

CONSTRUCTION PHASING, M.O.T., AND EROSION CONTROL PLAN - PHASE 3C

MD-44
SHEET NO. 1156
TOTAL SHTS. 1256

LIGHTING STANDARD SCHEDULE					
NO.	CIRCUIT NO.	STATION	OFFSET	ARM	LIGHT STANDARD
25	D	175+61	78.5 RT.	-	40FT W/250W HPS OFFSET
26	D	177+16	78.5 RT.	-	40FT W/250W HPS OFFSET
27	D	178+71	78.5 RT.	-	40FT W/250W HPS OFFSET

LIGHTING SERVICE SCHEDULE			
SERVICE RUN	DISTANCE (L.F.)	DESCRIPTION	INSTALLATION
38	155.0	2 #2 & 1 #2 GND IN 4" SCH 80 PVC CONDUIT	TRENCH
39	155.0	2 #2 & 1 #2 GND IN 4" SCH 80 PVC CONDUIT	TRENCH
40	155.0	2 #2 & 1 #2 GND IN 4" SCH 80 PVC CONDUIT	TRENCH

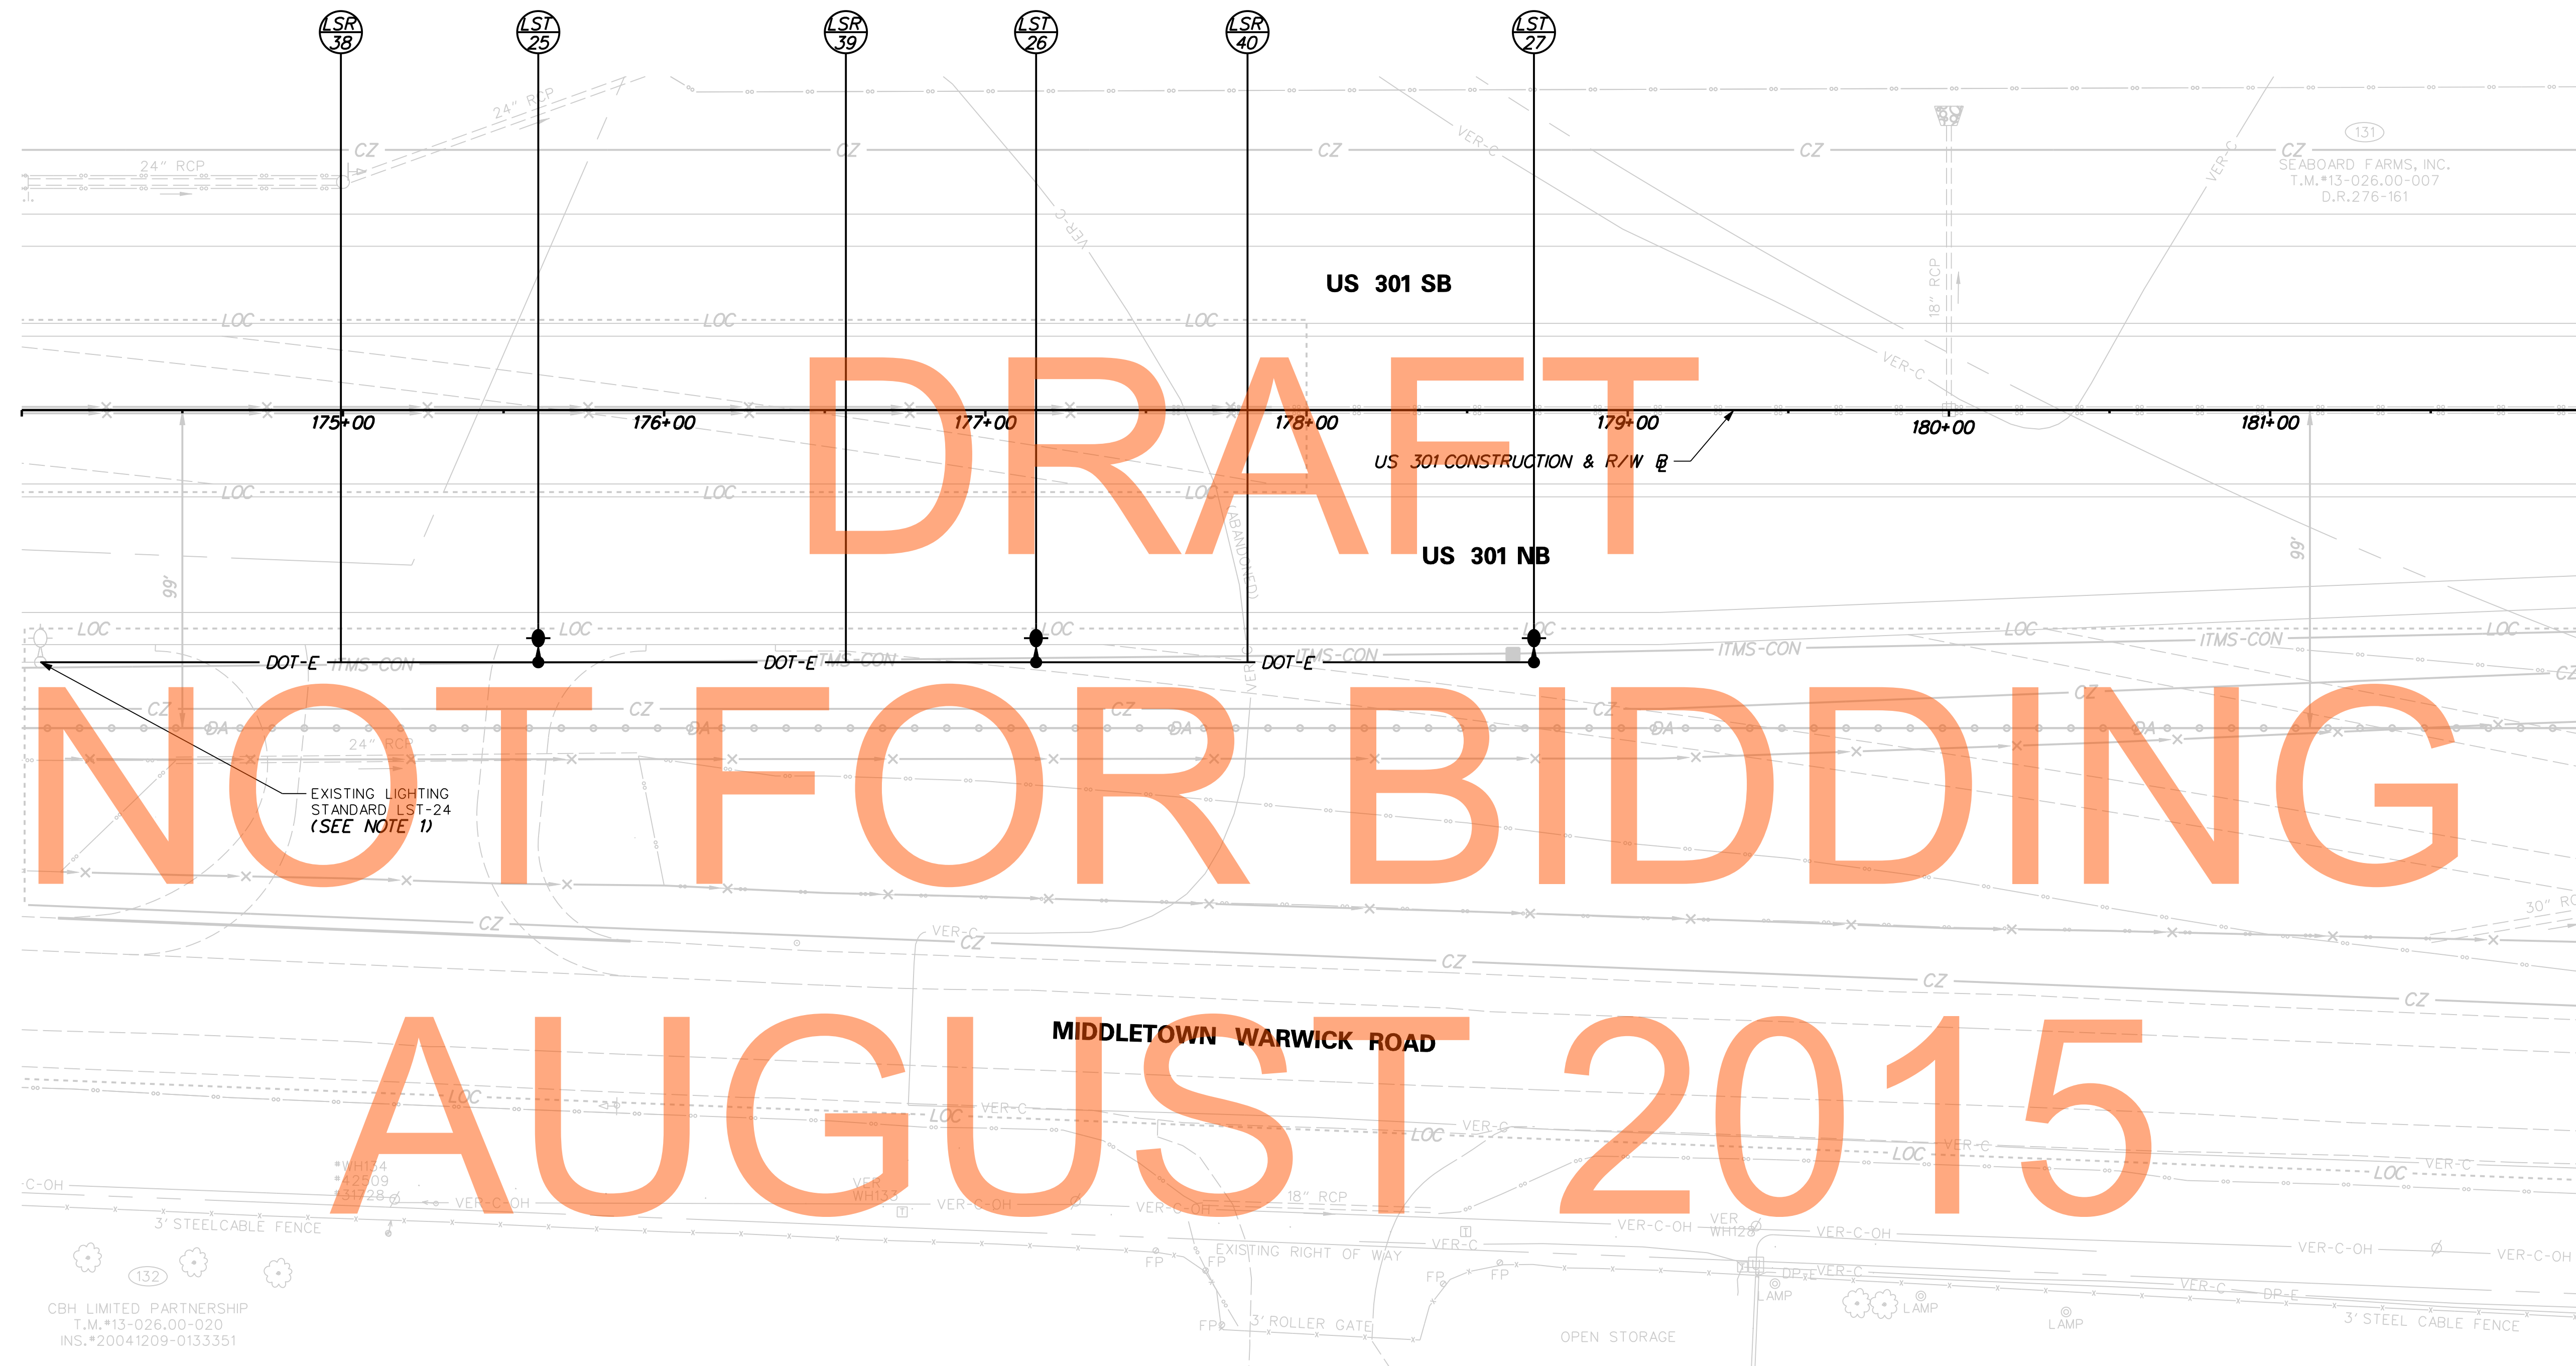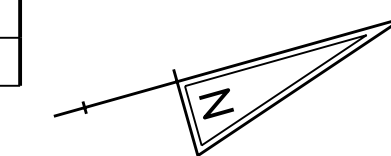

DRAFT

NOT FOR BIDDING

AUGUST 2015


NOTE:

- CONNECT LSR-38 TO CONDUIT STUB FROM EXISTING LIGHTING STANDARD INSTALLED IN CONTRACT T200811301. TURN POWER OFF IN PANEL LP-A, CIRCUIT "D" LOCATED AT WEIGH STATION PRIOR TO SPLICING CABLES LOCATED IN BASE OF LST-24. REENERGIZE CIRCUIT WHEN WORK IS COMPLETED.

J:\2008 PROJECTS\E3X34801\700CADD\750AET\DESIGN_SECTION_2_PLANS\MD_301AETDS2_045.DGN



ADDENDUMS / REVISIONS	

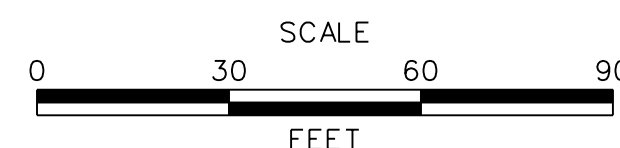

**US 301
MARYLAND STATE LINE
TO LEVELS ROAD**

CONTRACT T200911303	BRIDGE NO.
COUNTY NEW CASTLE	DESIGNED BY: ML
	CHECKED BY: JM

LIGHTING PLAN

MD-45
SHEET NO. 1157
TOTAL SHTS. 1256


PROJECT LIGHTING NOTES:

1. ALL OFFSET AND COBRA HEAD LIGHTING STANDARD POLE BASES SHALL BE TYPE 6.
2. SERVICE RUNS ARE SHOWN IN APPROXIMATE LOCATIONS. THE CONTRACTOR SHALL LOCATE THE SERVICE RUNS IN A MANNER THAT AVOIDS CONFLICTS WITH ALL EXISTING AND PROPOSED FEATURES AS FIELD CONDITIONS DICTATE AND AS APPROVED BY THE ENGINEER.
3. STATIONS AND OFFSETS NOTED IN THE LIGHTING STANDARD SCHEDULES ARE GIVEN TO THE CENTER OF THE POLE.
4. THE ELECTRICAL CONTRACTOR SHALL COORDINATE HIS WORK WITH ALL THE CONTRACTORS INVOLVED ON THIS PROJECT. THE ELECTRICAL CONTRACTOR SHALL COORDINATE WITH THE ENGINEER AND THE GENERAL SUPERINTENDENT THE LOCATIONS OF ALL CONDUIT AND POLE BASES TO ELIMINATE CONSTRUCTION CONFLICTS.
5. BURIED ELECTRICAL CABLE AND CONDUIT, AND OTHER UTILITIES MAY EXIST THROUGHOUT THIS PROJECT. THE EXISTING UTILITY LOCATIONS SHOWN ON THE PLANS ARE APPROXIMATE. THE CONTRACTOR SHALL BE RESPONSIBLE FOR LOCATING AND PREVENTING DAMAGE TO THEM, AND MAINTAINING THEM IN SERVICE WHEN AND WHERE REQUIRED. THE CONTRACTOR SHALL VERIFY THE EXACT LOCATIONS PRIOR TO COMMENCING WORK. THE CONTRACTOR SHALL VERIFY THE LOCATION OF ALL EXISTING UTILITIES BY HAND EXCAVATION PRIOR TO TRENCHING BY MACHINE.
6. COLOR CODING SHALL BE PROVIDED THROUGHOUT THE ENTIRE NETWORK FOR BRANCH AND CONTROL CONDUCTORS. EACH PHASE SHALL BE AN INDEPENDENT COLOR. CONDUCTORS SHALL HAVE FACTORY IMPREGNATED COLOR THROUGHOUT THEIR ENTIRE LENGTH. PHASE TAPING IS NOT PERMITTED.
7. ALL FUSED CONNECTIONS SHALL BE MADE IN THE TRANSFORMER BASE.
8. THE CONTRACTOR SHALL VERIFY ALL DIMENSIONS AND CONDITIONS AT THE SITE PRIOR TO WORK.
9. ALL CONDUITS, LIGHTING STANDARDS, ETC. SHALL BE STAKED OUT AND EVERY LOCATION APPROVED BY THE ENGINEER BEFORE ANY WORK IS DONE.
10. ALL GROUNDING CONDUCTORS IN PROPOSED UNDERGROUND CONDUITS SHALL BE STRANDED COPPER WITH SIZE AS NOTED IN THE LIGHTING SERVICE SCHEDULE.
11. THE CONTRACTOR SHALL VERIFY THE OPERATING VOLTAGE OF ALL CIRCUITS OF THE EXISTING LIGHTING SYSTEMS THAT ARE BEING TIED INTO TO ENSURE COMPATIBILITY WITH PROPOSED LUMINAIRES.
12. THE ELECTRICAL CONTRACTOR SHALL COORDINATE THE INSTALLATION OF LIGHTING CONDUITS WITH ITMS CONDUITS. ITMS AND LIGHTING CONDUITS MAY SHARE A COMMON TRENCH.
13. SPLICES FOR ALL ROADWAY LIGHTING ELECTRICAL CABLES, INCLUDING RE-CONNECTION OF EXISTING IMPACTED ELECTRICAL CABLES, SHALL BE COMPLETED USING APPROVED SPLICE KITS OR METHODS APPROVED BY THE ENGINEER AND SHALL BE INCIDENTAL TO THE SUPPLY AND INSTALLATION OF VARIOUS ROADWAY LIGHTING ELECTRICAL CABLES.
14. PROVIDE A DRAINAGE TEE AT THE LOW POINT OF CONDUIT RUN. DRAINAGE TEES SHALL BE INCIDENTAL TO CONDUIT ITEMS.
15. IN ADDITION TO THE CONDUIT LENGTHS IN THE SCHEDULES, AN ADDITIONAL 6' LENGTH OF CABLE SHALL BE ADDED AT EACH LIGHTING STANDARD LOCATION TO ACCOUNT FOR THE LENGTH OF CABLE EXTENDING INTO THE POLE BASE AND BACK DOWN TO CONTINUE THE LIGHTING CIRCUIT.
16. IF AN UNDERGROUND UTILITY IS DAMAGED, THE CONTRACTOR SHALL IMMEDIATELY NOTIFY THE ENGINEER AND THE OWNER OF THE UTILITY. ANY DAMAGED SUSTAINED TO UTILITIES ABOVE OR BELOW GROUND SHALL BE REPAIRED BY THE CONTRACTOR UNDER THE DIRECTION OF THE UTILITY OWNER AT THE CONTRACTOR'S EXPENSE. UNDER NO CIRCUMSTANCE SHALL THE CONTRACTOR BACKFILL AN EXCAVATION AFFECTING SAID UTILITY WITHOUT FIRST RECEIVING PERMISSION FROM THE UTILITY OWNER.
17. ALL PROPOSED OFFSET LIGHTING STANDARDS SHALL BE INSTALLED WITH BREAKAWAY TRANSFORMER BASES, WHETHER PROTECTED OR UNPROTECTED, UNLESS OTHERWISE NOTED.


NOTES:

1. CONDUIT BUSHINGS SHALL BE USED AT EACH END OF EVERY CONDUIT TO PREVENT CABLE DAMAGE.
2. CONNECTOR/FUSE KITS WILL BE INCIDENTAL TO THE PROVISION OF THE CONDUCTORS.
3. ALL LUMINAIRES WILL HAVE STANDARD 2" TENON MOUNTING.
4. INSULATION ON LIGHTING CONDUCTORS SHALL BE DIFFERENT COLORS, L1 CONDUCTOR SHALL BE BLACK, AND L2 CONDUCTOR SHALL BE RED.

DRAFT
NOT FOR BIDDING
AUGUST 2015

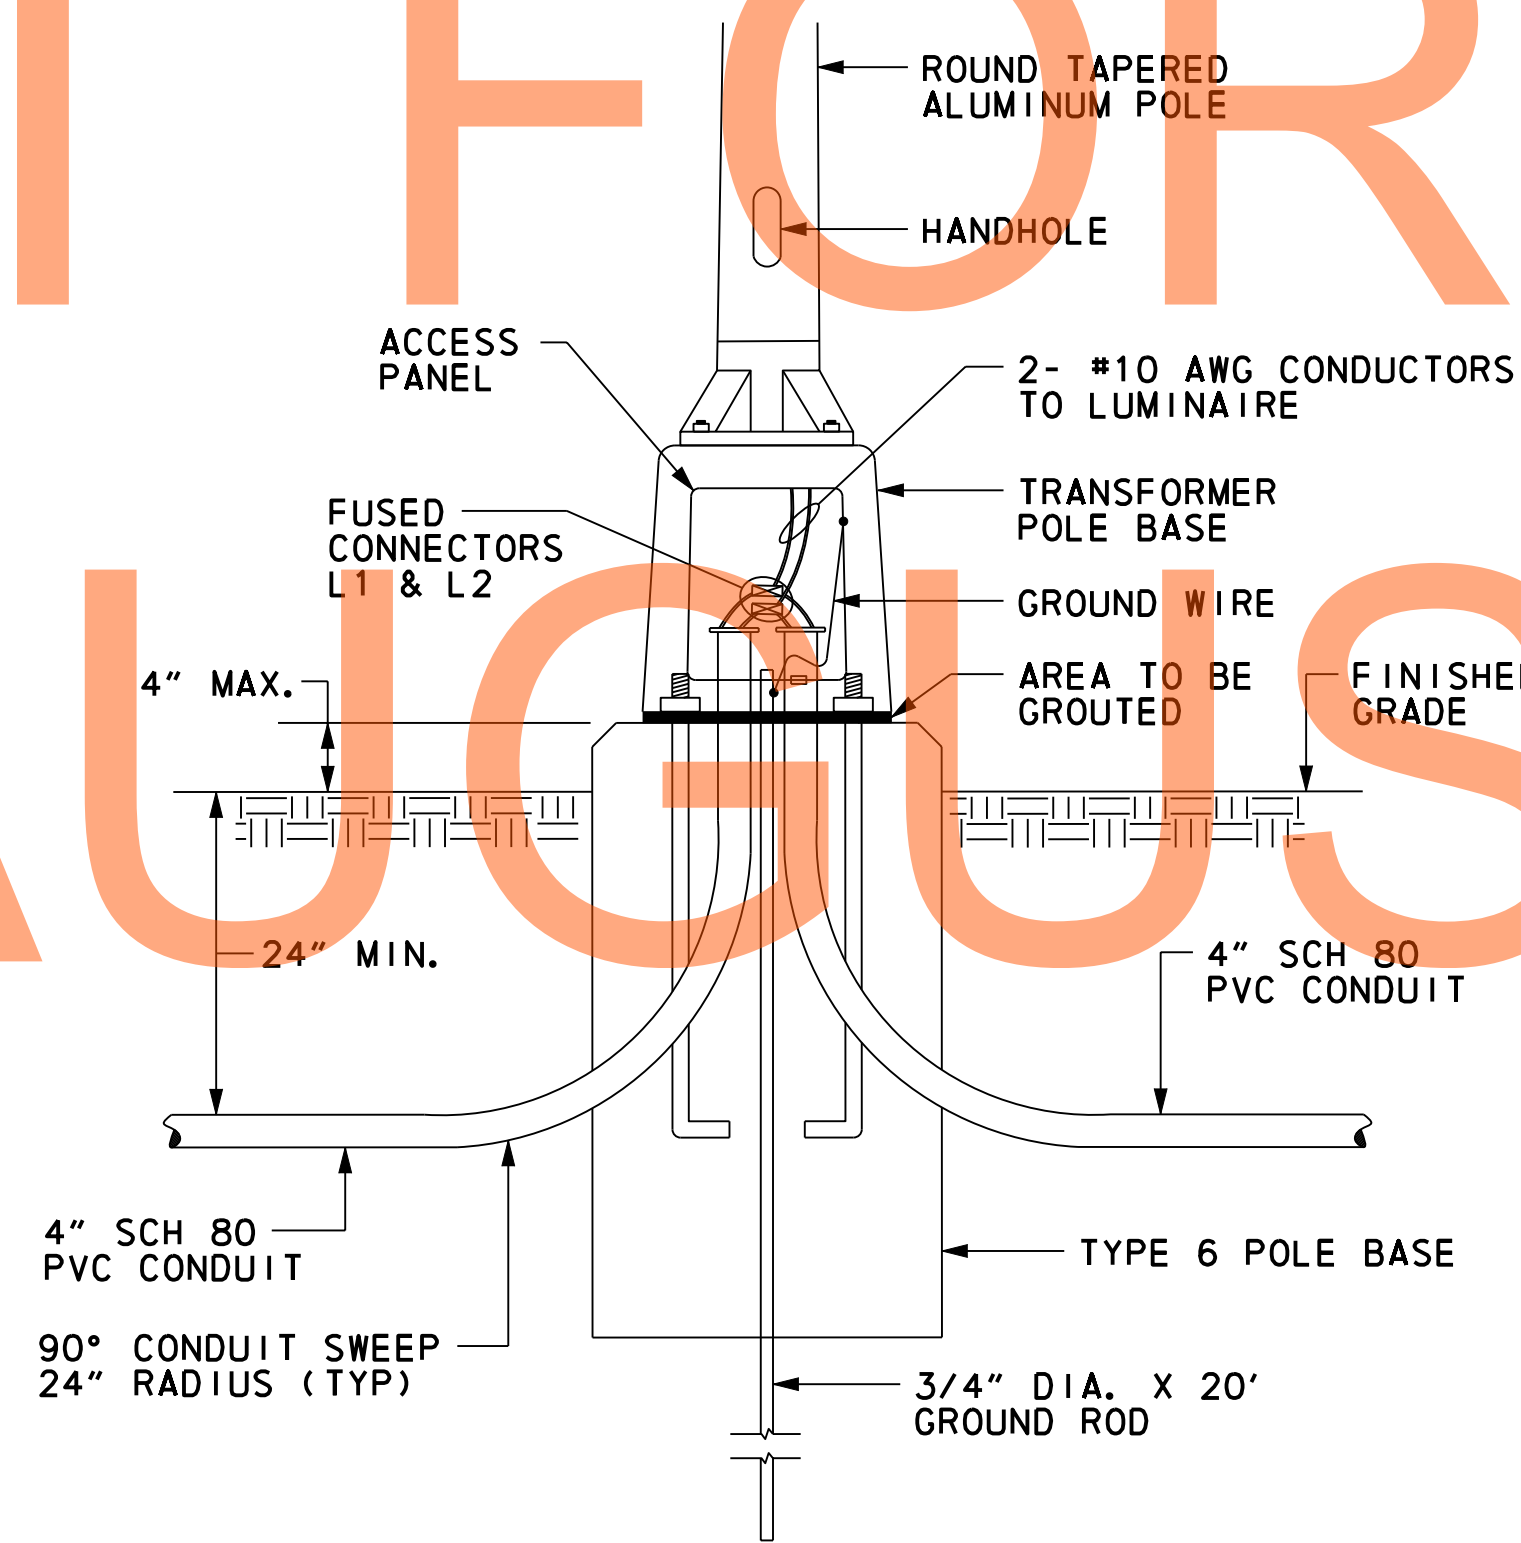

TYPICAL LIGHT POLE FOUNDATION
NOT TO SCALE

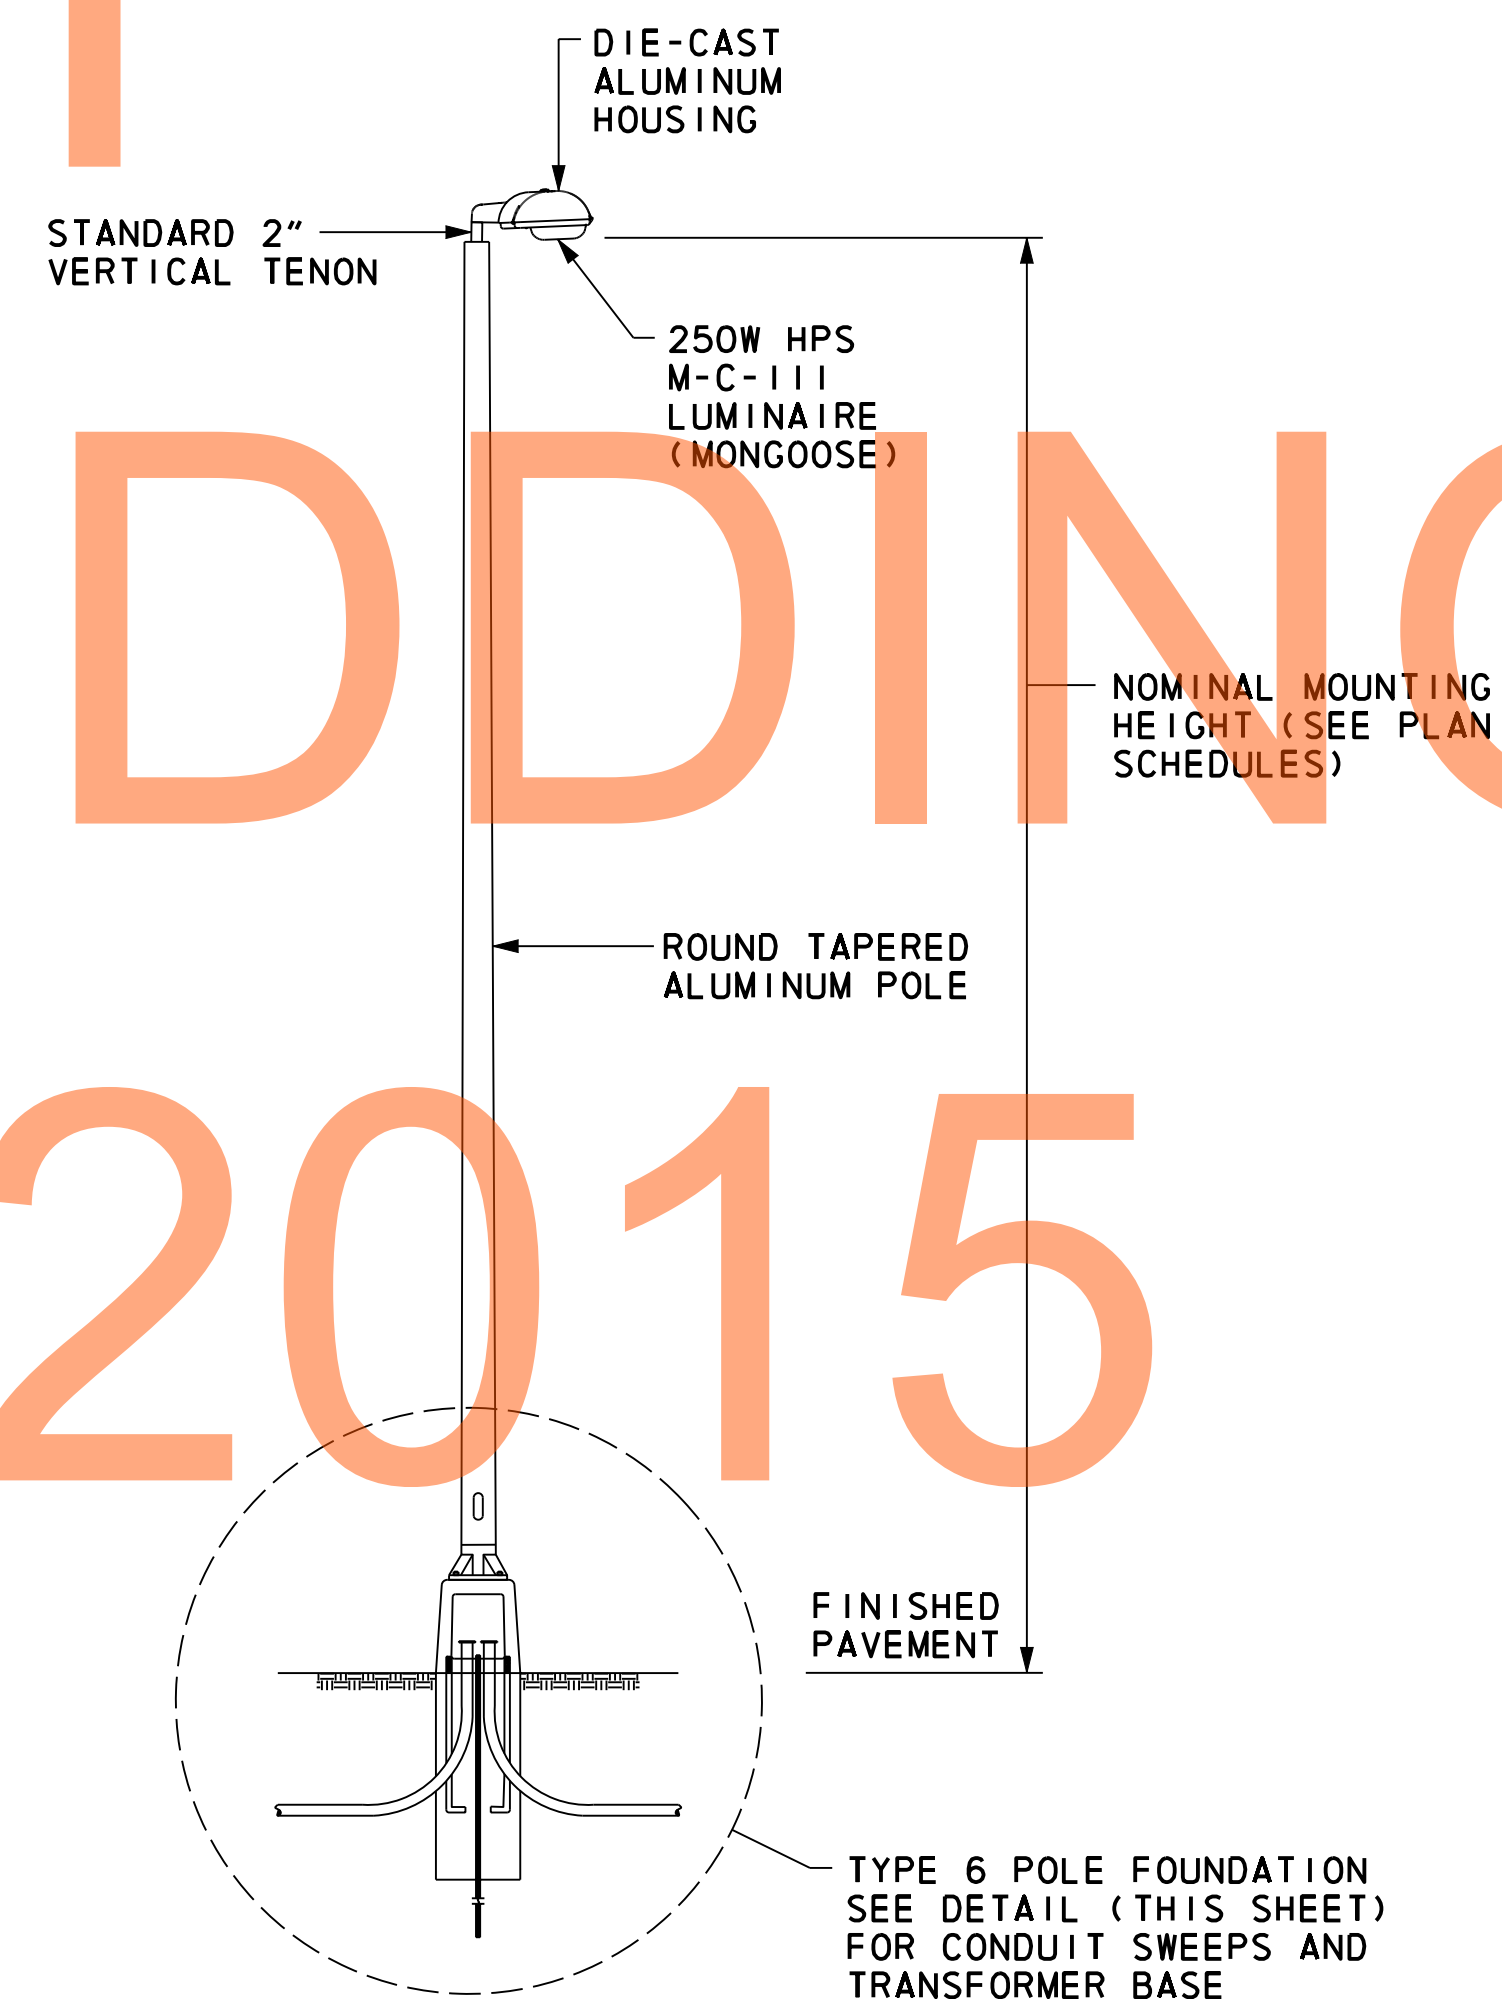

TYPICAL LIGHT STANDARD
NOT TO SCALE

J:\B PROJECTS\34801\700C ADD\702ROAD\LIGHT\LL_301DS3_027.DGN

ADDENDUMS / REVISIONS	

NOT TO SCALE

US 301 MARYLAND STATE LINE TO LEVELS ROAD

CONTRACT	BRIDGE NO.
T200911303	
COUNTY	DESIGNED BY: ML
NEW CASTLE	CHECKED BY: JM


LIGHTING DETAILS	MD-46
	SHEET NO. 1158
	TOTAL SHTS. 1256

PAVEMENT MARKINGS LEGEND		
SYMBOL	ITEM	QUANTITY
(A)	5" PERMANENT PAVEMENT STRIPING, EPOXY RESIN PAINT, WHITE (ITEM 748548)	0 LF
(B)	5" PERMANENT PAVEMENT STRIPING, EPOXY RESIN PAINT, YELLOW (ITEM 748548)	0 LF
(C)	PERMANENT PAVEMENT STRIPING, SYMBOL/LEGEND, ALKYD THERMOPLASTIC, WHITE (ITEM 748015)	0 LF
(D)	13" REFLECTIVE PREFORMED PATTERNED CONTRAST MARKINGS, 3' LINE & 9' GAP (ITEM 748567)	0 LF
(E)	8" REFLECTIVE PREFORMED PATTERNED CONTRAST MARKINGS, 10' LINE & 30' GAP (ITEM 748566)	0 LF
(F)	12" SOLID WHITE RETROFLECTIVE PREFORMED PATTERNED MARKING (TAPE) (ITEM 748513)	0 LF
(G)	3" PERMANENT PAVEMENT STRIPING, EPOXY RESIN PAINT, BLACK (ITEM 748557)	0 LF
(H)	5" PERMANENT PAVEMENT STRIPING, EPOXY RESIN PAINT, WHITE, 10' LINE 30' GAP (ITEM 748548)	0 LF
(I)	RETROFLECTIVE PREFORMED PATTERNED MARKING SYMBOL/LEGEND (ITEM 748529)	0 LF

PAVEMENT MARKINGS LEGEND		
SYMBOL	ITEM	QUANTITY
(J)	10" PERMANENT PAVEMENT STRIPING, EPOXY RESIN PAINT, WHITE, 2' LINE & 6' GAP (ITEM 748548)	0 LF
(K)	10" PERMANENT PAVEMENT STRIPING, EPOXY RESIN PAINT, WHITE (ITEM 748549)	0 LF
(L)	10" PERMANENT PAVEMENT STRIPING, EPOXY RESIN PAINT, WHITE, 2' LINE & 2' GAP (ITEM 748549)	0 LF
(M)	5" PERMANENT PAVEMENT STRIPING, EPOXY RESIN PAINT, WHITE, 2' LINE & 6' GAP (ITEM 748548)	0 LF
(N)	5" PERMANENT PAVEMENT STRIPING, EPOXY RESIN PAINT, DOUBLE YELLOW (ITEM 748548)	0 LF
(O)	12" PERMANENT PAVEMENT STRIPING, EPOXY RESIN PAINT, YELLOW (ITEM 748509)	0 LF
(P)	10" REFLECTIVE PREFORMED PATTERNED CONTRAST MARKINGS, 2' LINE & 6' GAP (ITEM 748565)	0 LF

PAVEMENT MARKINGS LEGEND		
SYMBOL	ITEM	QUANTITY
(R)	5" REFLECTIVE PREFORMED PATTERNED CONTRAST MARKINGS, 2' LINE & 6' GAP (ITEM 748564)	0 LF
(S)	5" PERMANENT PAVEMENT STRIPING, EPOXY RESIN PAINT, YELLOW, 10' LINE 30' GAP (ITEM 748548)	0 LF

SIGNING LEGEND	
①	REMOVE EXISTING SIGN
②	EXISTING SIGN TO REMAIN
③	PLACE NEW SIGN
④	RENEW EXISTING SIGN
⑤	REPOSITION EXISTING SIGN

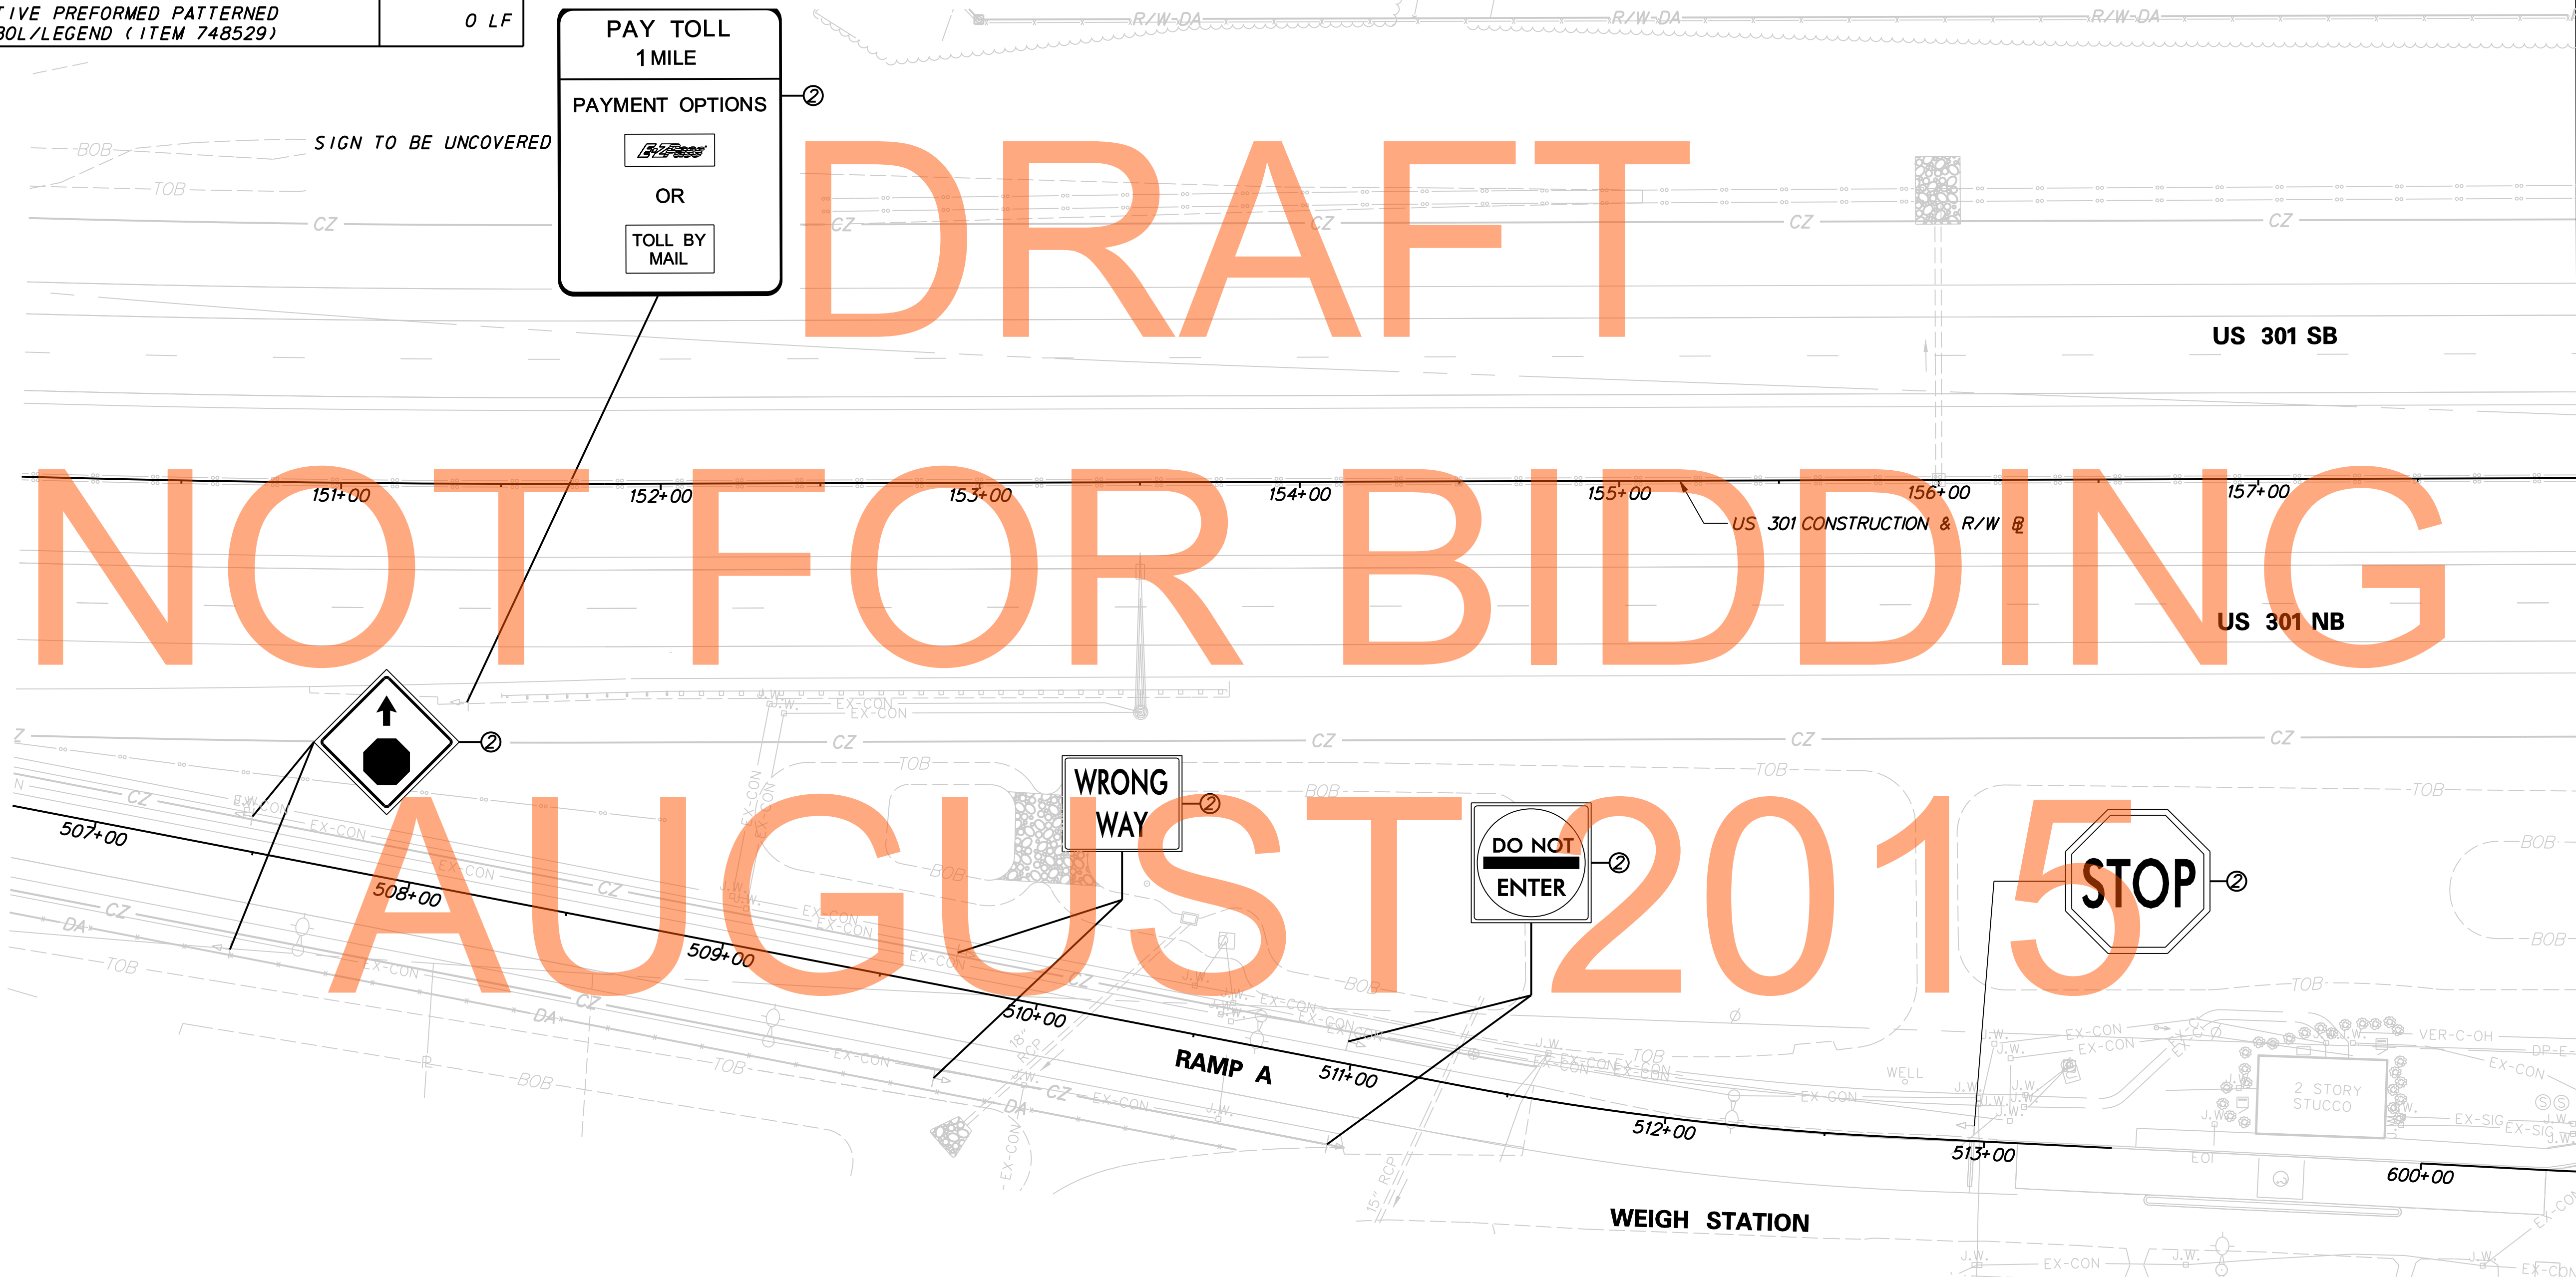


MATCH LINE STA 158+00 SHEET MD-48

J:\2008 PROJECTS\NE3\34801\700CADD\DESIGN SECTION 2 PLANS\MD_301AETDS2_047.DGN

DELAWARE DEPARTMENT OF TRANSPORTATION

ADDENDUMS / REVISIONS

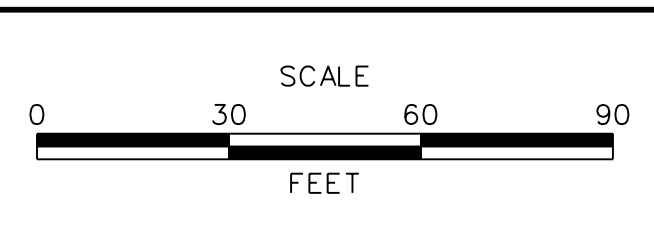

US 301 MARYLAND STATE LINE TO LEVELS ROAD

CONTRACT T200911303	BRIDGE NO.
COUNTY NEW CASTLE	DESIGNED BY: MGP
	CHECKED BY: SKH



SIGNING, STRIPING & CONDUIT PLAN

MD-47
SHEET NO. 1159
TOTAL SHTS. 1256

PAVEMENT MARKINGS LEGEND		
SYMBOL	ITEM	QUANTITY
(A)	5" PERMANENT PAVEMENT STRIPING, EPOXY RESIN PAINT, WHITE (ITEM 748548)	798 LF
(B)	5" PERMANENT PAVEMENT STRIPING, EPOXY RESIN PAINT, YELLOW (ITEM 748548)	800 LF
(C)	PERMANENT PAVEMENT STRIPING, SYMBOL/LEGEND, ALKYD THERMOPLASTIC, WHITE (ITEM 748015)	0 LF
(D)	13" REFLECTIVE PREFORMED PATTERNED CONTRAST MARKINGS, 3' LINE & 9' GAP (ITEM 748567)	0 LF
(E)	8" REFLECTIVE PREFORMED PATTERNED CONTRAST MARKINGS, 10' LINE & 30' GAP (ITEM 748566)	200 LF
(F)	12' SOLID WHITE RETROREFLECTIVE PREFORMED PATTERNED MARKING (TAPE) (ITEM 748513)	0 LF
(G)	3" PERMANENT PAVEMENT STRIPING, EPOXY RESIN PAINT, BLACK (ITEM 748557)	798 LF
(H)	5" PERMANENT PAVEMENT STRIPING, EPOXY RESIN PAINT, WHITE, 10' LINE 30' GAP (ITEM 748548)	0 LF
(I)	RETROREFLECTIVE PREFORMED PATTERNED MARKING SYMBOL/LEGEND (ITEM 748529)	0 LF

PAVEMENT MARKINGS LEGEND		
SYMBOL	ITEM	QUANTITY
(J)	10" PERMANENT PAVEMENT STRIPING, EPOXY RESIN PAINT, WHITE, 2' LINE & 6' GAP (ITEM 748548)	0 LF
(K)	10" PERMANENT PAVEMENT STRIPING, EPOXY RESIN PAINT, WHITE (ITEM 748549)	294 LF
(L)	10" PERMANENT PAVEMENT STRIPING, EPOXY RESIN PAINT, WHITE, 2' LINE & 2' GAP (ITEM 748549)	0 LF
(M)	5" PERMANENT PAVEMENT STRIPING, EPOXY RESIN PAINT, WHITE, 2' LINE & 6' GAP (ITEM 748548)	0 LF
(N)	5" PERMANENT PAVEMENT STRIPING, EPOXY RESIN PAINT, DOUBLE YELLOW (ITEM 748548)	0 LF
(O)	12" PERMANENT PAVEMENT STRIPING, EPOXY RESIN PAINT, YELLOW (ITEM 748509)	0 LF
(P)	10" REFLECTIVE PREFORMED PATTERNED CONTRAST MARKINGS, 2' LINE & 6' GAP (ITEM 748565)	0 LF
(R)	5" REFLECTIVE PREFORMED PATTERNED CONTRAST MARKINGS, 2' LINE & 6' GAP (ITEM 748564)	0 LF
(S)	5" PERMANENT PAVEMENT STRIPING, EPOXY RESIN PAINT, YELLOW, 10' LINE 30' GAP (ITEM 748548)	0 LF

SIGNING LEGEND	
①	REMOVE EXISTING SIGN
②	EXISTING SIGN TO REMAIN
③	PLACE NEW SIGN
④	RENEW EXISTING SIGN
⑤	REPOSITION EXISTING SIGN

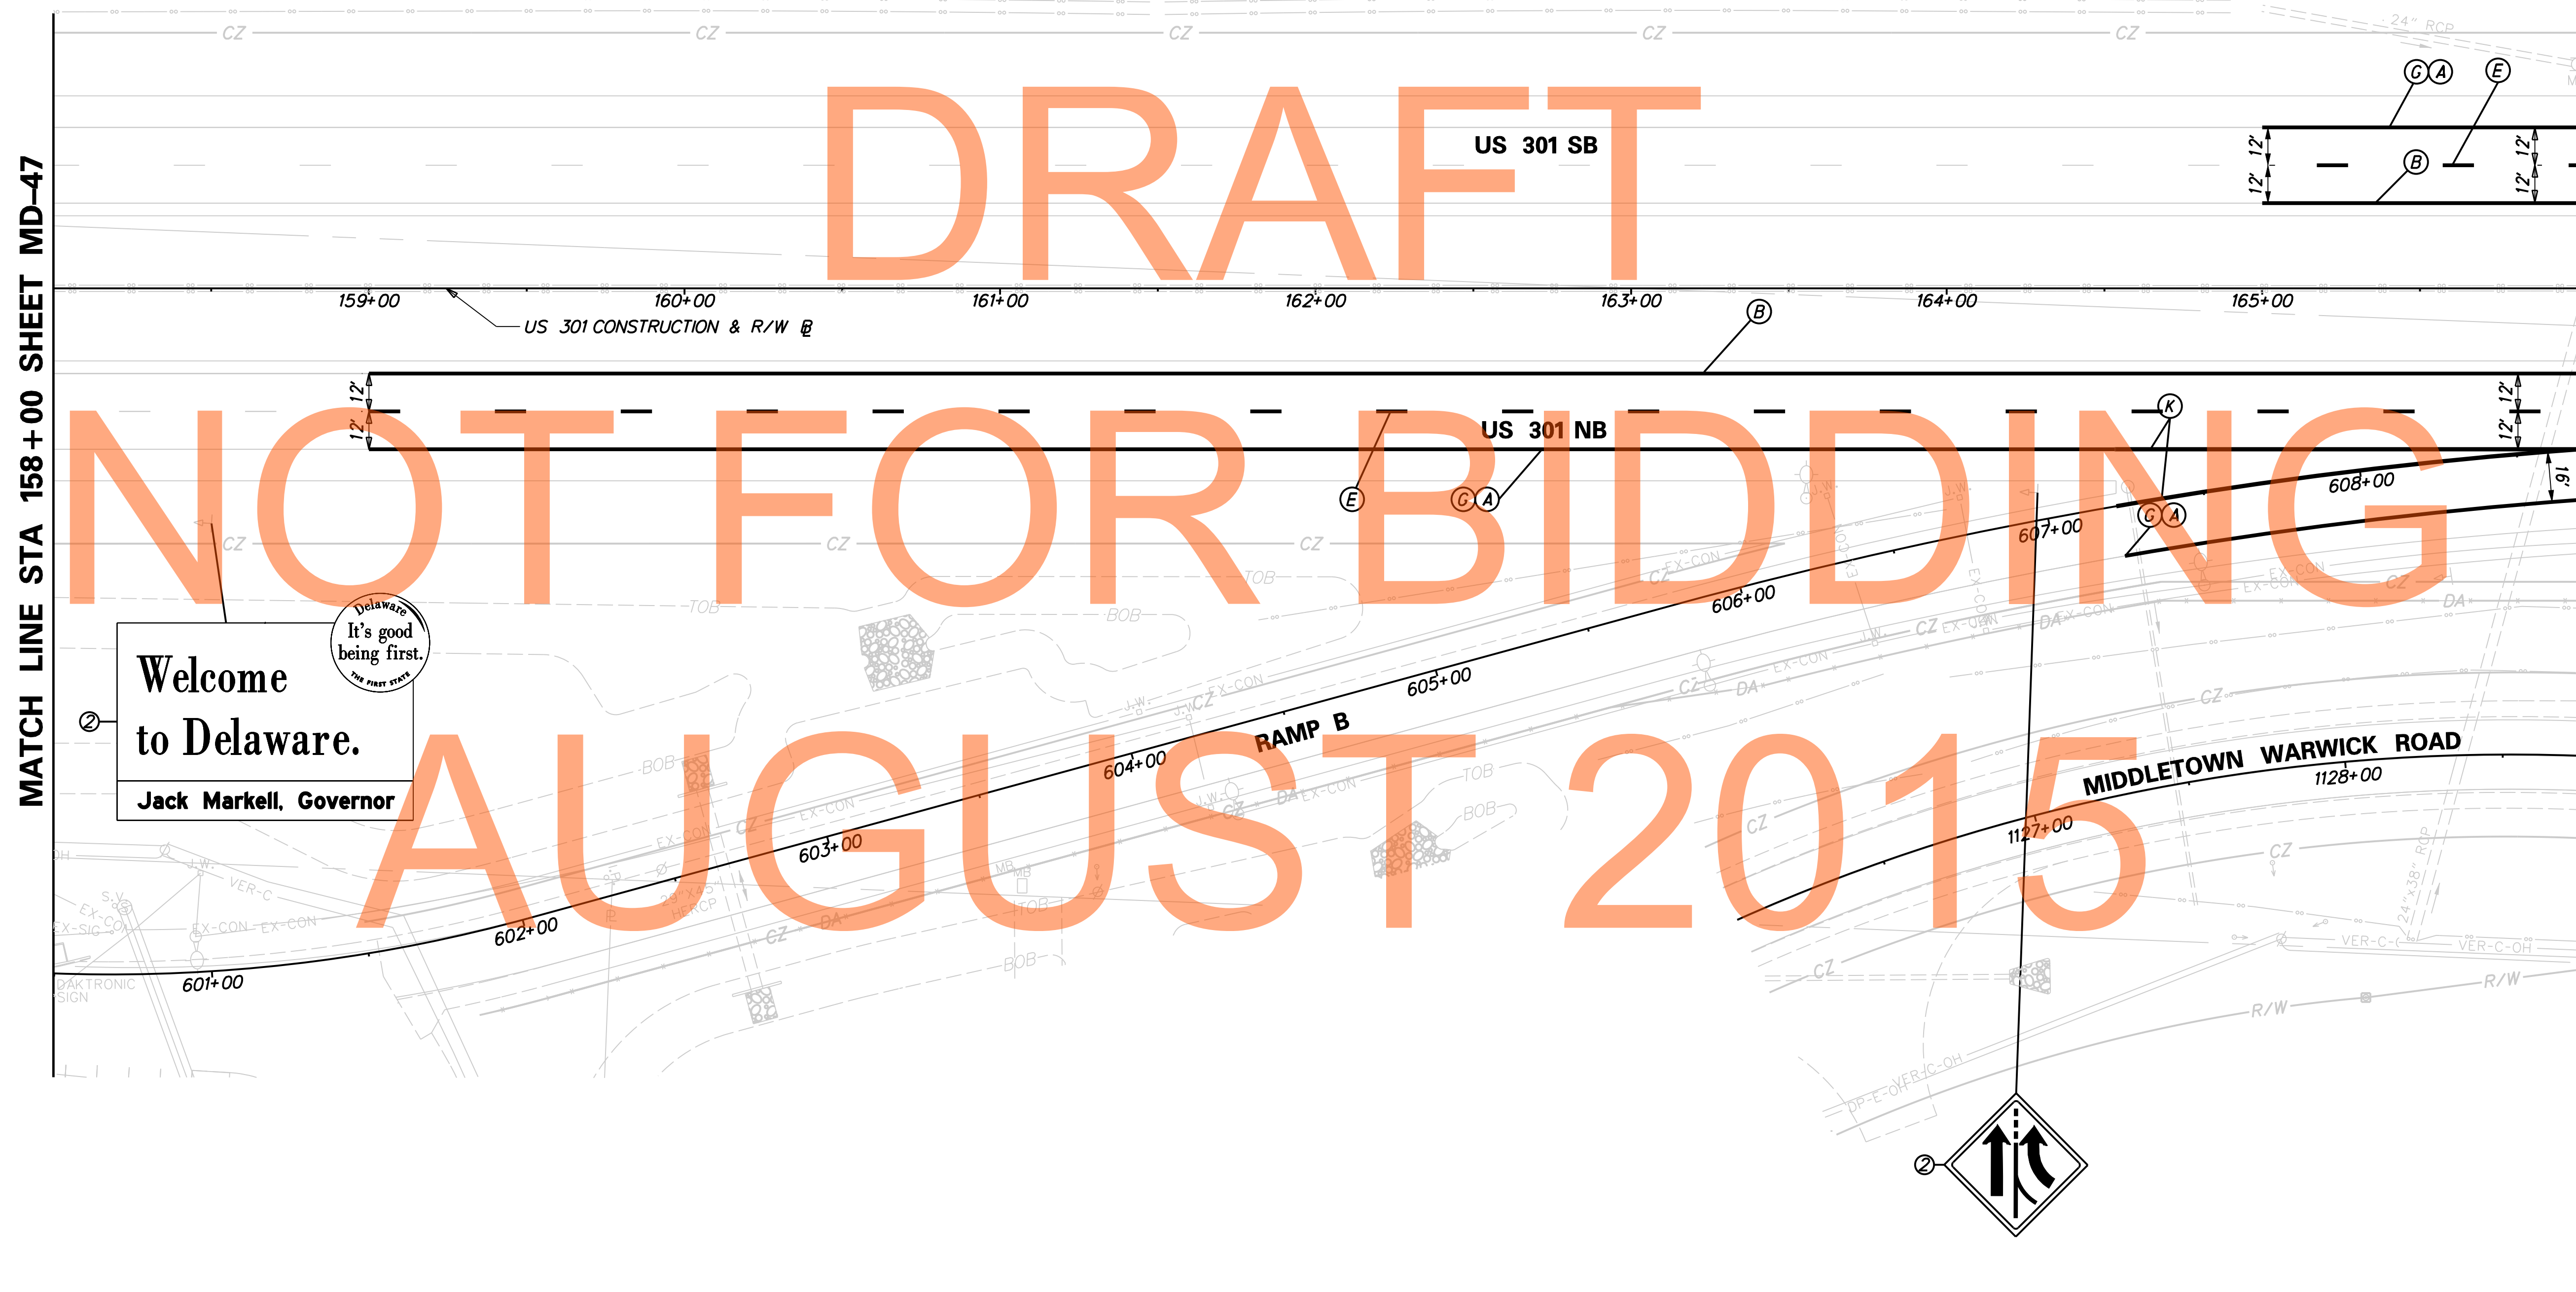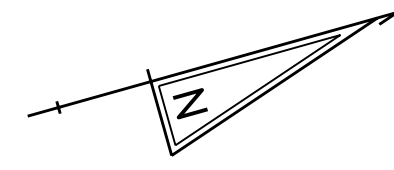

DRAFT

NOT FOR BIDDING

AUGUST 2015

J:\2008 PROJECTS\NE3\4801\700CADD\750AET\DESIGN SECTION 2 PLANS\MD_301AETDS2_048.DGN



DELAWARE DEPARTMENT OF TRANSPORTATION	ADDENDUMS / REVISIONS	SCALE FEET	US 301 MARYLAND STATE LINE TO LEVELS ROAD	CONTRACT T200911303 COUNTY NEW CASTLE	BRIDGE NO. DESIGNED BY: MGP CHECKED BY: SKH	SIGNING, STRIPING & CONDUIT PLAN	MD-48 SHEET NO. 1160 TOTAL SHTS. 1256

PAVEMENT MARKINGS LEGEND		
SYMBOL	ITEM	QUANTITY
(A)	5" PERMANENT PAVEMENT STRIPING, EPOXY RESIN PAINT, WHITE (ITEM 748548)	2660 LF
(B)	5" PERMANENT PAVEMENT STRIPING, EPOXY RESIN PAINT, YELLOW (ITEM 748548)	1600 LF
(C)	PERMANENT PAVEMENT STRIPING, SYMBOL/LEGEND, ALKYD THERMOPLASTIC, WHITE (ITEM 748015)	0 LF
(D)	13" REFLECTIVE PREFORMED PATTERNED CONTRAST MARKINGS, 3' LINE & 9' GAP (ITEM 748567)	175 LF
(E)	8" REFLECTIVE PREFORMED PATTERNED CONTRAST MARKINGS, 10' LINE & 30' GAP (ITEM 748566)	400 LF
(F)	12' SOLID WHITE RETROREFLECTIVE PREFORMED PATTERNED MARKING (TAPE) (ITEM 748513)	0 LF
(G)	3" PERMANENT PAVEMENT STRIPING, EPOXY RESIN PAINT, BLACK (ITEM 748557)	1600 LF
(H)	5" PERMANENT PAVEMENT STRIPING, EPOXY RESIN PAINT, WHITE, 10' LINE 30' GAP (ITEM 748548)	0 LF
(I)	RETROREFLECTIVE PREFORMED PATTERNED MARKING SYMBOL/LEGEND (ITEM 748529)	0 LF

PAVEMENT MARKINGS LEGEND		
SYMBOL	ITEM	QUANTITY
(J)	10" PERMANENT PAVEMENT STRIPING, EPOXY RESIN PAINT, WHITE, 2' LINE & 6' GAP (ITEM 748548)	0 LF
(K)	10" PERMANENT PAVEMENT STRIPING, EPOXY RESIN PAINT, WHITE (ITEM 748549)	100 LF
(L)	10" PERMANENT PAVEMENT STRIPING, EPOXY RESIN PAINT, WHITE, 2' LINE & 2' GAP (ITEM 748549)	0 LF
(M)	5" PERMANENT PAVEMENT STRIPING, EPOXY RESIN PAINT, WHITE, 2' LINE & 6' GAP (ITEM 748548)	0 LF
(N)	5" PERMANENT PAVEMENT STRIPING, EPOXY RESIN PAINT, DOUBLE YELLOW (ITEM 748548)	1060 LF
(O)	12" PERMANENT PAVEMENT STRIPING, EPOXY RESIN PAINT, YELLOW (ITEM 748509)	0 LF
(P)	10" REFLECTIVE PREFORMED PATTERNED CONTRAST MARKINGS, 2' LINE & 6' GAP (ITEM 748565)	0 LF
(R)	5" REFLECTIVE PREFORMED PATTERNED CONTRAST MARKINGS, 2' LINE & 6' GAP (ITEM 748564)	0 LF
(S)	5" PERMANENT PAVEMENT STRIPING, EPOXY RESIN PAINT, YELLOW, 10' LINE 30' GAP (ITEM 748548)	0 LF

SIGNING LEGEND	
①	REMOVE EXISTING SIGN
②	EXISTING SIGN TO REMAIN
③	PLACE NEW SIGN
④	RENEW EXISTING SIGN
⑤	REPOSITION EXISTING SIGN

CONDUIT SCHEDULE				
NO.	DISTANCE (L. F.)	DESCRIPTION	INSTALLATION	REMARKS
1	575	4" SCH80 PVC	TRENCH	COMM CABLE

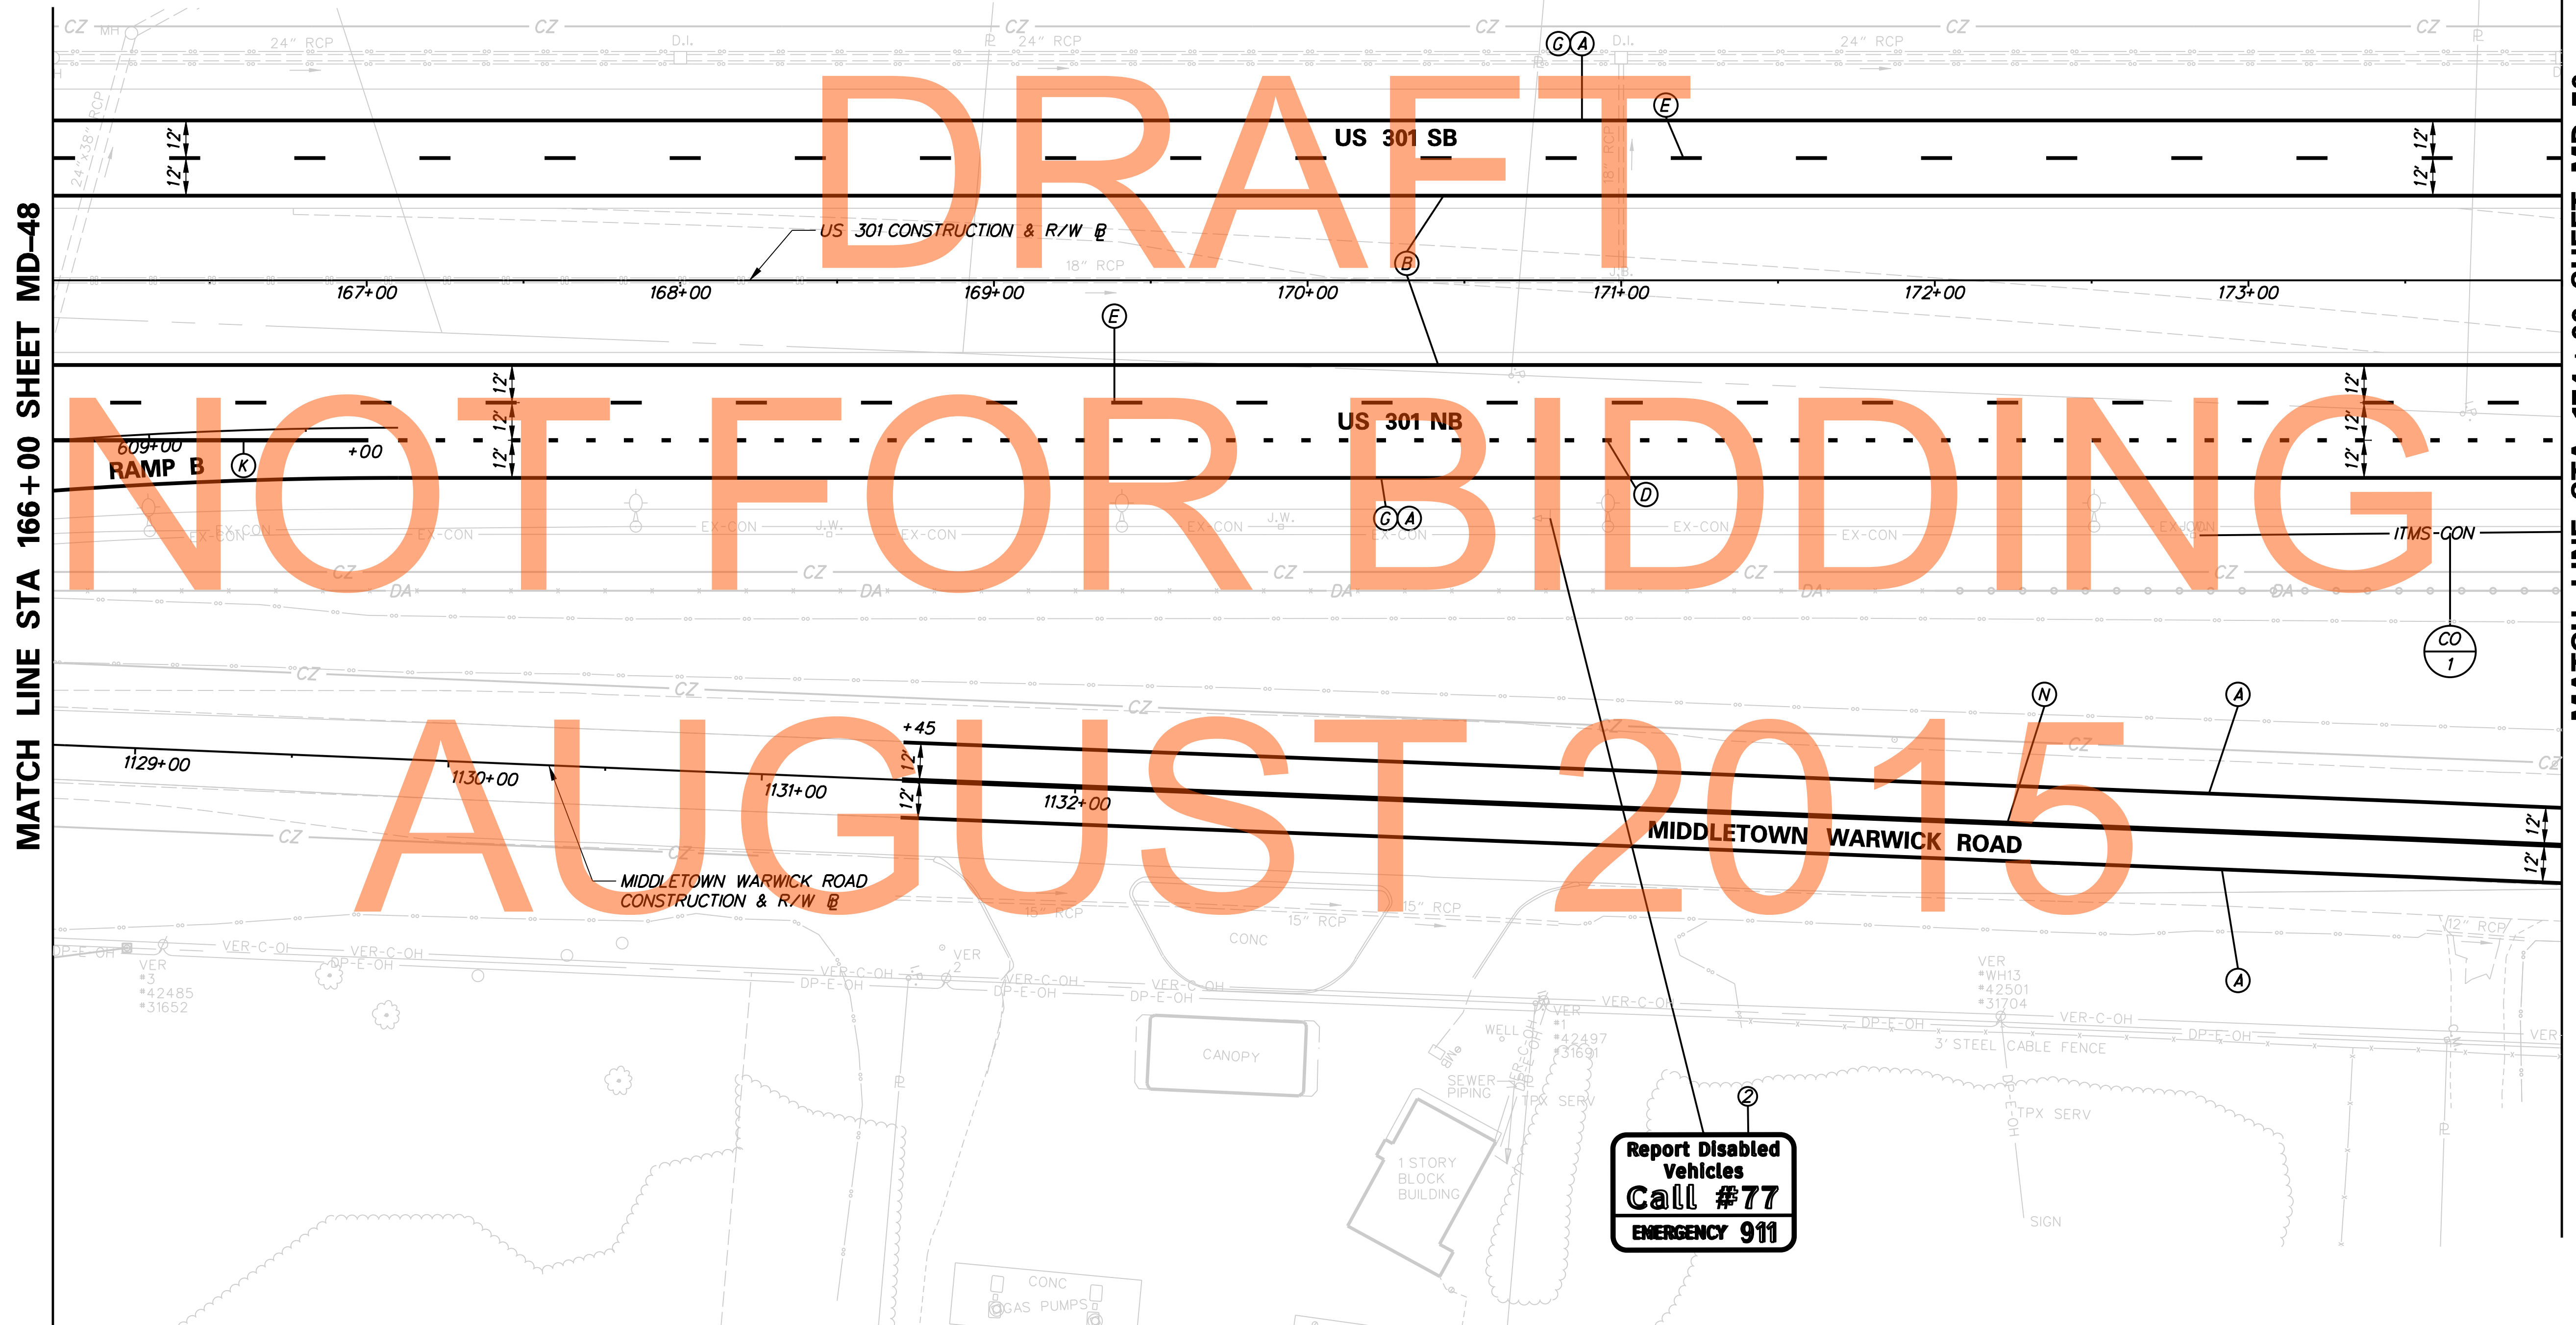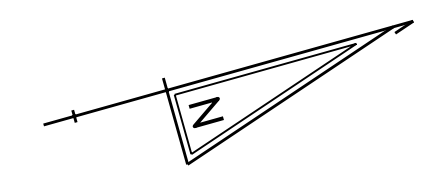

MATCH LINE STA 166+00 SHEET MD-48

MATCH LINE STA 174+00 SHEET MD-50

Report Disabled Vehicles
Call #77
EMERGENCY 911

J:\2008 PROJECTS\NE3\3480\700CADD\702ROAD\DESIGN SECTION 2 PLANS\MD_301DS2_049.DGN


	DELAWARE DEPARTMENT OF TRANSPORTATION	ADDENDUMS / REVISIONS <table border="1"> <tr><td> </td><td> </td></tr> <tr><td> </td><td> </td></tr> <tr><td> </td><td> </td></tr> </table>							SCALE 0 30 60 90 FEET	US 301 MARYLAND STATE LINE TO LEVELS ROAD	CONTRACT T200911303	BRIDGE NO. 	SIGNING, STRIPING & CONDUIT PLAN	MD-49
COUNTY NEW CASTLE	DESIGNED BY: MGP CHECKED BY: SKH	SHEET NO. 1161												
							TOTAL SHTS. 1256							

PAVEMENT MARKINGS LEGEND		
SYMBOL	ITEM	QUANTITY
(A)	5" PERMANENT PAVEMENT STRIPING, EPOXY RESIN PAINT, WHITE (ITEM 748548)	2402 LF
(B)	5" PERMANENT PAVEMENT STRIPING, EPOXY RESIN PAINT, YELLOW (ITEM 748548)	800 LF
(C)	PERMANENT PAVEMENT STRIPING, SYMBOL/LEGEND, ALKYD THERMOPLASTIC, WHITE (ITEM 748015)	0 LF
(D)	13" REFLECTIVE PREFORMED PATTERNED CONTRAST MARKINGS, 3' LINE & 9' GAP (ITEM 748567)	24 LF
(E)	8" REFLECTIVE PREFORMED PATTERNED CONTRAST MARKINGS, 10' LINE & 30' GAP (ITEM 748566)	200 LF
(F)	12' SOLID WHITE RETROREFLECTIVE PREFORMED PATTERNED MARKING (TAPE) (ITEM 748513)	0 LF
(G)	3" PERMANENT PAVEMENT STRIPING, EPOXY RESIN PAINT, BLACK (ITEM 748557)	800 LF
(H)	5" PERMANENT PAVEMENT STRIPING, EPOXY RESIN PAINT, WHITE, 10' LINE 30' GAP (ITEM 748548)	0 LF
(I)	RETROREFLECTIVE PREFORMED PATTERNED MARKING SYMBOL/LEGEND (ITEM 748529)	0 LF

PAVEMENT MARKINGS LEGEND		
SYMBOL	ITEM	QUANTITY
(J)	10" PERMANENT PAVEMENT STRIPING, EPOXY RESIN PAINT, WHITE, 2' LINE & 6' GAP (ITEM 748548)	0 LF
(K)	10" PERMANENT PAVEMENT STRIPING, EPOXY RESIN PAINT, WHITE (ITEM 748549)	0 LF
(L)	10" PERMANENT PAVEMENT STRIPING, EPOXY RESIN PAINT, WHITE, 2' LINE & 2' GAP (ITEM 748549)	0 LF
(M)	5" PERMANENT PAVEMENT STRIPING, EPOXY RESIN PAINT, WHITE, 2' LINE & 6' GAP (ITEM 748548)	0 LF

PAVEMENT MARKINGS LEGEND		
SYMBOL	ITEM	QUANTITY
(N)	5" PERMANENT PAVEMENT STRIPING, EPOXY RESIN PAINT, DOUBLE YELLOW (ITEM 748548)	1601 LF
(O)	12" PERMANENT PAVEMENT STRIPING, EPOXY RESIN PAINT, YELLOW (ITEM 748509)	0 LF
(P)	10" REFLECTIVE PREFORMED PATTERNED CONTRAST MARKINGS, 2' LINE & 6' GAP (ITEM 748565)	0 LF
(R)	5" REFLECTIVE PREFORMED PATTERNED CONTRAST MARKINGS, 2' LINE & 6' GAP (ITEM 748564)	0 LF
(S)	5" PERMANENT PAVEMENT STRIPING, EPOXY RESIN PAINT, YELLOW, 10' LINE 30' GAP (ITEM 748548)	0 LF

SIGNING LEGEND	
①	REMOVE EXISTING SIGN
②	EXISTING SIGN TO REMAIN
③	PLACE NEW SIGN
④	RENEW EXISTING SIGN
⑤	REPOSITION EXISTING SIGN

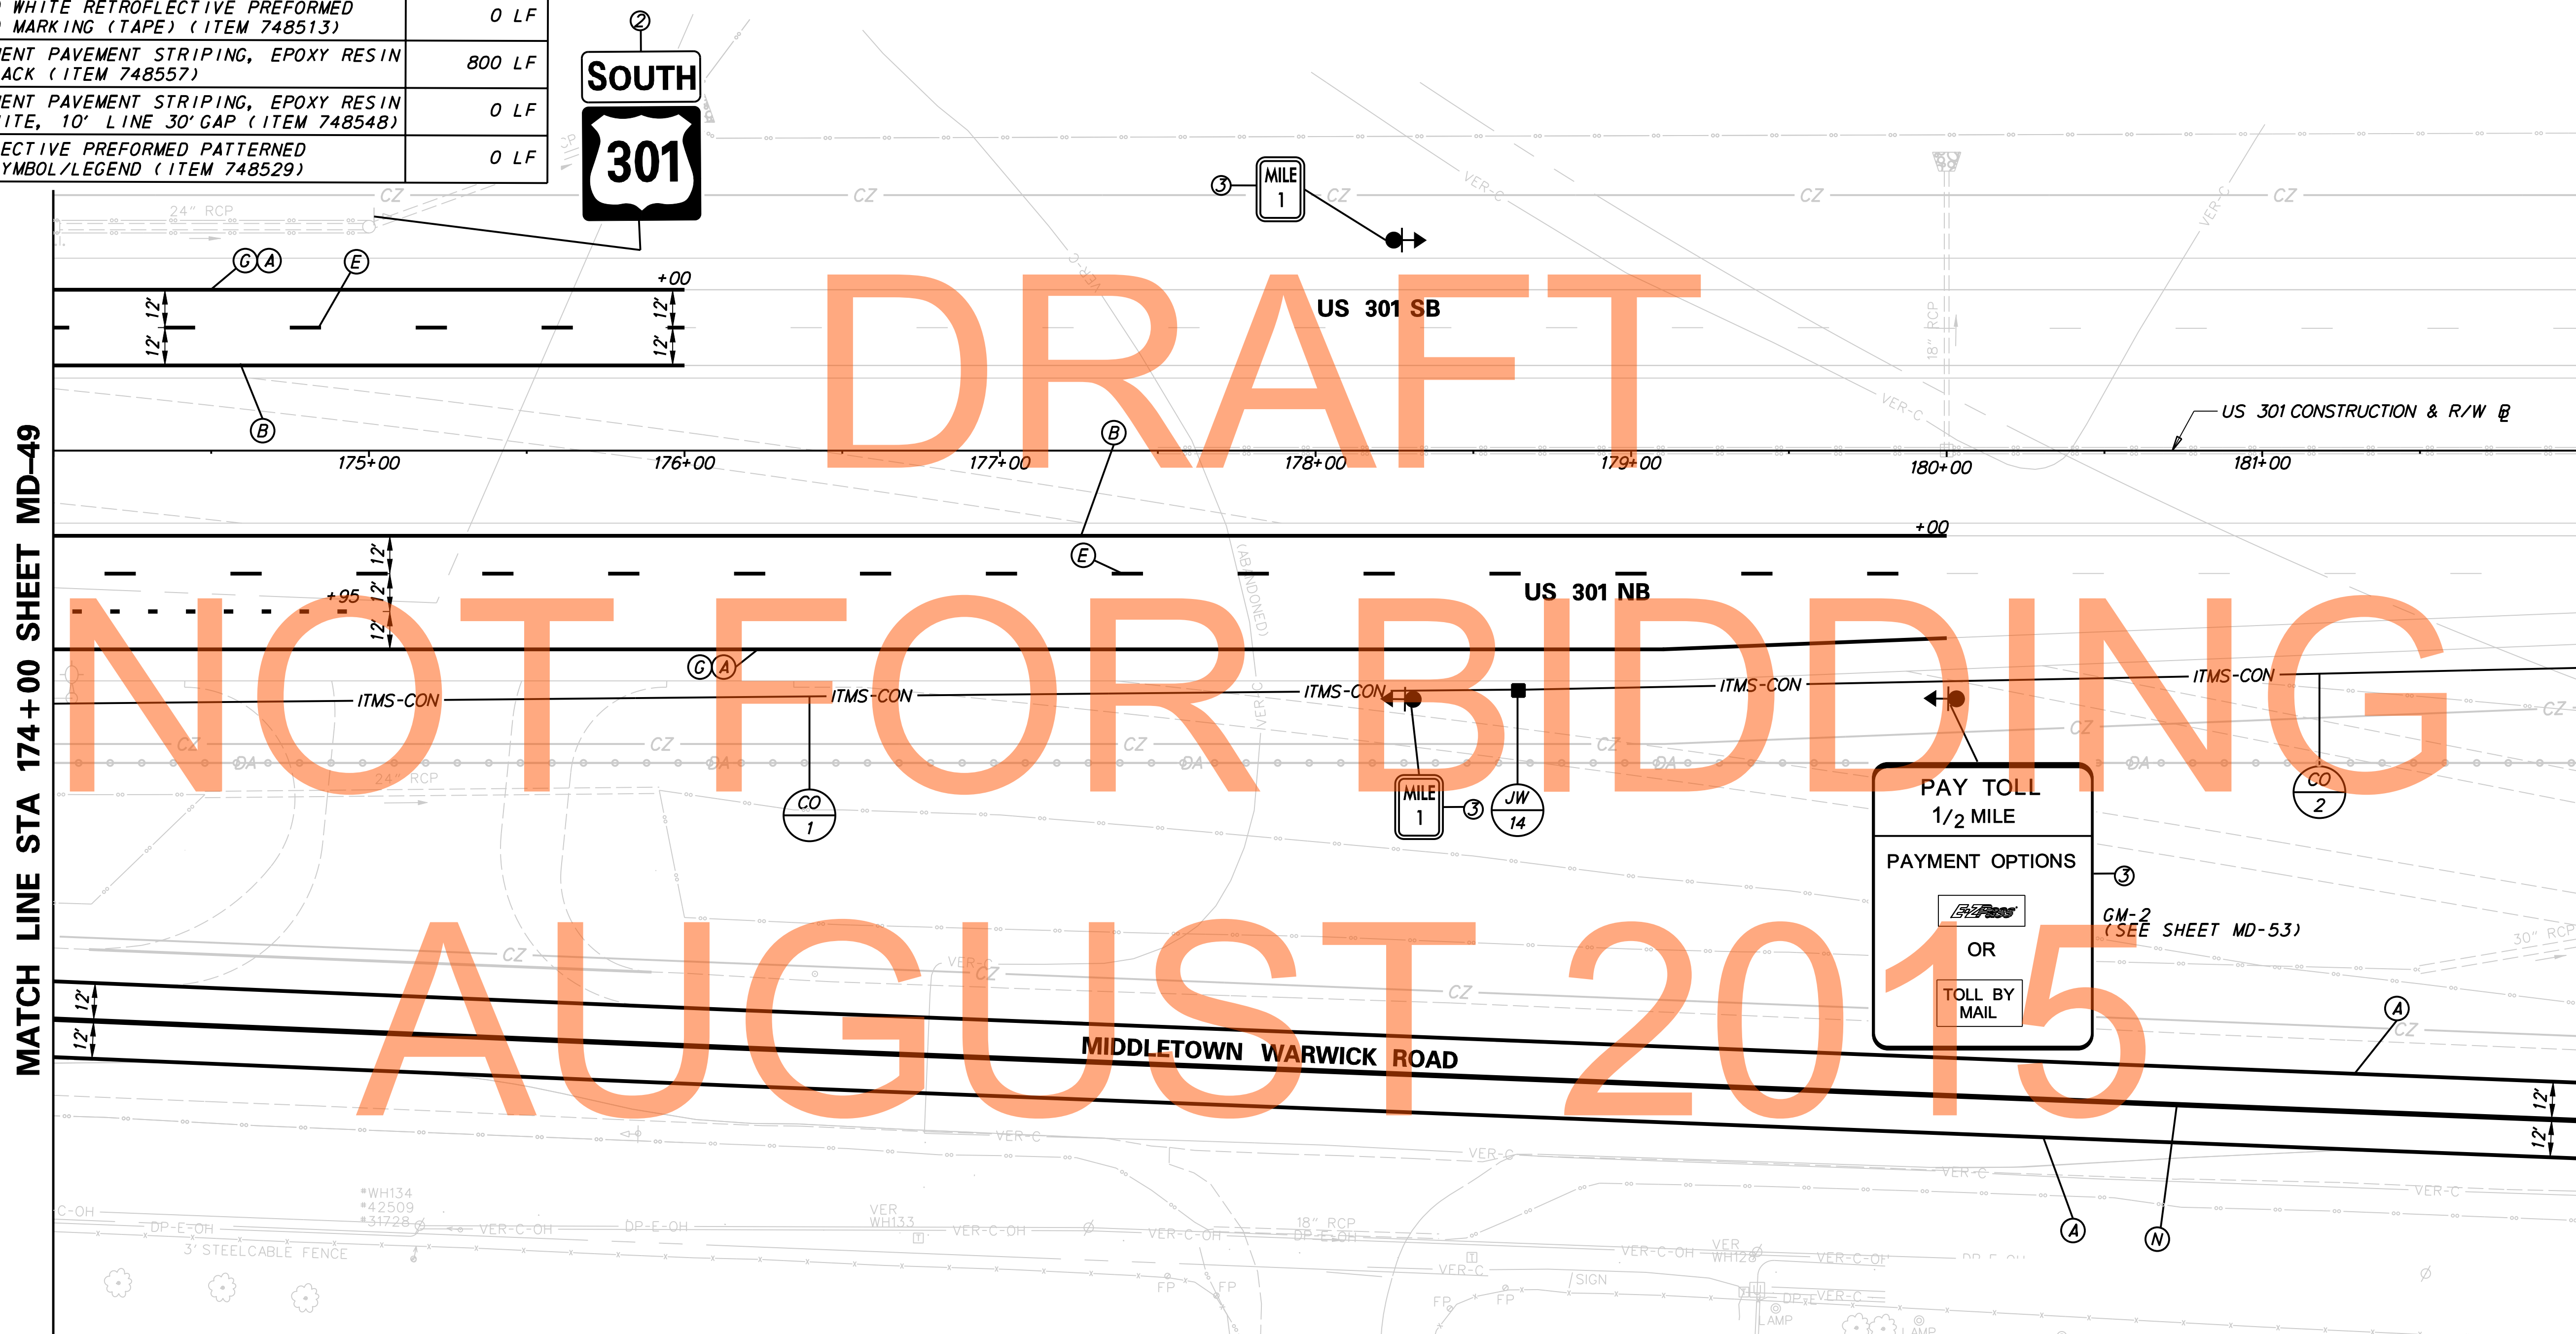

CONDUIT SCHEDULE				
NO.	DISTANCE (L.F.)	DESCRIPTION	INSTALLATION	REMARKS
2	500	4" SCH80 PVC	TRENCH	COMM CABLE

DRAFT


NOT FOR BIDDING

AUGUST 2015

J:\2008 PROJECTS\NE3\4801\700CADD\702ROAD\DESIGN SECTION 2 PLANS\MD_301DS2_050.DGN



ADDENDUMS / REVISIONS	

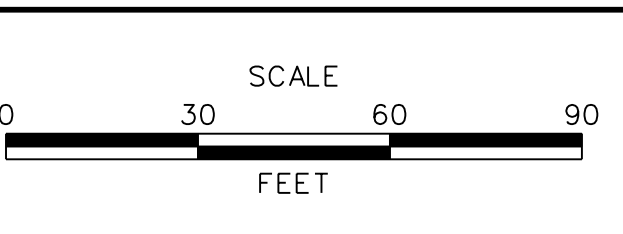

**US 301
MARYLAND STATE LINE
TO LEVELS ROAD**

CONTRACT T200911303	BRIDGE NO.
COUNTY NEW CASTLE	DESIGNED BY: MGP
	CHECKED BY: SKH

**SIGNING, STRIPING &
CONDUIT PLAN**



MD-50
SHEET NO. 1162
TOTAL SHTS. 1256

PAVEMENT MARKINGS LEGEND		
SYMBOL	ITEM	QUANTITY
(A)	5" PERMANENT PAVEMENT STRIPING, EPOXY RESIN PAINT, WHITE (ITEM 748548)	1601 LF
(B)	5" PERMANENT PAVEMENT STRIPING, EPOXY RESIN PAINT, YELLOW (ITEM 748548)	0 LF
(C)	PERMANENT PAVEMENT STRIPING, SYMBOL/LEGEND, ALKYD THERMOPLASTIC, WHITE (ITEM 748015)	0 LF
(D)	13" REFLECTIVE PREFORMED PATTERNED CONTRAST MARKINGS, 3' LINE & 9' GAP (ITEM 748567)	0 LF
(E)	8" REFLECTIVE PREFORMED PATTERNED CONTRAST MARKINGS, 10' LINE & 30' GAP (ITEM 748566)	0 LF
(F)	12" SOLID WHITE RETROFLECTIVE PREFORMED PATTERNED MARKING (TAPE) (ITEM 748513)	0 LF
(G)	3" PERMANENT PAVEMENT STRIPING, EPOXY RESIN PAINT, BLACK (ITEM 748557)	0 LF
(H)	5" PERMANENT PAVEMENT STRIPING, EPOXY RESIN PAINT, WHITE, 10' LINE 30' GAP (ITEM 748548)	0 LF
(I)	RETROFLECTIVE PREFORMED PATTERNED MARKING SYMBOL/LEGEND (ITEM 748529)	0 LF

PAVEMENT MARKINGS LEGEND		
SYMBOL	ITEM	QUANTITY
(J)	10" PERMANENT PAVEMENT STRIPING, EPOXY RESIN PAINT, WHITE, 2' LINE & 6' GAP (ITEM 748548)	0 LF
(K)	10" PERMANENT PAVEMENT STRIPING, EPOXY RESIN PAINT, WHITE (ITEM 748549)	0 LF
(L)	10" PERMANENT PAVEMENT STRIPING, EPOXY RESIN PAINT, WHITE, 2' LINE & 2' GAP (ITEM 748549)	0 LF
(M)	5" PERMANENT PAVEMENT STRIPING, EPOXY RESIN PAINT, WHITE, 2' LINE & 6' GAP (ITEM 748548)	0 LF
(N)	5" PERMANENT PAVEMENT STRIPING, EPOXY RESIN PAINT, DOUBLE YELLOW (ITEM 748548)	151 LF
(O)	12" PERMANENT PAVEMENT STRIPING, EPOXY RESIN PAINT, YELLOW (ITEM 748509)	0 LF

PAVEMENT MARKINGS LEGEND		
SYMBOL	ITEM	QUANTITY
(P)	10" REFLECTIVE PREFORMED PATTERNED CONTRAST MARKINGS, 2' LINE & 6' GAP (ITEM 748565)	0 LF
(R)	5" REFLECTIVE PREFORMED PATTERNED CONTRAST MARKINGS, 2' LINE & 6' GAP (ITEM 748564)	0 LF
(S)	5" PERMANENT PAVEMENT STRIPING, EPOXY RESIN PAINT, YELLOW, 10' LINE 30' GAP (ITEM 748548)	181 LF

SIGNING LEGEND	
①	REMOVE EXISTING SIGN
②	EXISTING SIGN TO REMAIN
③	PLACE NEW SIGN
④	RENEW EXISTING SIGN
⑤	REPOSITION EXISTING SIGN

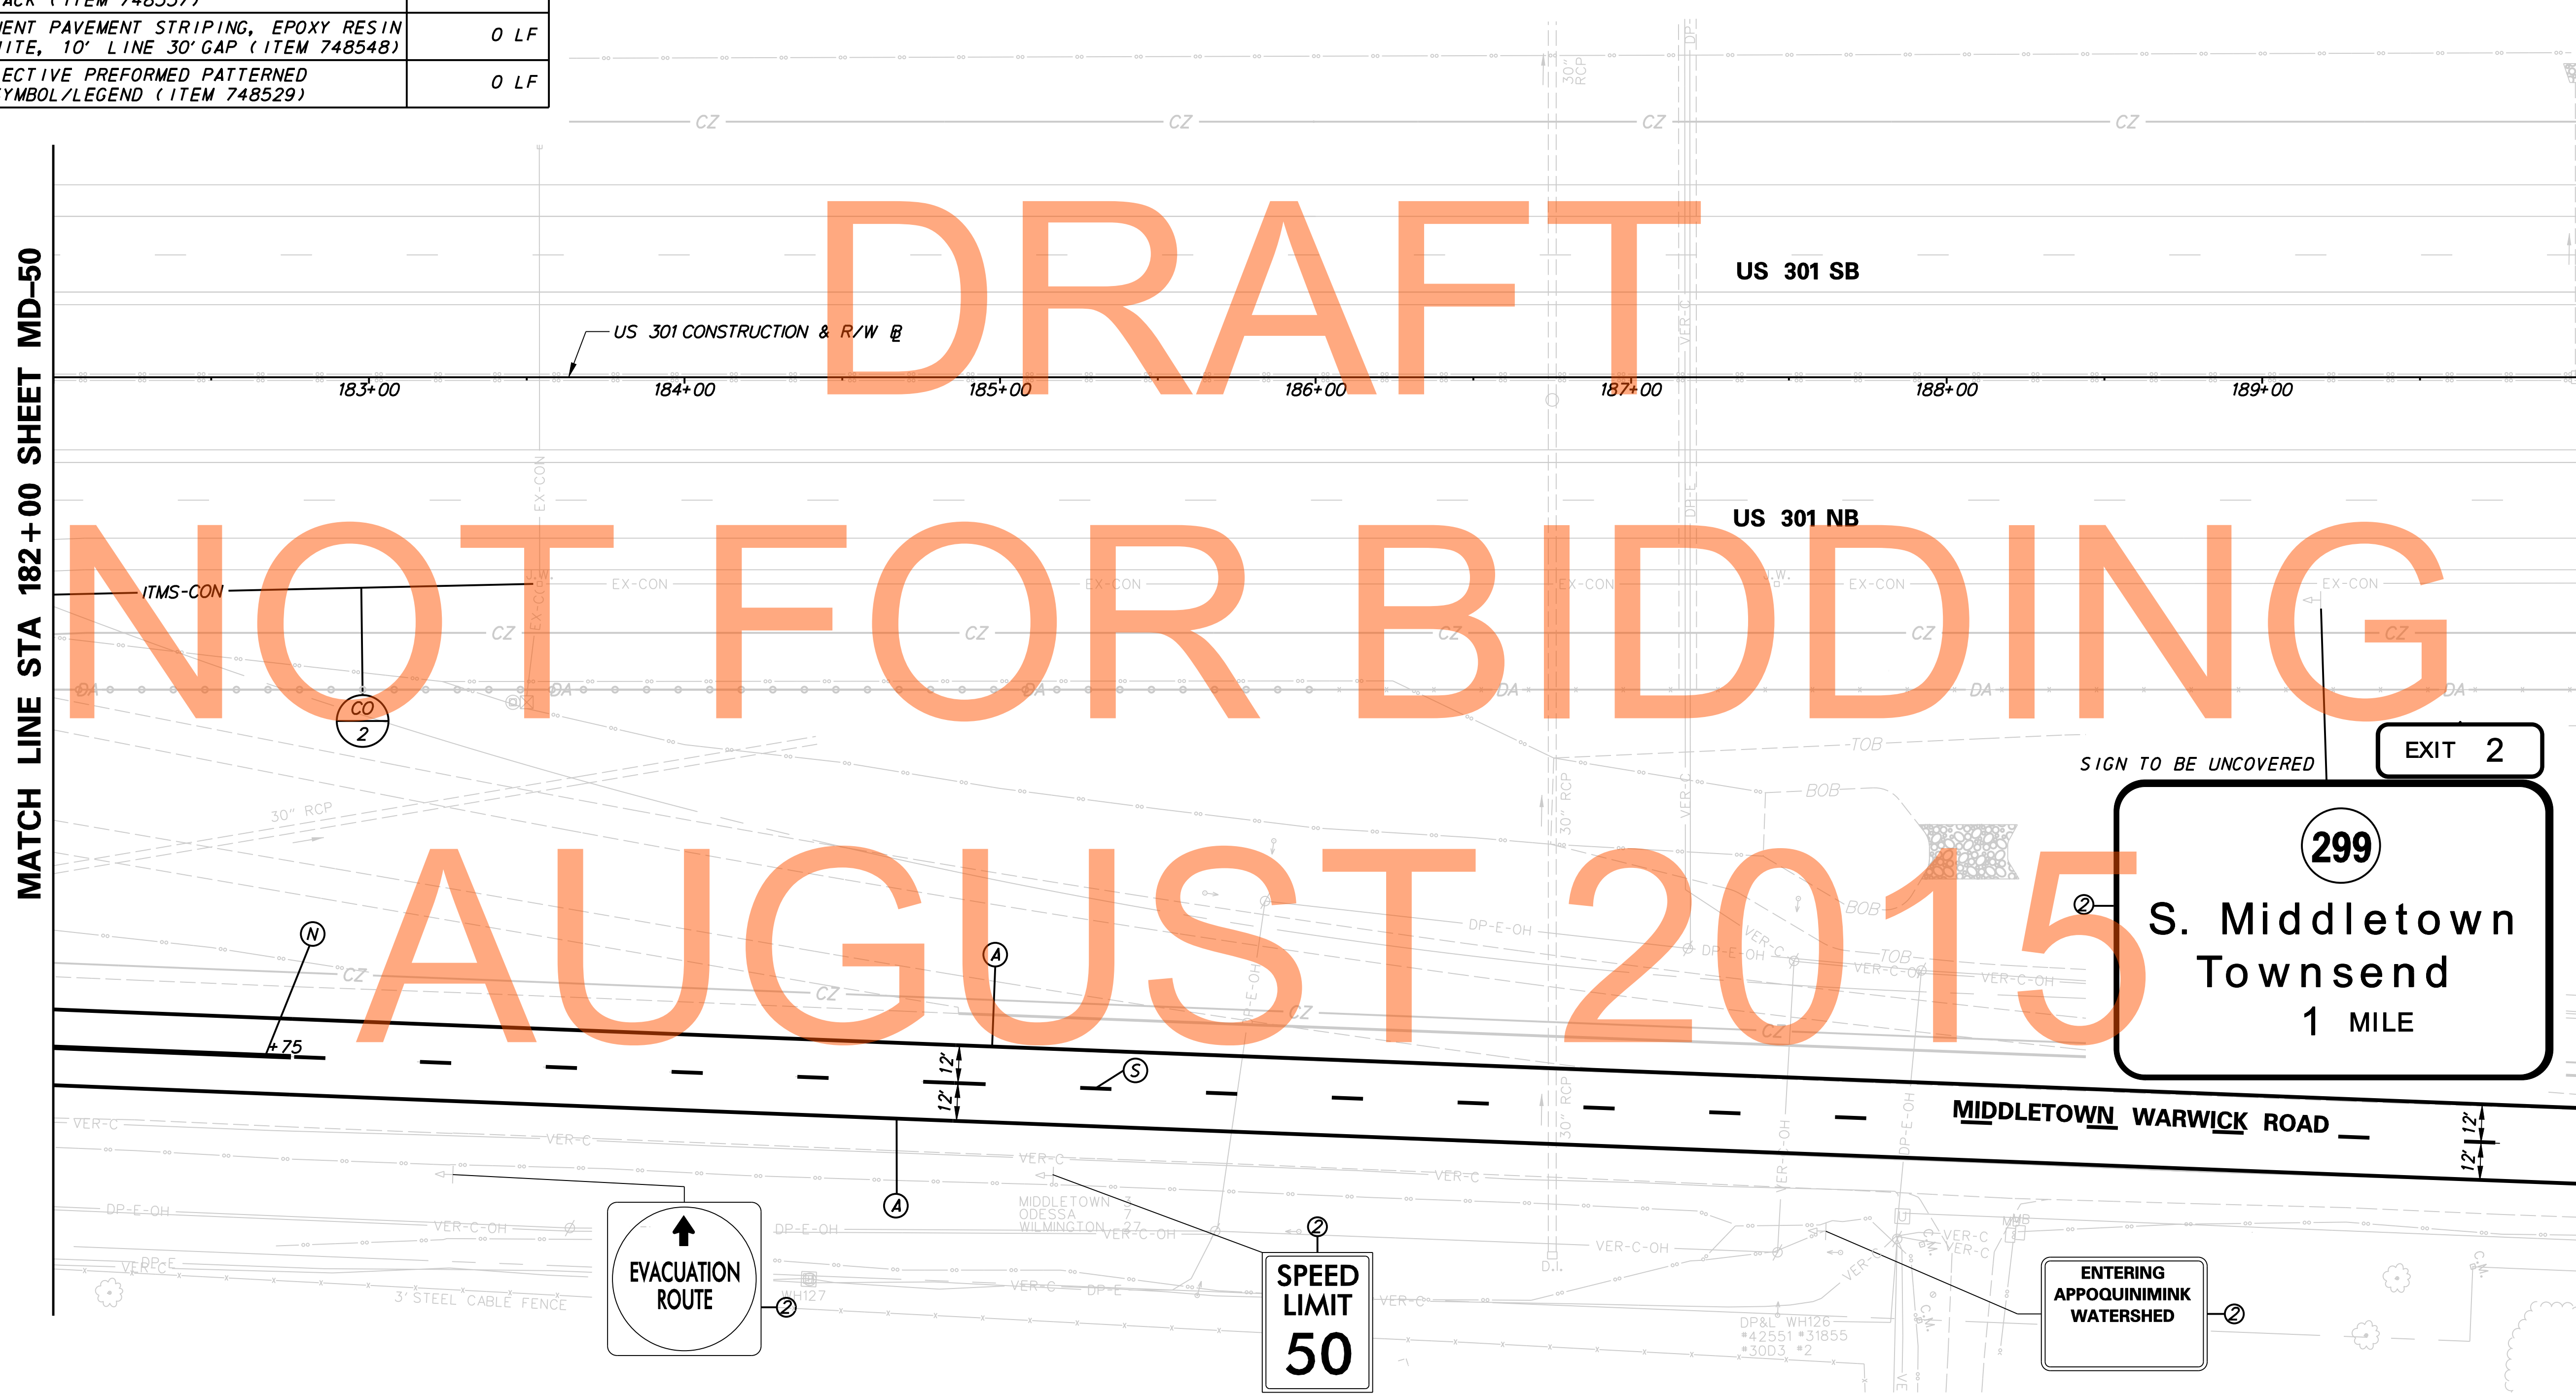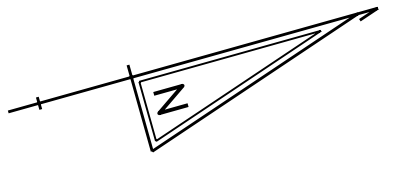

J:\2008 PROJECTS\NE3\3480\700CADD\702ROAD\DESIGN SECTION 2 PLANS\MD_301DS2_051.DGN


	DELAWARE DEPARTMENT OF TRANSPORTATION	ADDENDUMS / REVISIONS	SCALE 	US 301 MARYLAND STATE LINE TO LEVELS ROAD	CONTRACT T200911303 COUNTY NEW CASTLE	BRIDGE NO. DESIGNED BY: MGP CHECKED BY: SKH	SIGNING, STRIPING & CONDUIT PLAN	MD-51 SHEET NO. 1163 TOTAL SHTS. 1256

PAVEMENT MARKINGS LEGEND		
SYMBOL	ITEM	QUANTITY
(A)	5" PERMANENT PAVEMENT STRIPING, EPOXY RESIN PAINT, WHITE (ITEM 748548)	712 LF
(B)	5" PERMANENT PAVEMENT STRIPING, EPOXY RESIN PAINT, YELLOW (ITEM 748548)	0 LF
(C)	PERMANENT PAVEMENT STRIPING, SYMBOL/LEGEND, ALKYD THERMOPLASTIC, WHITE (ITEM 748015)	0 LF
(D)	13" REFLECTIVE PREFORMED PATTERNED CONTRAST MARKINGS, 3' LINE & 9' GAP (ITEM 748567)	0 LF
(E)	8" REFLECTIVE PREFORMED PATTERNED CONTRAST MARKINGS, 10' LINE & 30' GAP (ITEM 748566)	0 LF
(F)	12" SOLID WHITE RETROFLECTIVE PREFORMED PATTERNED MARKING (TAPE) (ITEM 748513)	0 LF
(G)	3" PERMANENT PAVEMENT STRIPING, EPOXY RESIN PAINT, BLACK (ITEM 748557)	0 LF
(H)	5" PERMANENT PAVEMENT STRIPING, EPOXY RESIN PAINT, WHITE, 10' LINE 30' GAP (ITEM 748548)	0 LF
(I)	RETROFLECTIVE PREFORMED PATTERNED MARKING SYMBOL/LEGEND (ITEM 748529)	0 LF

PAVEMENT MARKINGS LEGEND		
SYMBOL	ITEM	QUANTITY
(J)	10" PERMANENT PAVEMENT STRIPING, EPOXY RESIN PAINT, WHITE, 2' LINE & 6' GAP (ITEM 748548)	0 LF
(K)	10" PERMANENT PAVEMENT STRIPING, EPOXY RESIN PAINT, WHITE (ITEM 748549)	0 LF
(L)	10" PERMANENT PAVEMENT STRIPING, EPOXY RESIN PAINT, WHITE, 2' LINE & 2' GAP (ITEM 748549)	0 LF
(M)	5" PERMANENT PAVEMENT STRIPING, EPOXY RESIN PAINT, WHITE, 2' LINE & 6' GAP (ITEM 748548)	0 LF
(N)	5" PERMANENT PAVEMENT STRIPING, EPOXY RESIN PAINT, DOUBLE YELLOW (ITEM 748548)	0 LF

PAVEMENT MARKINGS LEGEND		
SYMBOL	ITEM	QUANTITY
(O)	12" PERMANENT PAVEMENT STRIPING, EPOXY RESIN PAINT, YELLOW (ITEM 748509)	0 LF
(P)	10" REFLECTIVE PREFORMED PATTERNED CONTRAST MARKINGS, 2' LINE & 6' GAP (ITEM 748565)	0 LF
(R)	5" REFLECTIVE PREFORMED PATTERNED CONTRAST MARKINGS, 2' LINE & 6' GAP (ITEM 748564)	0 LF
(S)	5" PERMANENT PAVEMENT STRIPING, EPOXY RESIN PAINT, YELLOW, 10' LINE 30' GAP (ITEM 748548)	89 LF

SIGNING LEGEND	
(1)	REMOVE EXISTING SIGN
(2)	EXISTING SIGN TO REMAIN
(3)	PLACE NEW SIGN
(4)	RENEW EXISTING SIGN
(5)	REPOSITION EXISTING SIGN

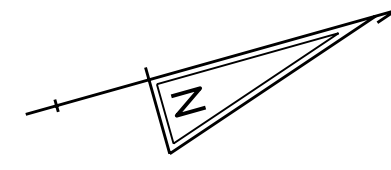


MATCH LINE STA 190+00 SHEET MD-51



J:\2008 PROJECTS\NE3\34801\700CADD\750AET\DESIGN SECTION 2 PLANS\MD_301AETDS2_052.DGN

<p>DELAWARE DEPARTMENT OF TRANSPORTATION</p>	ADDENDUMS / REVISIONS	<p>SCALE</p> <p>FEET</p>	<p>US 301 MARYLAND STATE LINE TO LEVELS ROAD</p>	CONTRACT	BRIDGE NO.	<p>SIGNING, STRIPING & CONDUIT PLAN</p>	MD-52	
					T200911303		DESIGNED BY: MGP	SHEET NO.
					NEW CASTLE		CHECKED BY: SKH	1164
							TOTAL SHTS.	
							1256	

MATCH LINE STA 1294+00 SHEET MD-54

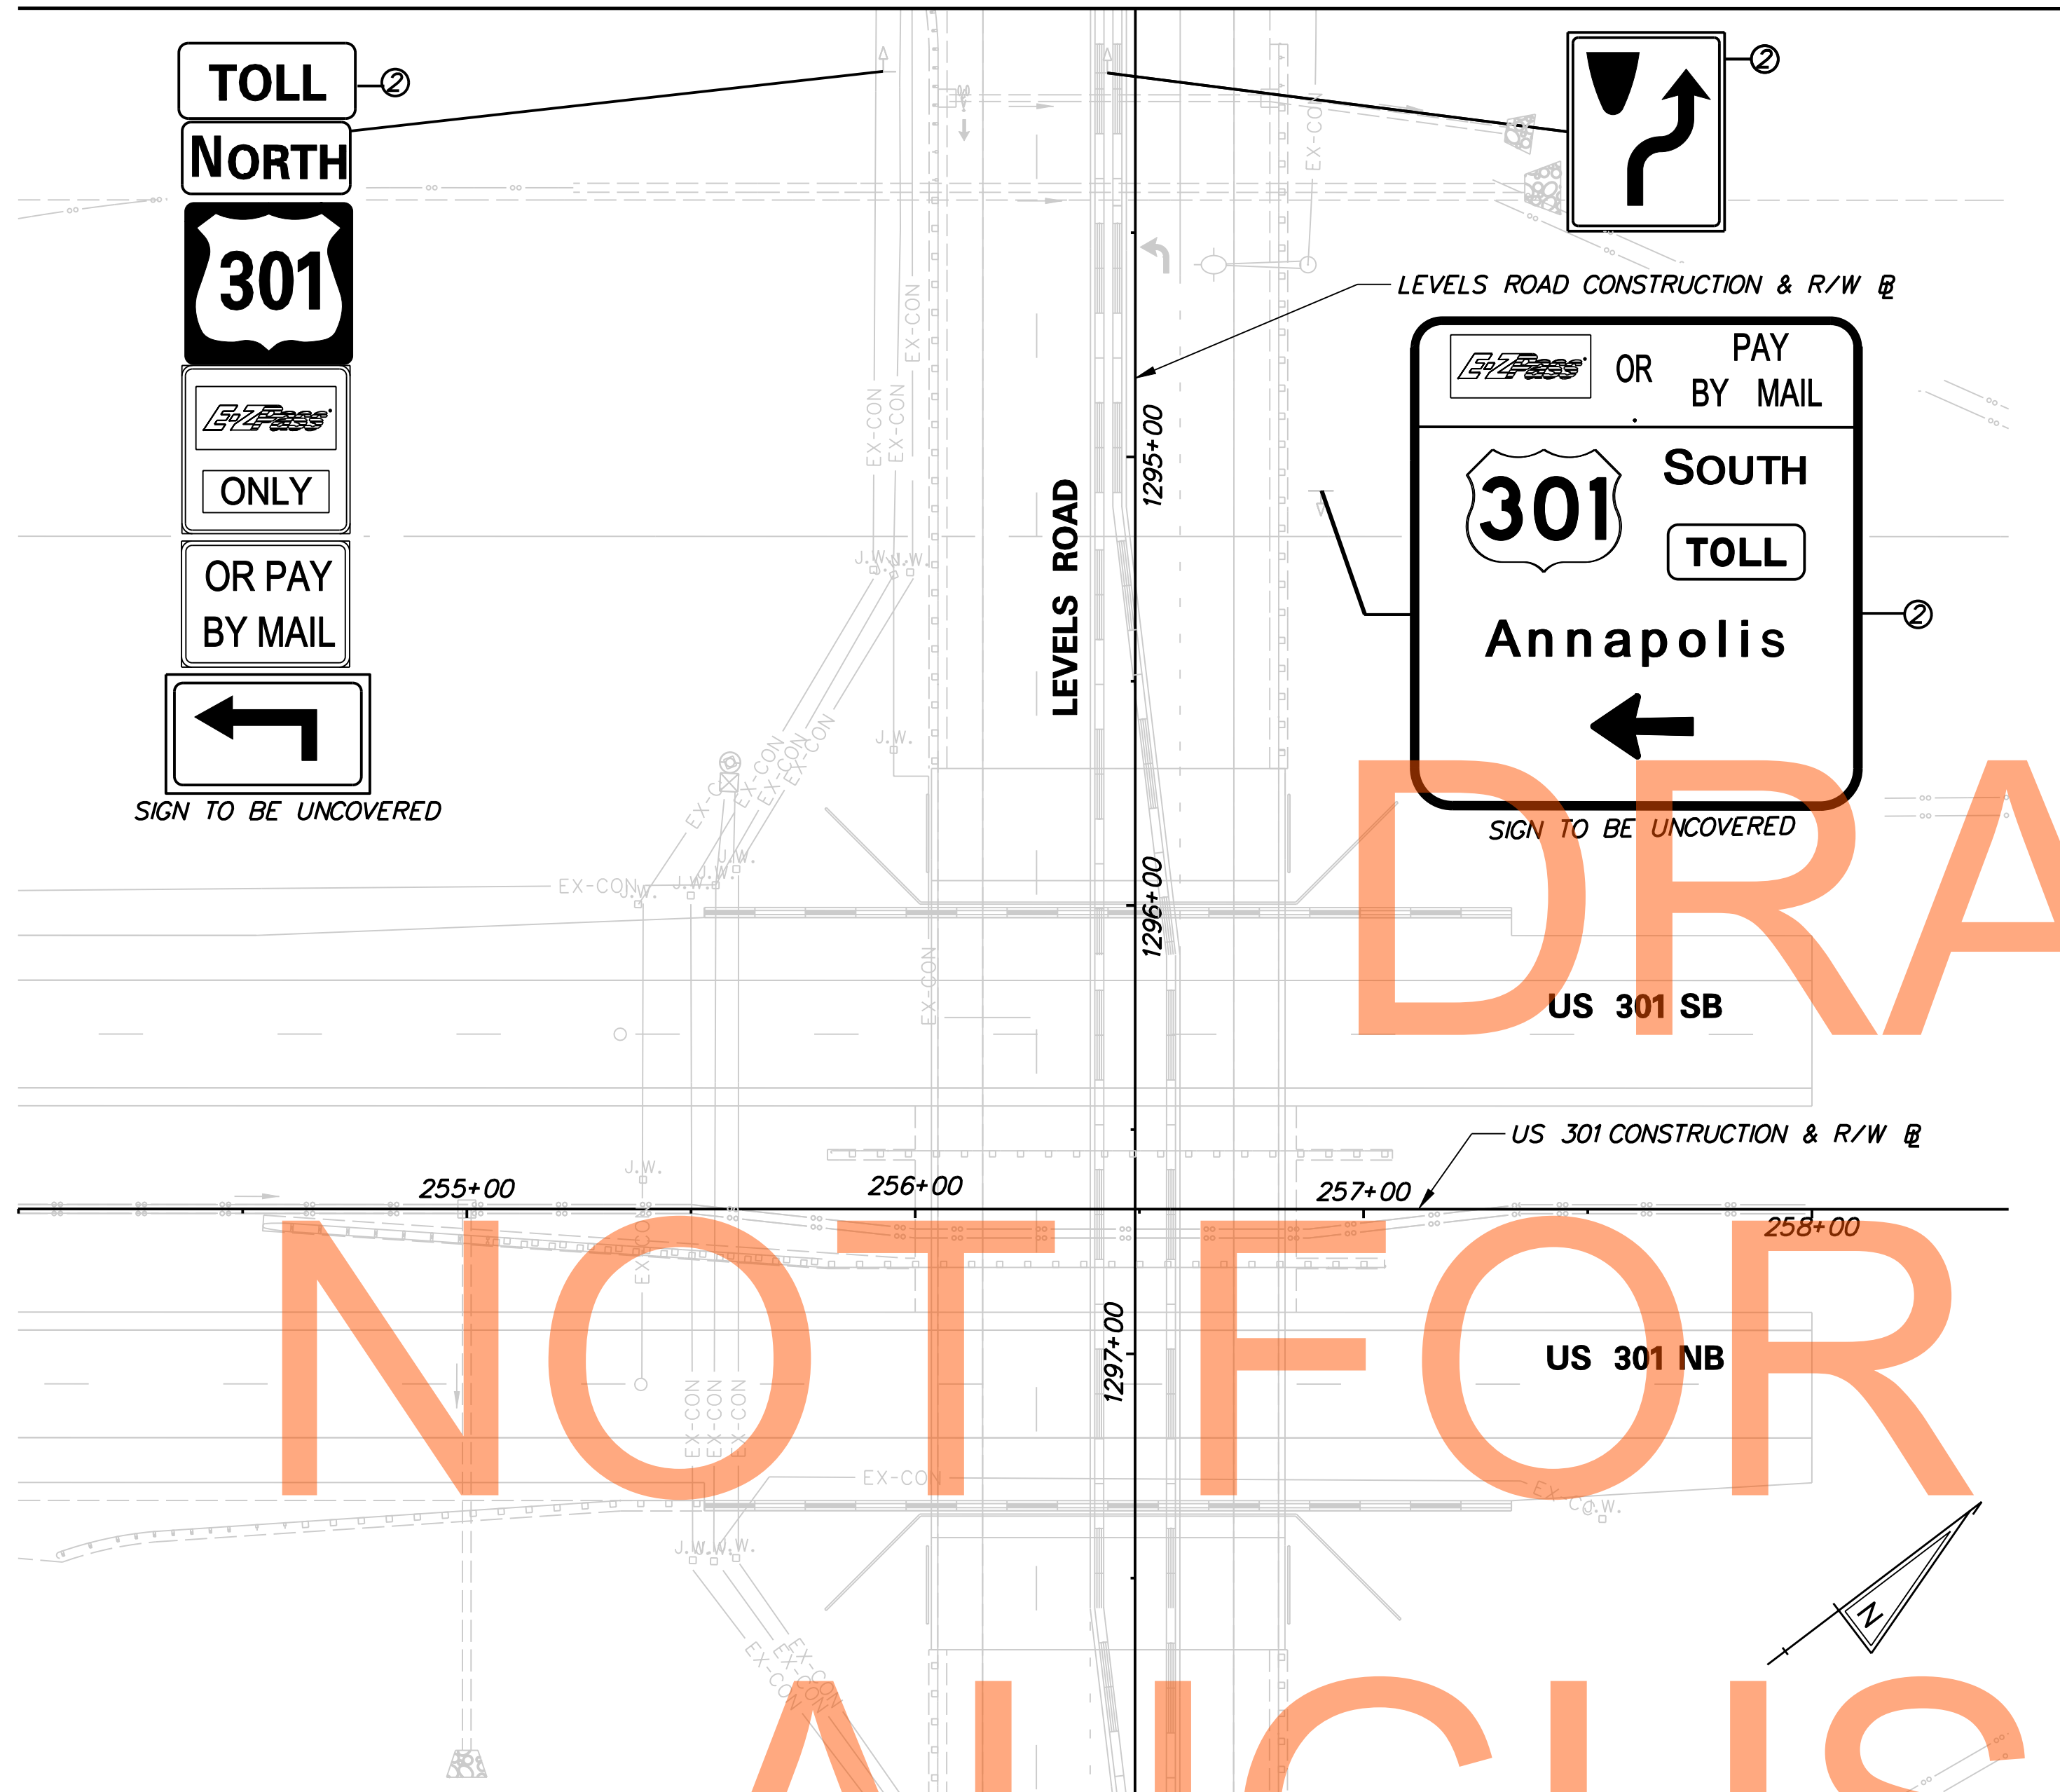

MATCH LINE STA 1298+00 SHEET MD-55

PANEL DESIGNATION	DWG. NO. (MD)	QUANTITY	LEGEND	SIZE			COLOR		BORDER			REMARKS
				AREA	WIDTH	HEIGHT	LEGEND	BCKGRND	WIDTH	RADIUS	ARROW	
GM-2	50	1		63 SF	14'	4.5'	BLK	Y	2"	12"	-	EXTRUDED ALUMINUM (1) Clearview Hwy-4-W
				189 SF	14'	13.5'	W	G	2"	12"	-	

LEGEND & BACKGROUND COLORS: BLK=BLACK, BLU=BLUE, G=GREEN, R=RED, W=WHITE/SILVER, Y=YELLOW, FY=FLUORESCENT YELLOW, P=PURPLE
REFER TO THE DELDOT WEBSITE FOR THE LATEST "E-ZPass" LOGO DETAIL.

GUIDE SIGN STEEL SUPPORT CHART


SIGN NO.	SIGN SIZE (WXH)	PLAN SHEET NO.	POST SIZE	BW OR NBW*	SUPPORT L-1	SUPPORT L-2	SUPPORT L-3	LATERAL CLEARANCE		SUPPORT SPACING FROM LEFT EDGE OF SIGN
								OFFSET	OBJECT**	
GM-2	14' X 18'	MD-50	W18X40	BW	27.24'	28.65'	-	6.0'	ES	2.8' - 8.4' - 2.8'

* BW=BREAKAWAY, NBW=NON-BREAKAWAY **EDGE OF SHOULDER

NOTE: SUPPLY OF NON-BREAKAWAY I-BEAMS WILL BE PAID FOR UNDER THE RESPECTIVE SUPPLY OF BREAKAWAY I-BEAM SIGN POST ITEM. COST OF FURNISHING AND INSTALLING NON-BREAKAWAY BASE PLATE WILL NOT BE MEASURED AND PAID FOR, BUT WILL BE INCIDENTAL TO THE RESPECTIVE BREAKAWAY I-BEAM SIGN POST ITEM.

SIGNING LEGEND

- ① REMOVE EXISTING SIGN
- ② EXISTING SIGN TO REMAIN
- ③ PLACE NEW SIGN
- ④ RENEW EXISTING SIGN
- ⑤ REPOSITION EXISTING SIGN

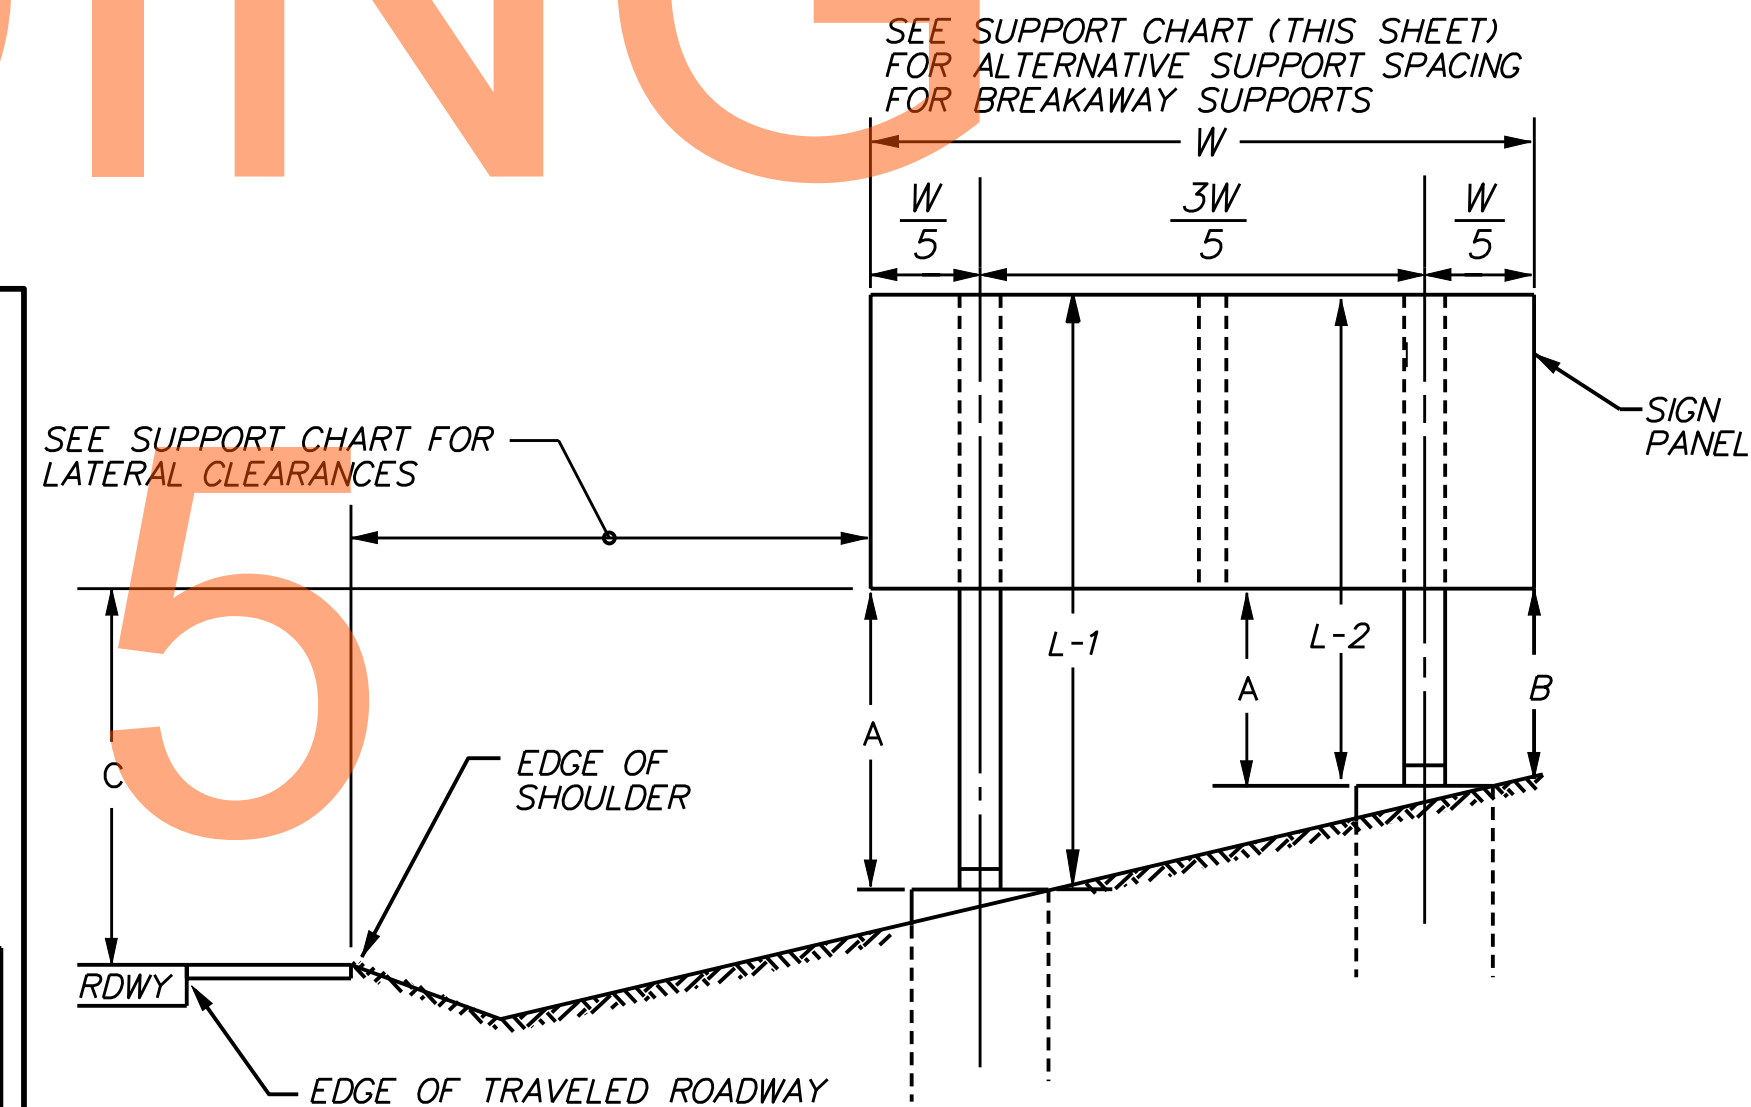

VERTICAL CLEARANCE OF SIGNS

A. 7'-6" MINIMUM FOR BREAKAWAY SUPPORTS OR 5'-6" FOR NON-BREAKAWAY SUPPORTS.
 B. 2.0' MINIMUM
 C. 7'-6" MINIMUM & PREFERABLE. THIS DIMENSION IS TO BE INCREASED ONLY WHEN REQUIRED TO MEET A = 7'-6" FOR BREAKAWAY OR A (MIN.) = 5'-6" FOR NON-BREAKAWAY AND B (MIN) 2'-0"
 ALL DIMENSIONS ARE TO BOTTOM OF SIGN

TOTAL WEIGHT BELOW THE HINGES SHOULD BE LESS THAN 600 POUNDS

SIGN VERTICAL AND LATERAL CLEARANCE DETAIL

PAVEMENT MARKINGS LEGEND

SYMBOL	ITEM	QUANTITY
(A)	5" PERMANENT PAVEMENT STRIPING, EPOXY RESIN PAINT, WHITE (ITEM 748548)	0 LF
(B)	5" PERMANENT PAVEMENT STRIPING, EPOXY RESIN PAINT, YELLOW (ITEM 748548)	0 LF
(C)	PERMANENT PAVEMENT STRIPING, SYMBOL/LEGEND, ALKYD THERMOPLASTIC, WHITE (ITEM 748015)	0 LF
(D)	13" REFLECTIVE PREFORMED PATTERNED CONTRAST MARKINGS, 3' LINE & 9' GAP (ITEM 748567)	0 LF
(E)	8" REFLECTIVE PREFORMED PATTERNED CONTRAST MARKINGS, 10' LINE & 30' GAP (ITEM 748566)	0 LF
(F)	12" SOLID WHITE RETROFLECTIVE PREFORMED PATTERNED MARKING (TAPE) (ITEM 748513)	0 LF

PAVEMENT MARKINGS LEGEND

SYMBOL	ITEM	QUANTITY
(G)	3" PERMANENT PAVEMENT STRIPING, EPOXY RESIN PAINT, BLACK (ITEM 748557)	0 LF
(H)	5" PERMANENT PAVEMENT STRIPING, EPOXY RESIN PAINT, WHITE, 10' LINE 30' GAP (ITEM 748548)	0 LF
(I)	RETROFLECTIVE PREFORMED PATTERNED MARKING SYMBOL/LEGEND (ITEM 748529)	0 LF
(J)	10" PERMANENT PAVEMENT STRIPING, EPOXY RESIN PAINT, WHITE, 2' LINE & 6' GAP (ITEM 748548)	0 LF
(K)	10" PERMANENT PAVEMENT STRIPING, EPOXY RESIN PAINT, WHITE (ITEM 748549)	0 LF
(L)	10" PERMANENT PAVEMENT STRIPING, EPOXY RESIN PAINT, WHITE, 2' LINE & 2' GAP (ITEM 748549)	0 LF

PAVEMENT MARKINGS LEGEND

SYMBOL	ITEM	QUANTITY
(M)	5" PERMANENT PAVEMENT STRIPING, EPOXY RESIN PAINT, WHITE, 2' LINE & 6' GAP (ITEM 748548)	0 LF
(N)	5" PERMANENT PAVEMENT STRIPING, EPOXY RESIN PAINT, DOUBLE YELLOW (ITEM 748548)	0 LF
(O)	12" PERMANENT PAVEMENT STRIPING, EPOXY RESIN PAINT, YELLOW (ITEM 748509)	0 LF
(P)	10" REFLECTIVE PREFORMED PATTERNED CONTRAST MARKINGS, 2' LINE & 6' GAP (ITEM 748565)	0 LF
(R)	5" REFLECTIVE PREFORMED PATTERNED CONTRAST MARKINGS, 2' LINE & 6' GAP (ITEM 748564)	0 LF
(S)	5" PERMANENT PAVEMENT STRIPING, EPOXY RESIN PAINT, YELLOW, 10' LINE 30' GAP (ITEM 748548)	0 LF

ADDENDUMS / REVISIONS



US 301 MARYLAND STATE LINE TO LEVELS ROAD


CONTRACT	BRIDGE NO.
T200911303	
COUNTY	DESIGNED BY: MGP
NEW CASTLE	CHECKED BY: SKH

SIGNING, STRIPING & CONDUIT PLAN


MD-53
SHEET NO.
1165
TOTAL SHTS.
1256

J:\2008 PROJECTS\E3\34801\700CADD\DESIGN SECTION 2 PLANS\MD_301AETDS2_053.DGN



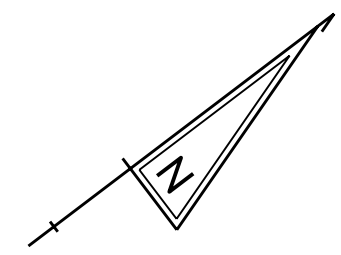

MATCH LINE STA 1290+00 SHEET MD-57

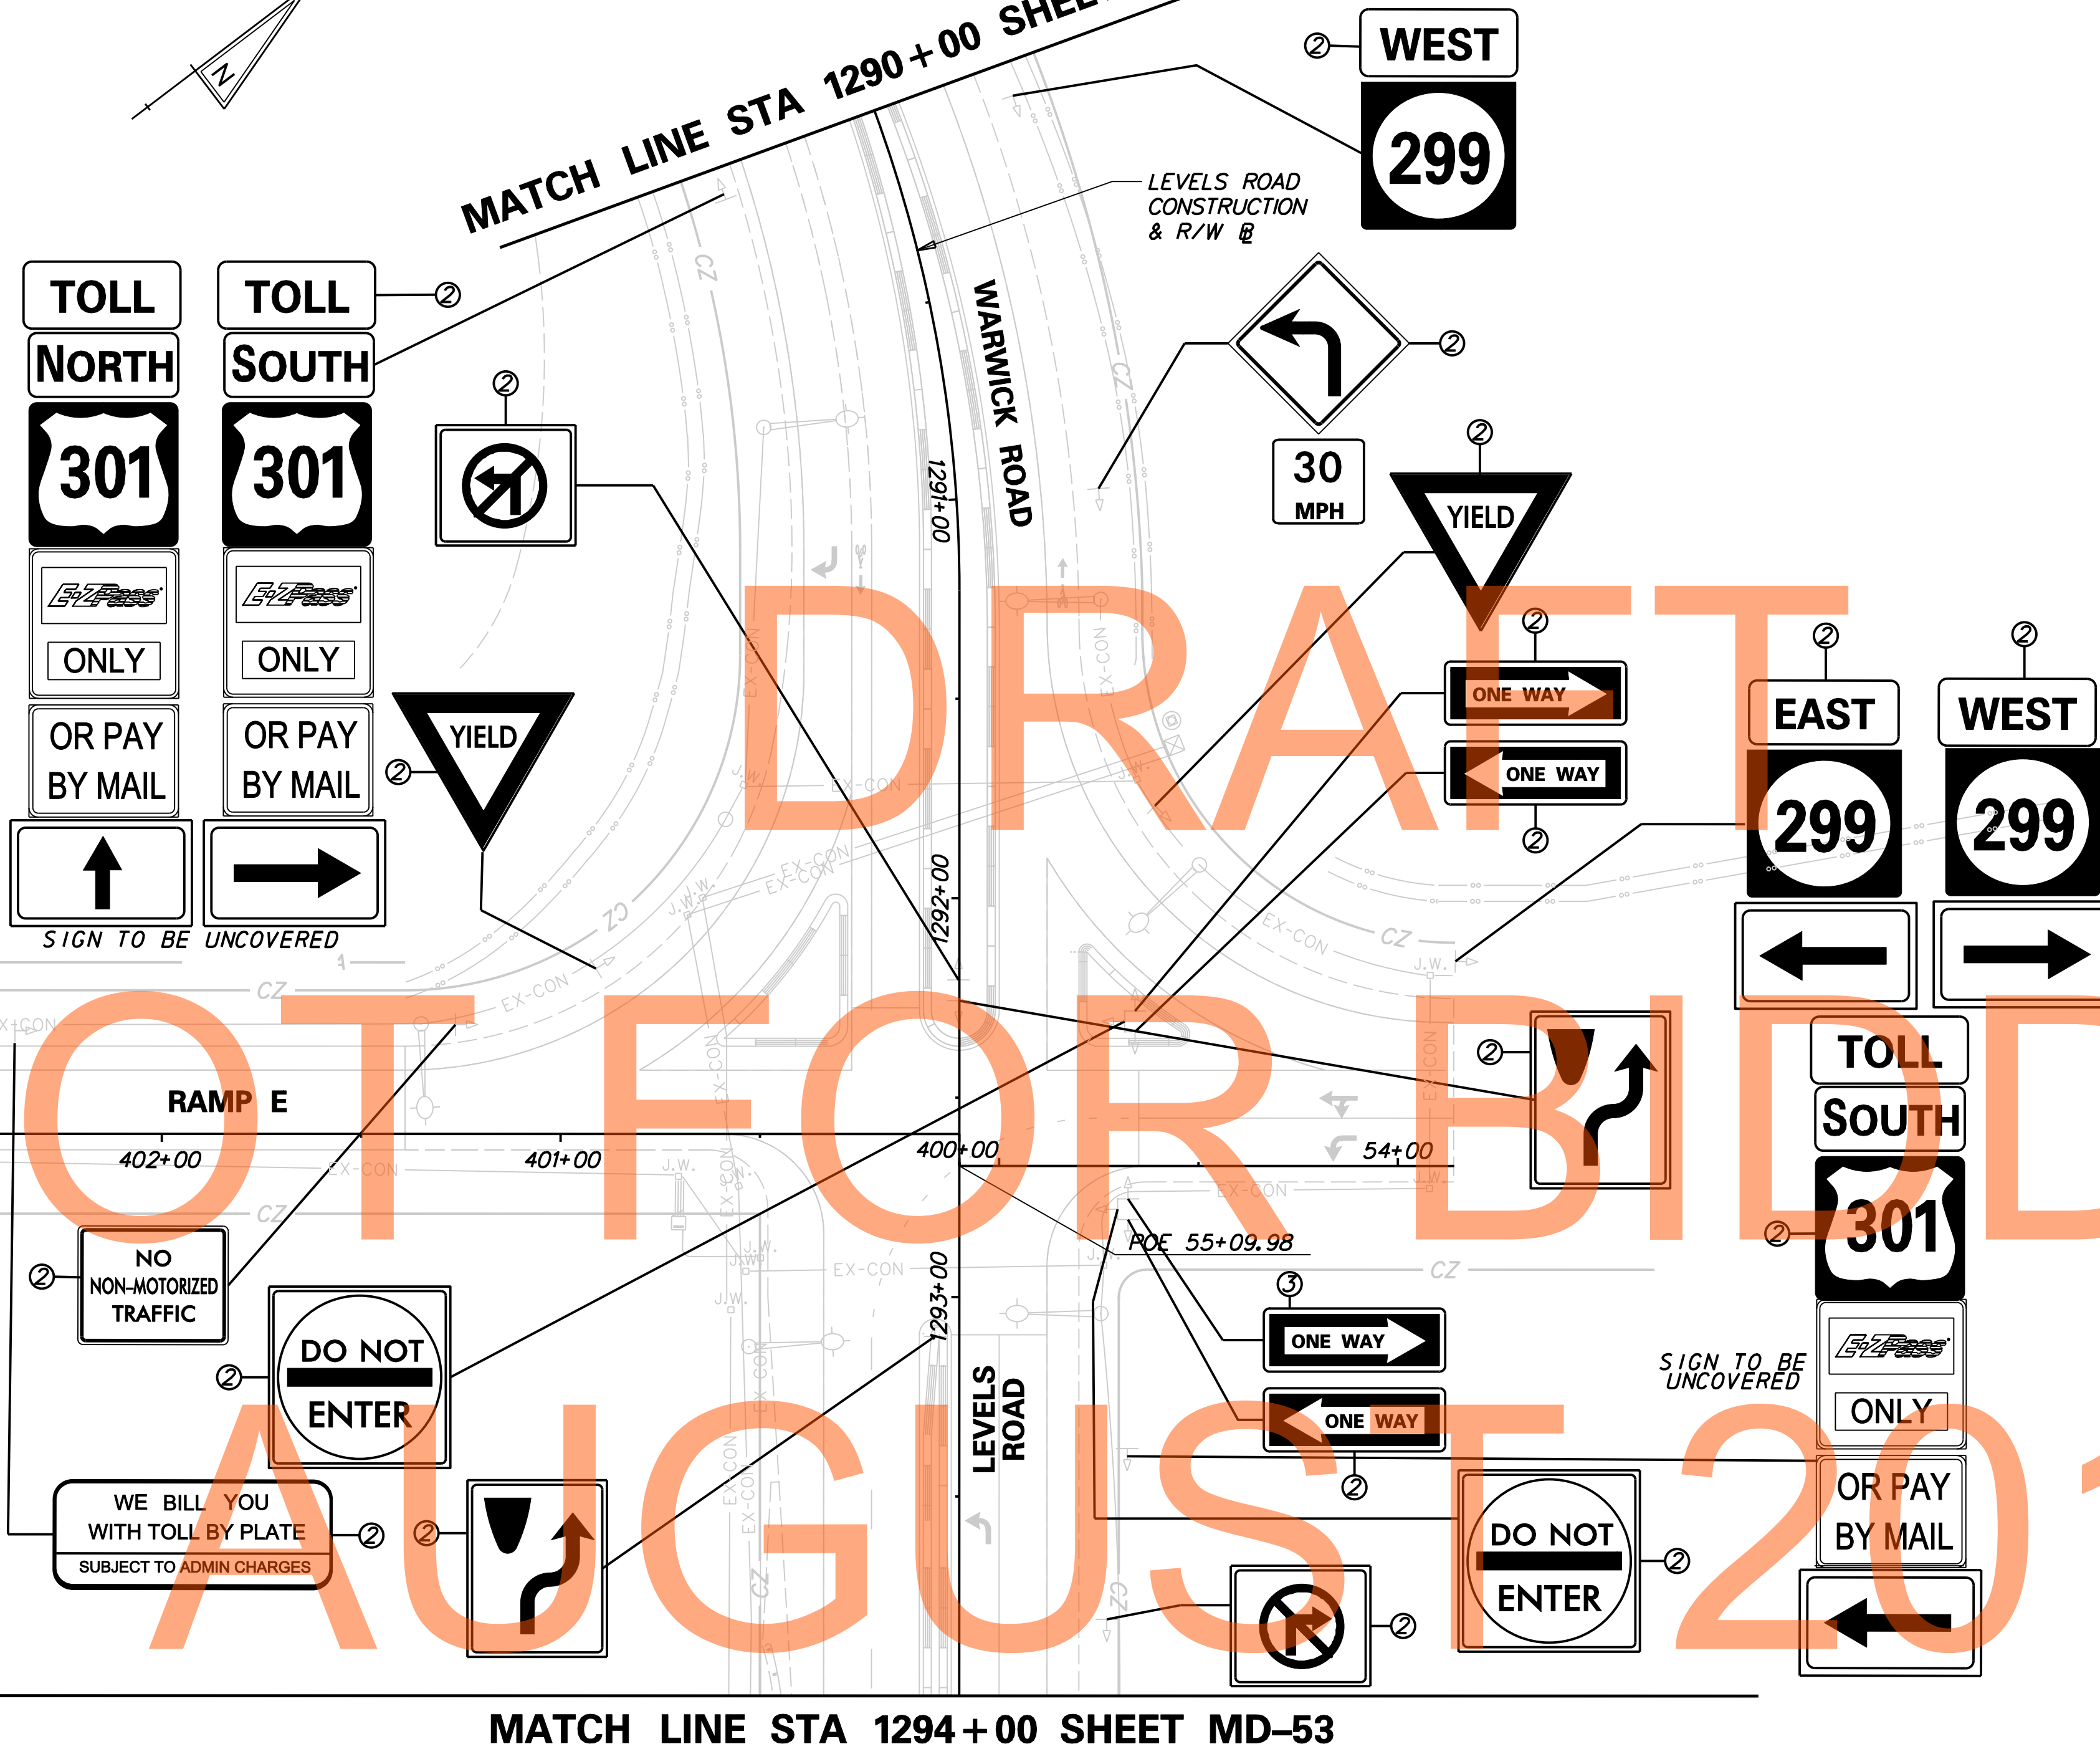

PAVEMENT MARKINGS LEGEND		
SYMBOL	ITEM	QUANTITY
(A)	5" PERMANENT PAVEMENT STRIPING, EPOXY RESIN PAINT, WHITE (ITEM 748548)	0 LF
(B)	5" PERMANENT PAVEMENT STRIPING, EPOXY RESIN PAINT, YELLOW (ITEM 748548)	0 LF
(C)	PERMANENT PAVEMENT STRIPING, SYMBOL/LEGEND, ALKYD THERMOPLASTIC, WHITE (ITEM 748015)	0 LF
(D)	13" REFLECTIVE PREFORMED PATTERNED CONTRAST MARKINGS, 3' LINE & 9' GAP (ITEM 748567)	0 LF
(E)	8" REFLECTIVE PREFORMED PATTERNED CONTRAST MARKINGS, 10' LINE & 30' GAP (ITEM 748566)	0 LF
(F)	12" SOLID WHITE RETROREFLECTIVE PREFORMED PATTERNED MARKING (TAPE) (ITEM 748513)	0 LF
(G)	3" PERMANENT PAVEMENT STRIPING, EPOXY RESIN PAINT, BLACK (ITEM 748557)	0 LF
(H)	5" PERMANENT PAVEMENT STRIPING, EPOXY RESIN PAINT, WHITE, 10' LINE 30' GAP (ITEM 748548)	0 LF
(I)	RETROREFLECTIVE PREFORMED PATTERNED MARKING SYMBOL/LEGEND (ITEM 748529)	0 LF
(J)	10" PERMANENT PAVEMENT STRIPING, EPOXY RESIN PAINT, WHITE, 2' LINE & 6' GAP (ITEM 748548)	0 LF
(K)	10" PERMANENT PAVEMENT STRIPING, EPOXY RESIN PAINT, WHITE (ITEM 748549)	0 LF
(L)	10" PERMANENT PAVEMENT STRIPING, EPOXY RESIN PAINT, WHITE, 2' LINE & 2' GAP (ITEM 748549)	0 LF
(M)	5" PERMANENT PAVEMENT STRIPING, EPOXY RESIN PAINT, WHITE, 2' LINE & 6' GAP (ITEM 748548)	0 LF
(N)	5" PERMANENT PAVEMENT STRIPING, EPOXY RESIN PAINT, DOUBLE YELLOW (ITEM 748548)	0 LF
(O)	12" PERMANENT PAVEMENT STRIPING, EPOXY RESIN PAINT, YELLOW (ITEM 748509)	0 LF
(P)	10" REFLECTIVE PREFORMED PATTERNED CONTRAST MARKINGS, 2' LINE & 6' GAP (ITEM 748565)	0 LF
(R)	5" REFLECTIVE PREFORMED PATTERNED CONTRAST MARKINGS, 2' LINE & 6' GAP (ITEM 748564)	0 LF
(S)	5" PERMANENT PAVEMENT STRIPING, EPOXY RESIN PAINT, YELLOW, 10' LINE 30' GAP (ITEM 748548)	0 LF

SIGNING LEGEND	
①	REMOVE EXISTING SIGN
②	EXISTING SIGN TO REMAIN
③	PLACE NEW SIGN
④	RENEW EXISTING SIGN
⑤	REPOSITION EXISTING SIGN


NOT FOR BIDDING
AUGUST 2015

MATCH LINE STA 1294+00 SHEET MD-53

J:\2008 PROJECTS\E3X34801\700CADD\750AET\DESIGN_SECTION_2_PLANS\MD_301AETDS2_054.DGN



ADDENDUMS / REVISIONS

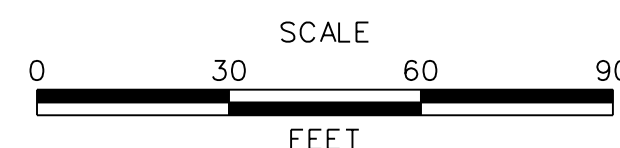


US 301
MARYLAND STATE LINE
TO LEVELS ROAD

CONTRACT	BRIDGE NO.
T200911303	
COUNTY	DESIGNED BY: MGP
NEW CASTLE	CHECKED BY: SKH

**SIGNING, STRIPING &
CONDUIT PLAN**

MD-54
SHEET NO.
1166
TOTAL SHTS.
1256

MATCH LINE STA 1298+00 SHEET MD-53

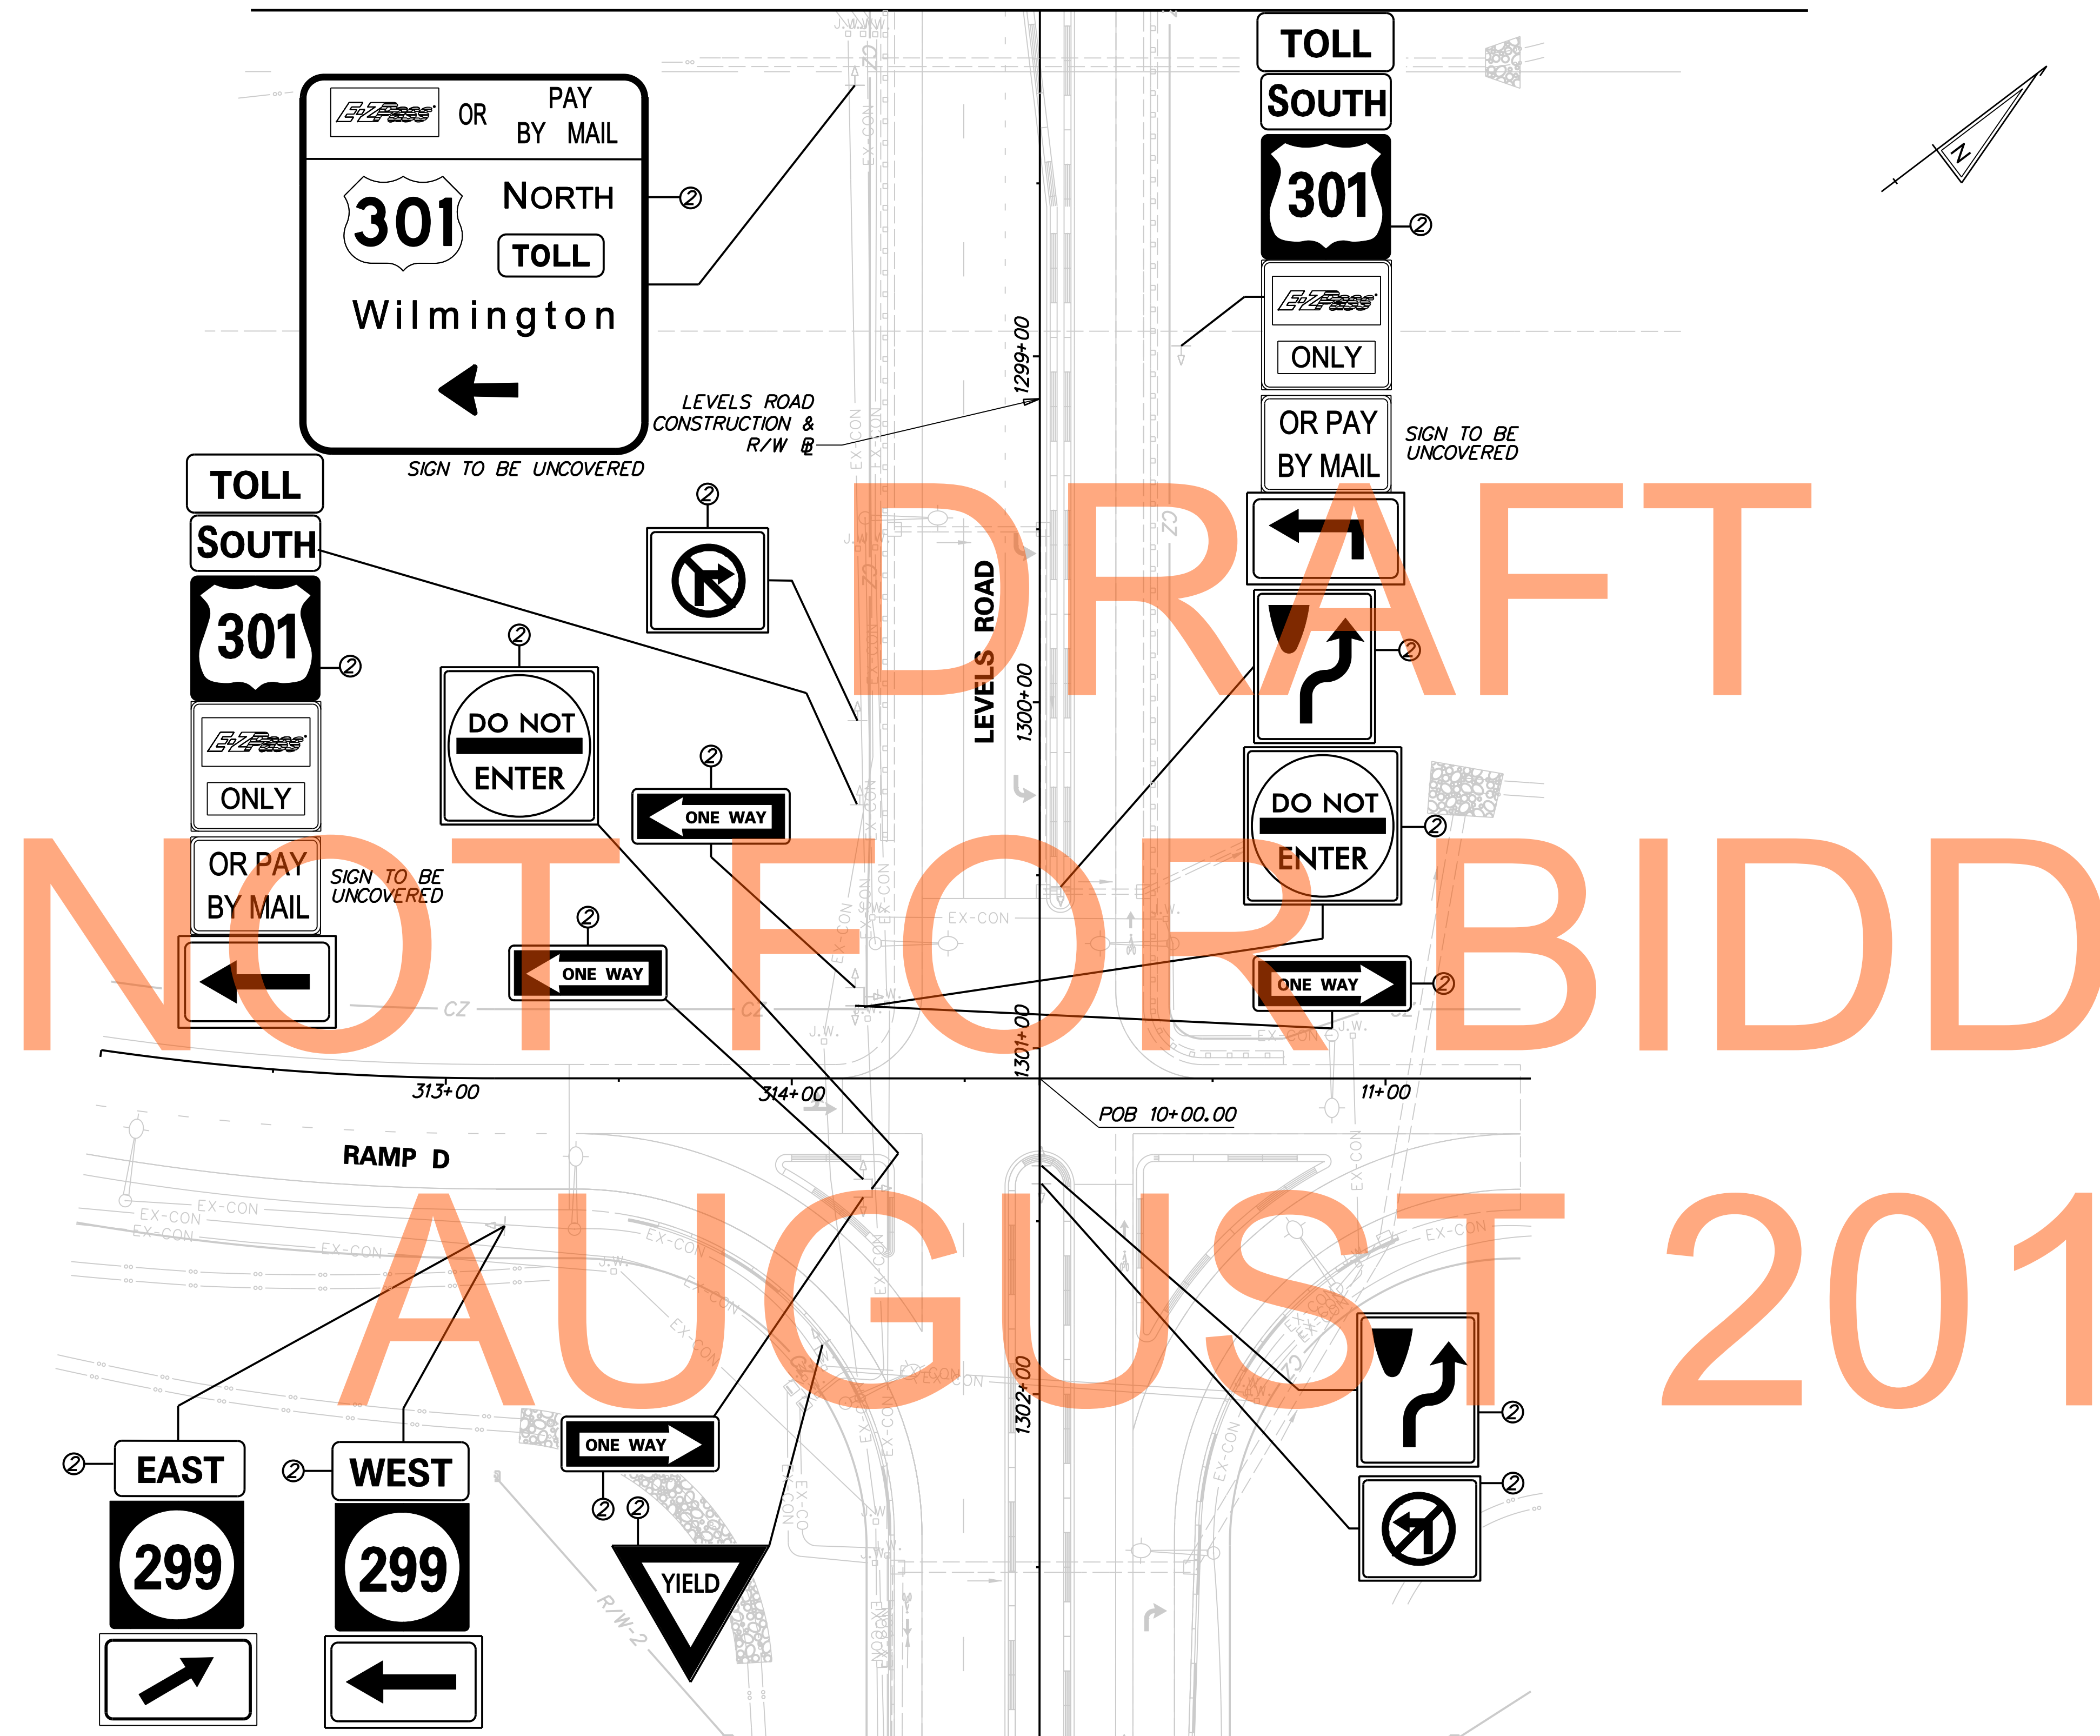

PAVEMENT MARKINGS LEGEND		
SYMBOL	ITEM	QUANTITY
(A)	5" PERMANENT PAVEMENT STRIPING, EPOXY RESIN PAINT, WHITE (ITEM 748548)	0 LF
(B)	5" PERMANENT PAVEMENT STRIPING, EPOXY RESIN PAINT, YELLOW (ITEM 748548)	0 LF
(C)	PERMANENT PAVEMENT STRIPING, SYMBOL/LEGEND, ALKYD THERMOPLASTIC, WHITE (ITEM 748015)	0 LF
(D)	13" REFLECTIVE PREFORMED PATTERNED CONTRAST MARKINGS, 3' LINE & 9' GAP (ITEM 748567)	0 LF
(E)	8" REFLECTIVE PREFORMED PATTERNED CONTRAST MARKINGS, 10' LINE & 30' GAP (ITEM 748566)	0 LF
(F)	12" SOLID WHITE RETROREFLECTIVE PREFORMED PATTERNED MARKING (TAPE) (ITEM 748513)	0 LF
(G)	3" PERMANENT PAVEMENT STRIPING, EPOXY RESIN PAINT, BLACK (ITEM 748557)	0 LF
(H)	5" PERMANENT PAVEMENT STRIPING, EPOXY RESIN PAINT, WHITE, 10' LINE 30' GAP (ITEM 748548)	0 LF
(I)	RETROREFLECTIVE PREFORMED PATTERNED MARKING SYMBOL/LEGEND (ITEM 748529)	0 LF
(J)	10" PERMANENT PAVEMENT STRIPING, EPOXY RESIN PAINT, WHITE, 2' LINE & 6' GAP (ITEM 748548)	0 LF
(K)	10" PERMANENT PAVEMENT STRIPING, EPOXY RESIN PAINT, WHITE (ITEM 748549)	0 LF
(L)	10" PERMANENT PAVEMENT STRIPING, EPOXY RESIN PAINT, WHITE, 2' LINE & 2' GAP (ITEM 748549)	0 LF
(M)	5" PERMANENT PAVEMENT STRIPING, EPOXY RESIN PAINT, WHITE, 2' LINE & 6' GAP (ITEM 748548)	0 LF
(N)	5" PERMANENT PAVEMENT STRIPING, EPOXY RESIN PAINT, DOUBLE YELLOW (ITEM 748548)	0 LF
(O)	12" PERMANENT PAVEMENT STRIPING, EPOXY RESIN PAINT, YELLOW (ITEM 748509)	0 LF
(P)	10" REFLECTIVE PREFORMED PATTERNED CONTRAST MARKINGS, 2' LINE & 6' GAP (ITEM 748565)	0 LF
(R)	5" REFLECTIVE PREFORMED PATTERNED CONTRAST MARKINGS, 2' LINE & 6' GAP (ITEM 748564)	0 LF
(S)	5" PERMANENT PAVEMENT STRIPING, EPOXY RESIN PAINT, YELLOW, 10' LINE 30' GAP (ITEM 748548)	0 LF


SIGNING LEGEND	
①	REMOVE EXISTING SIGN
②	EXISTING SIGN TO REMAIN
③	PLACE NEW SIGN
④	RENEW EXISTING SIGN
⑤	REPOSITION EXISTING SIGN

MATCH LINE STA 1303+00 SHEET MD-58

J:\2008 PROJECTS\NE3\34801\700CADD\750AET\DESIGN SECTION 2 PLANS\MD_301AETDS2_055.DGN



ADDENDUMS / REVISIONS

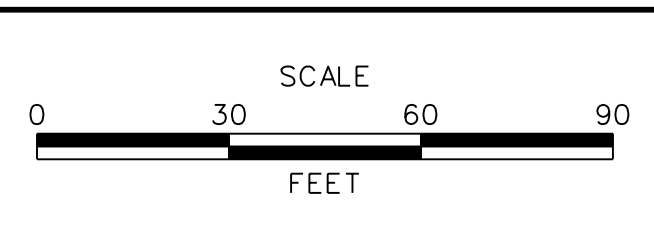

US 301
MARYLAND STATE LINE
TO LEVELS ROAD

CONTRACT T200911303	BRIDGE NO.
COUNTY NEW CASTLE	DESIGNED BY: MGP
	CHECKED BY: SKH


SIGNING, STRIPING &
CONDUIT PLAN

MD-55
SHEET NO. 1167
TOTAL SHTS. 1256



SIGNING LEGEND	
①	REMOVE EXISTING SIGN
②	EXISTING SIGN TO REMAIN
③	PLACE NEW SIGN
④	RENEW EXISTING SIGN
⑤	REPOSITION EXISTING SIGN

PAVEMENT MARKINGS LEGEND		
SYMBOL	ITEM	QUANTITY
(A)	5" PERMANENT PAVEMENT STRIPING, EPOXY RESIN PAINT, WHITE (ITEM 748548)	0 LF
(B)	5" PERMANENT PAVEMENT STRIPING, EPOXY RESIN PAINT, YELLOW (ITEM 748548)	0 LF
(C)	PERMANENT PAVEMENT STRIPING, SYMBOL/LEGEND, ALKYD THERMOPLASTIC, WHITE (ITEM 748015)	0 LF
(D)	13" REFLECTIVE PREFORMED PATTERNED CONTRAST MARKINGS, 3' LINE & 9" GAP (ITEM 748567)	0 LF
(E)	8" REFLECTIVE PREFORMED PATTERNED CONTRAST MARKINGS, 10' LINE & 30' GAP (ITEM 748566)	0 LF
(F)	12" SOLID WHITE RETROFLECTIVE PREFORMED PATTERNED MARKING (TAPE) (ITEM 748513)	0 LF

PAVEMENT MARKINGS LEGEND		
SYMBOL	ITEM	QUANTITY
(G)	3" PERMANENT PAVEMENT STRIPING, EPOXY RESIN PAINT, BLACK (ITEM 748557)	0 LF
(H)	5" PERMANENT PAVEMENT STRIPING, EPOXY RESIN PAINT, WHITE, 10' LINE 30' GAP (ITEM 748548)	0 LF
(I)	RETROFLECTIVE PREFORMED PATTERNED MARKING SYMBOL/LEGEND (ITEM 748529)	0 LF
(J)	10" PERMANENT PAVEMENT STRIPING, EPOXY RESIN PAINT, WHITE, 2' LINE & 6' GAP (ITEM 748548)	0 LF
(K)	10" PERMANENT PAVEMENT STRIPING, EPOXY RESIN PAINT, WHITE (ITEM 748549)	0 LF
(L)	10" PERMANENT PAVEMENT STRIPING, EPOXY RESIN PAINT, WHITE, 2' LINE & 2' GAP (ITEM 748549)	0 LF
(M)	5" PERMANENT PAVEMENT STRIPING, EPOXY RESIN PAINT, WHITE, 2' LINE & 6' GAP (ITEM 748548)	0 LF
(N)	5" PERMANENT PAVEMENT STRIPING, EPOXY RESIN PAINT, DOUBLE YELLOW (ITEM 748548)	0 LF
(O)	12" PERMANENT PAVEMENT STRIPING, EPOXY RESIN PAINT, YELLOW (ITEM 748509)	0 LF
(P)	10" REFLECTIVE PREFORMED PATTERNED CONTRAST MARKINGS, 2' LINE & 6' GAP (ITEM 748565)	0 LF
(R)	5" REFLECTIVE PREFORMED PATTERNED CONTRAST MARKINGS, 2' LINE & 6' GAP (ITEM 748564)	0 LF
(S)	5" PERMANENT PAVEMENT STRIPING, EPOXY RESIN PAINT, YELLOW, 10' LINE 30' GAP (ITEM 748548)	0 LF

 


DRAFT
NOT FOR BIDDING
AUGUST 2015

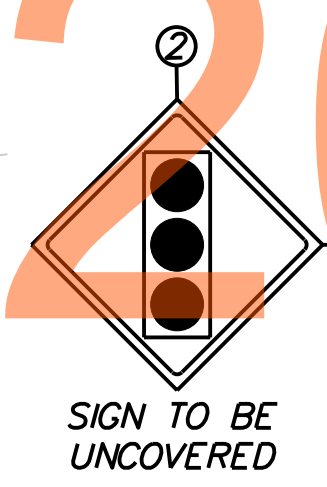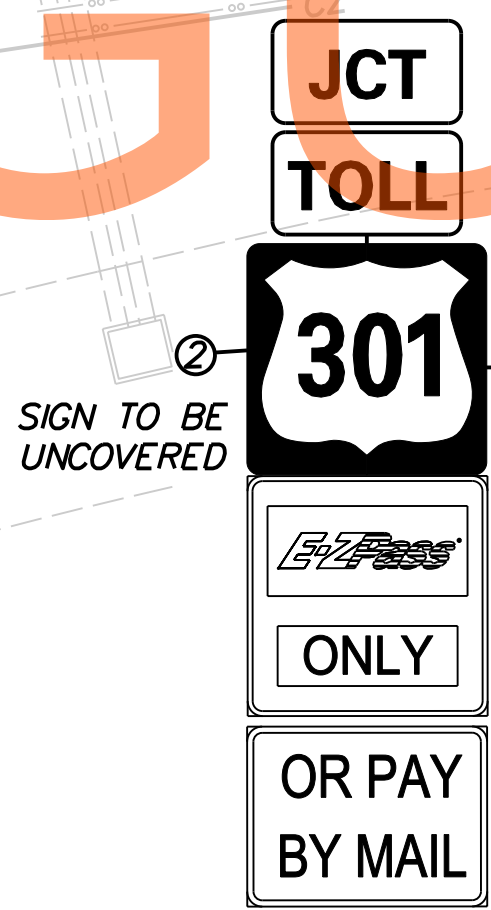

J:\2008 PROJECTS\NE3\3480\700CADD\750AET\DESIGN SECTION 2 PLANS\MD_301AETDS2_056.DGN


ADDENDUMS / REVISIONS

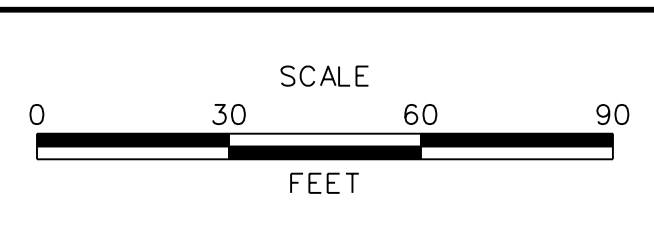

CONTRACT	BRIDGE NO.
T200911303	
COUNTY	DESIGNED BY: MGP
NEW CASTLE	CHECKED BY: SKH

SIGNING LEGEND	
①	REMOVE EXISTING SIGN
②	EXISTING SIGN TO REMAIN
③	PLACE NEW SIGN
④	RENEW EXISTING SIGN
⑤	REPOSITION EXISTING SIGN


PAVEMENT MARKINGS LEGEND		
SYMBOL	ITEM	QUANTITY
(A)	5" PERMANENT PAVEMENT STRIPING, EPOXY RESIN PAINT, WHITE (ITEM 748548)	0 LF
(B)	5" PERMANENT PAVEMENT STRIPING, EPOXY RESIN PAINT, YELLOW (ITEM 748548)	0 LF
(C)	PERMANENT PAVEMENT STRIPING, SYMBOL/LEGEND, ALKYD THERMOPLASTIC, WHITE (ITEM 748015)	0 LF
(D)	13" REFLECTIVE PREFORMED PATTERNED CONTRAST MARKINGS, 3' LINE & 9' GAP (ITEM 748567)	0 LF
(E)	8" REFLECTIVE PREFORMED PATTERNED CONTRAST MARKINGS, 10' LINE & 30' GAP (ITEM 748566)	0 LF
(F)	12" SOLID WHITE RETROREFLECTIVE PREFORMED PATTERNED MARKING (TAPE) (ITEM 748513)	0 LF
(G)	3" PERMANENT PAVEMENT STRIPING, EPOXY RESIN PAINT, BLACK (ITEM 748557)	0 LF
(H)	5" PERMANENT PAVEMENT STRIPING, EPOXY RESIN PAINT, WHITE, 10' LINE 30' GAP (ITEM 748548)	0 LF
(I)	RETROREFLECTIVE PREFORMED PATTERNED MARKING SYMBOL/LEGEND (ITEM 748529)	0 LF
(J)	10" PERMANENT PAVEMENT STRIPING, EPOXY RESIN PAINT, WHITE, 2' LINE & 6' GAP (ITEM 748548)	0 LF
(K)	10" PERMANENT PAVEMENT STRIPING, EPOXY RESIN PAINT, WHITE (ITEM 748549)	0 LF
(L)	10" PERMANENT PAVEMENT STRIPING, EPOXY RESIN PAINT, WHITE, 2' LINE & 2' GAP (ITEM 748549)	0 LF
(M)	5" PERMANENT PAVEMENT STRIPING, EPOXY RESIN PAINT, WHITE, 2' LINE & 6' GAP (ITEM 748548)	0 LF
(N)	5" PERMANENT PAVEMENT STRIPING, EPOXY RESIN PAINT, DOUBLE YELLOW (ITEM 748548)	0 LF
(O)	12" PERMANENT PAVEMENT STRIPING, EPOXY RESIN PAINT, YELLOW (ITEM 748509)	0 LF
(P)	10" REFLECTIVE PREFORMED PATTERNED CONTRAST MARKINGS, 2' LINE & 6' GAP (ITEM 748565)	0 LF
(R)	5" REFLECTIVE PREFORMED PATTERNED CONTRAST MARKINGS, 2' LINE & 6' GAP (ITEM 748564)	0 LF
(S)	5" PERMANENT PAVEMENT STRIPING, EPOXY RESIN PAINT, YELLOW, 10' LINE 30' GAP (ITEM 748548)	0 LF

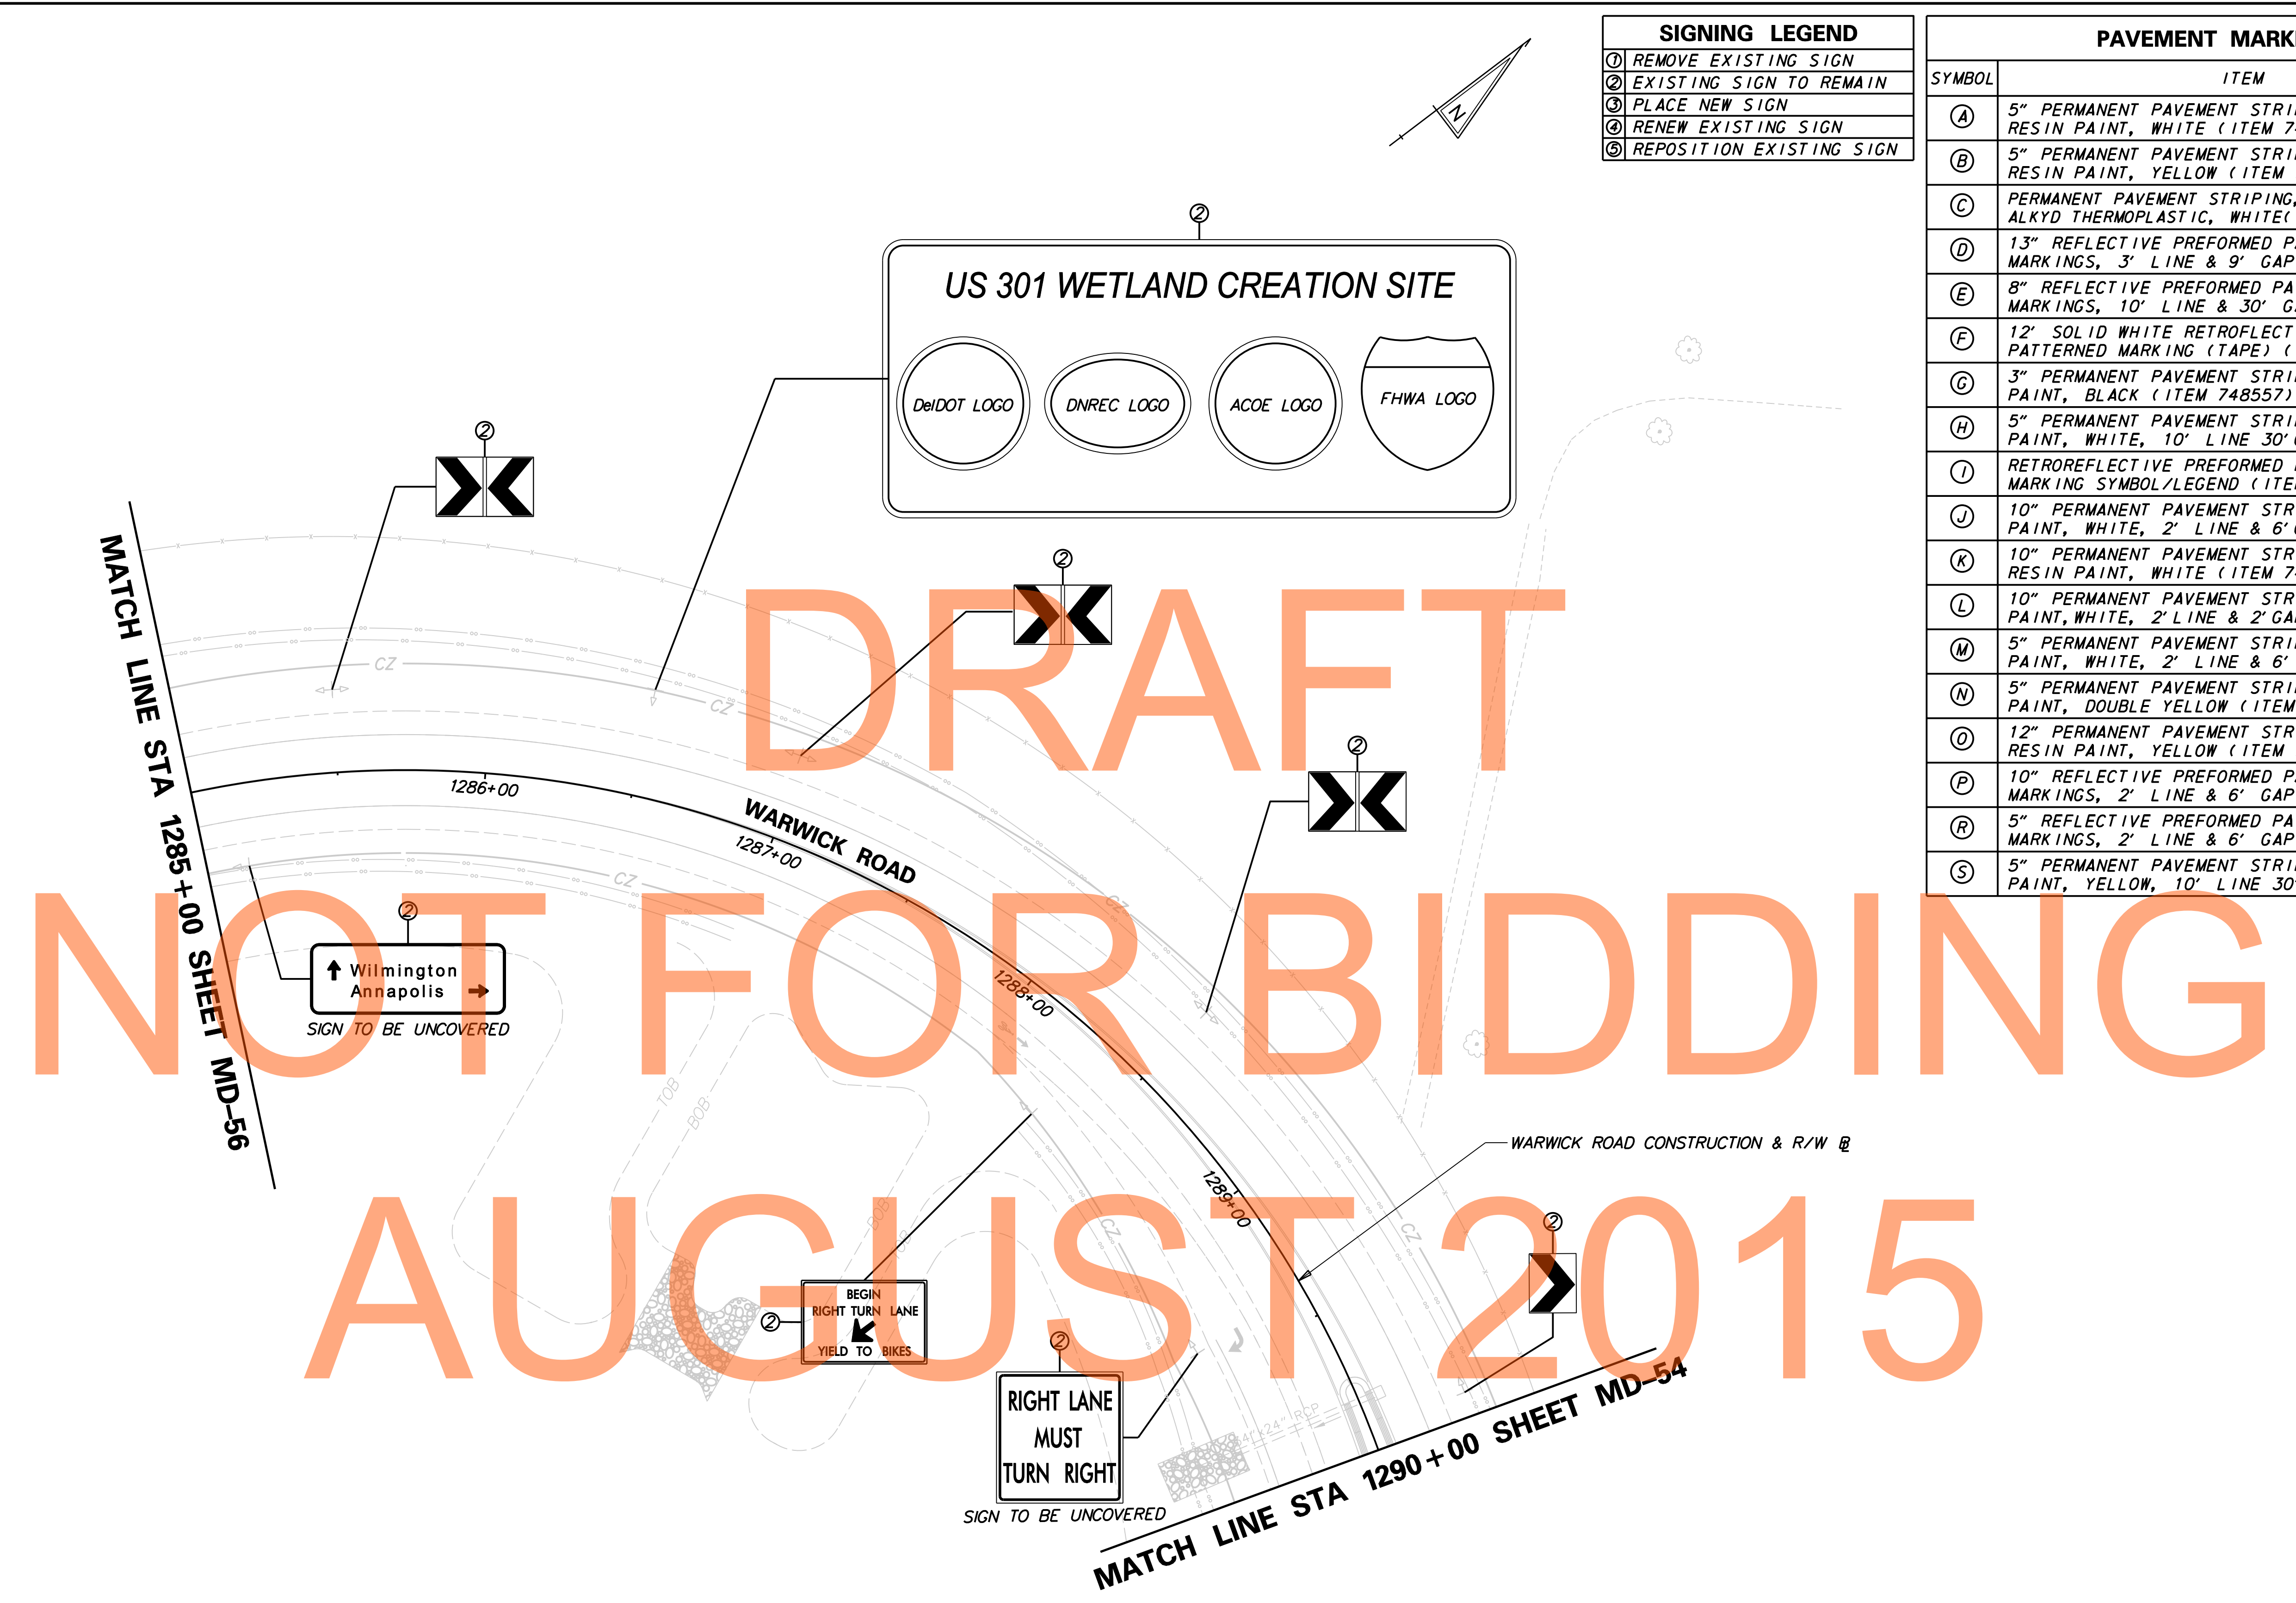

J:\2008 PROJECTS\E3\34801\700CADD\750AET\DESIGN SECTION 2 PLANS\MD_301AETDS2_057.DGN

DELAWARE DEPARTMENT OF TRANSPORTATION

ADDENDUMS / REVISIONS	

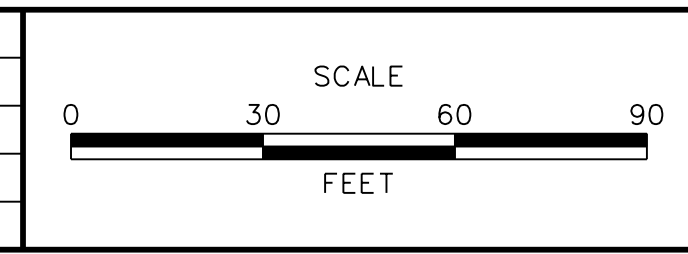

US 301 MARYLAND STATE LINE TO LEVELS ROAD


CONTRACT	BRIDGE NO.
T200911303	
COUNTY	DESIGNED BY: MGP
NEW CASTLE	CHECKED BY: SKH

SIGNING, STRIPING & CONDUIT PLAN











MD-57
SHEET NO.
1169
TOTAL SHTS.
1256

PAVEMENT MARKINGS LEGEND		
SYMBOL	ITEM	QUANTITY
(A)	5" PERMANENT PAVEMENT STRIPING, EPOXY RESIN PAINT, WHITE (ITEM 748548)	0 LF
(B)	5" PERMANENT PAVEMENT STRIPING, EPOXY RESIN PAINT, YELLOW (ITEM 748548)	0 LF
(C)	PERMANENT PAVEMENT STRIPING, SYMBOL/LEGEND, ALKYD THERMOPLASTIC, WHITE (ITEM 748015)	0 SF
(D)	13" REFLECTIVE PREFORMED PATTERNED CONTRAST MARKINGS, 3' LINE & 9' GAP (ITEM 748567)	0 LF
(E)	8" REFLECTIVE PREFORMED PATTERNED CONTRAST MARKINGS, 10' LINE & 30' GAP (ITEM 748566)	0 LF
(F)	12" SOLID WHITE RETROFLECTIVE PREFORMED PATTERNED MARKING (TAPE) (ITEM 748513)	0 LF
(G)	3" PERMANENT PAVEMENT STRIPING, EPOXY RESIN PAINT, BLACK (ITEM 748557)	0 LF
(H)	5" PERMANENT PAVEMENT STRIPING, EPOXY RESIN PAINT, WHITE, 10' LINE 30' GAP (ITEM 748548)	0 LF
(I)	RETROFLECTIVE PREFORMED PATTERNED MARKING SYMBOL/LEGEND (ITEM 748529)	0 SF
(J)	10" PERMANENT PAVEMENT STRIPING, EPOXY RESIN PAINT, WHITE, 2' LINE & 6' GAP (ITEM 748548)	0 LF
(K)	10" PERMANENT PAVEMENT STRIPING, EPOXY RESIN PAINT, WHITE (ITEM 748549)	0 LF
(L)	10" PERMANENT PAVEMENT STRIPING, EPOXY RESIN PAINT, WHITE, 2' LINE & 2' GAP (ITEM 748549)	0 LF
(M)	5" PERMANENT PAVEMENT STRIPING, EPOXY RESIN PAINT, WHITE, 2' LINE & 6' GAP (ITEM 748548)	0 LF
(N)	5" PERMANENT PAVEMENT STRIPING, EPOXY RESIN PAINT, DOUBLE YELLOW (ITEM 748548)	0 LF
(O)	12" PERMANENT PAVEMENT STRIPING, EPOXY RESIN PAINT, YELLOW (ITEM 748509)	0 LF
(P)	10" REFLECTIVE PREFORMED PATTERNED CONTRAST MARKINGS, 2' LINE & 6' GAP (ITEM 748565)	0 LF
(R)	5" REFLECTIVE PREFORMED PATTERNED CONTRAST MARKINGS, 2' LINE & 6' GAP (ITEM 748564)	0 LF
(S)	5" PERMANENT PAVEMENT STRIPING, EPOXY RESIN PAINT, YELLOW, 10' LINE 30' GAP (ITEM 748548)	0 LF

SIGNING LEGEND	
①	REMOVE EXISTING SIGN
②	EXISTING SIGN TO REMAIN
③	PLACE NEW SIGN
④	RENEW EXISTING SIGN
⑤	REPOSITION EXISTING SIGN

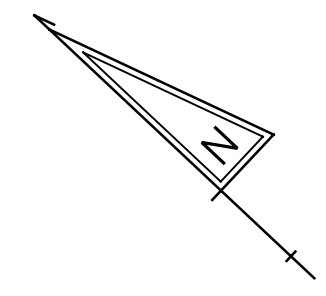


DRAFT
NOT FOR BIDDING
AUGUST 2015

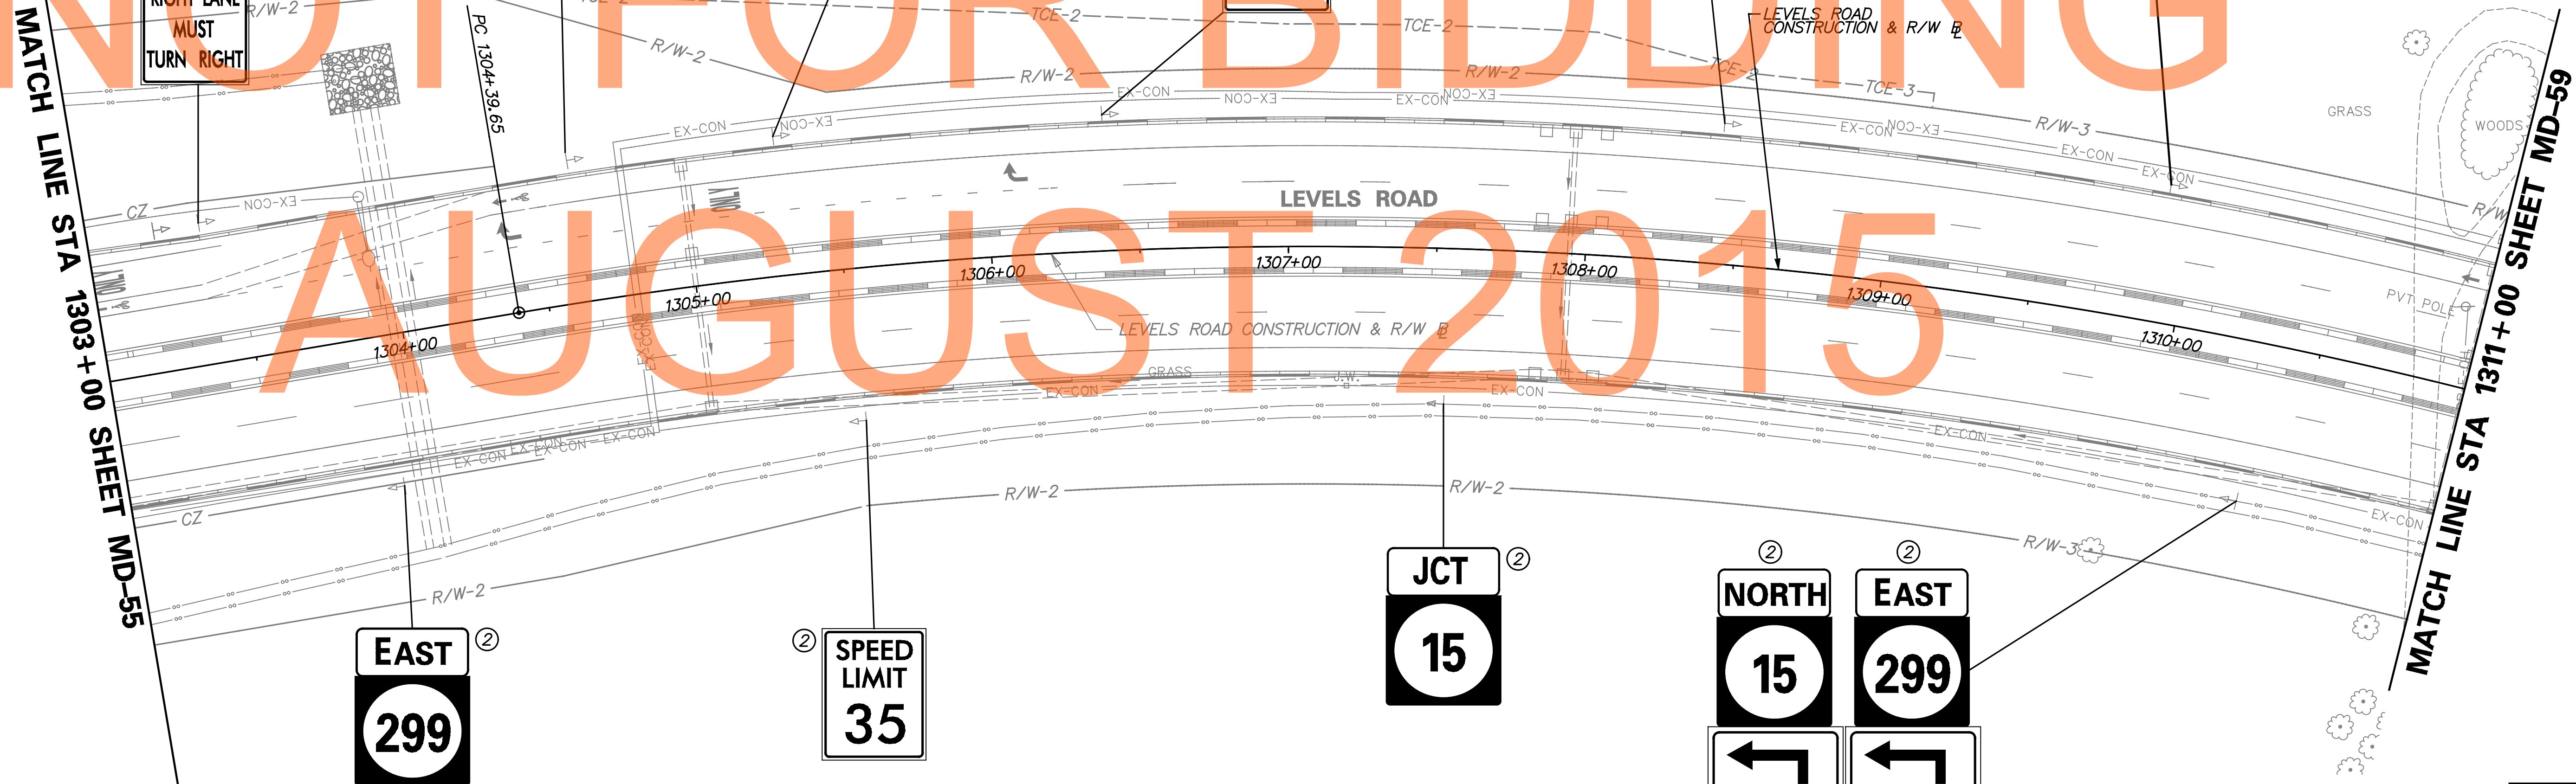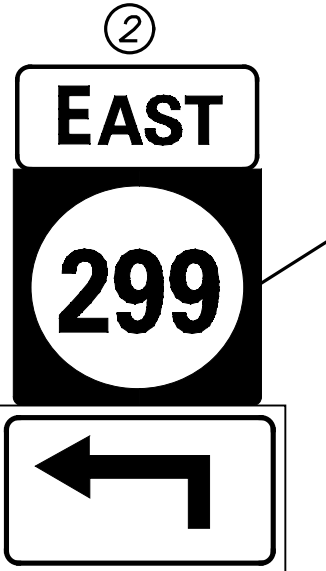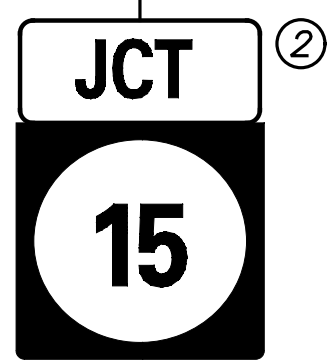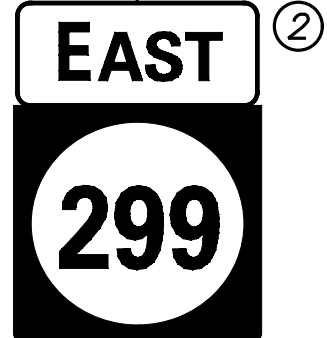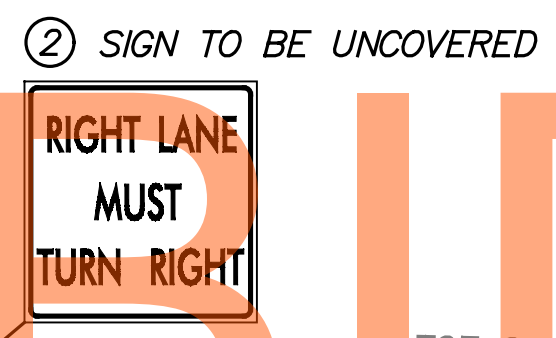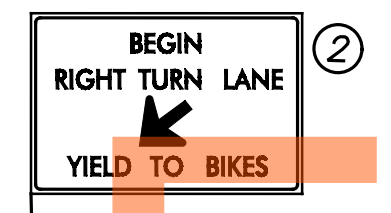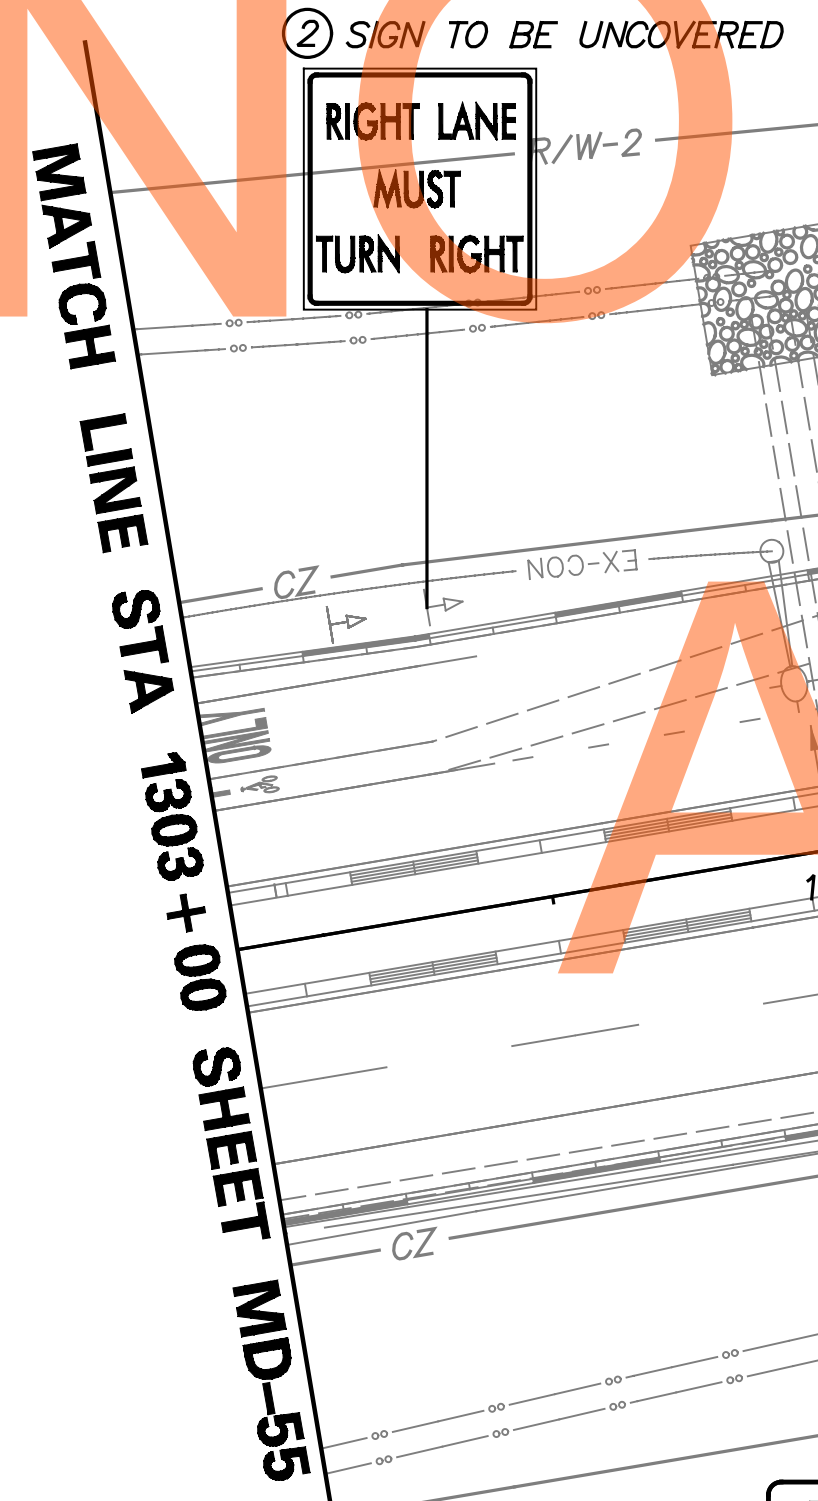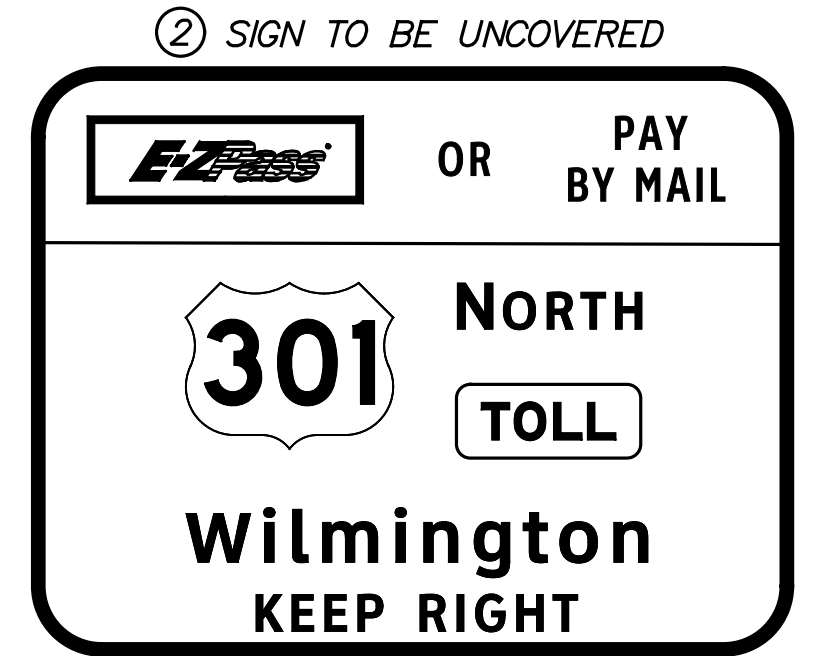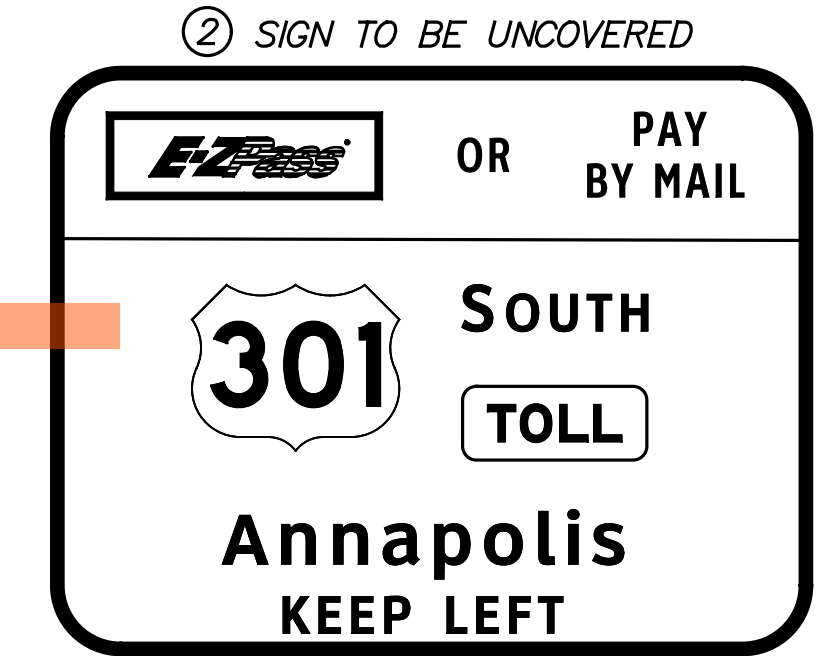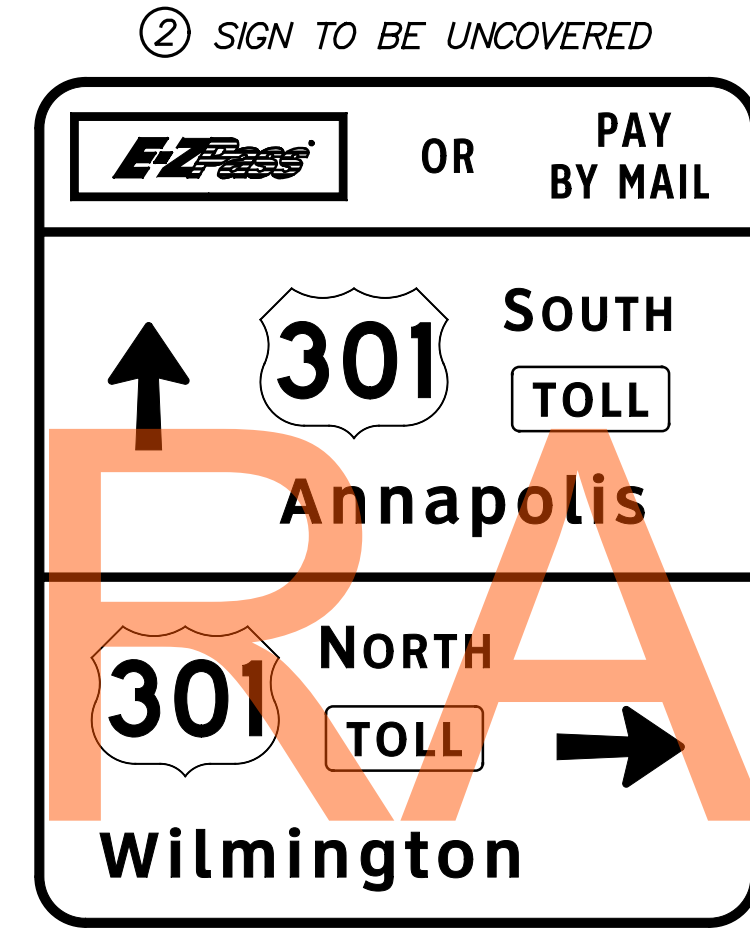

PAVEMENT MARKINGS LEGEND		
SYMBOL	ITEM	QUANTITY
(A)	5" PERMANENT PAVEMENT STRIPING, EPOXY RESIN PAINT, WHITE (ITEM 748548)	0 LF
(B)	5" PERMANENT PAVEMENT STRIPING, EPOXY RESIN PAINT, YELLOW (ITEM 748548)	0 LF
(C)	PERMANENT PAVEMENT STRIPING, SYMBOL/LEGEND, ALKYD THERMOPLASTIC, WHITE (ITEM 748015)	0 SF
(D)	13" REFLECTIVE PREFORMED PATTERNED CONTRAST MARKINGS, 3' LINE & 9' GAP (ITEM 748567)	0 LF
(E)	8" REFLECTIVE PREFORMED PATTERNED CONTRAST MARKINGS, 10' LINE & 30' GAP (ITEM 748566)	0 LF
(F)	12' SOLID WHITE RETROFLECTIVE PREFORMED PATTERNED MARKING (TAPE) (ITEM 748513)	0 LF
(G)	3" PERMANENT PAVEMENT STRIPING, EPOXY RESIN PAINT, BLACK (ITEM 748557)	0 LF
(H)	5" PERMANENT PAVEMENT STRIPING, EPOXY RESIN PAINT, WHITE, 10' LINE 30' GAP (ITEM 748548)	0 LF
(I)	RETROFLECTIVE PREFORMED PATTERNED MARKING SYMBOL/LEGEND (ITEM 748529)	0 SF
(J)	10" PERMANENT PAVEMENT STRIPING, EPOXY RESIN PAINT, WHITE, 2' LINE & 6' GAP (ITEM 748548)	0 LF
(K)	10" PERMANENT PAVEMENT STRIPING, EPOXY RESIN PAINT, WHITE (ITEM 748549)	0 LF
(L)	10" PERMANENT PAVEMENT STRIPING, EPOXY RESIN PAINT, WHITE, 2' LINE & 2' GAP (ITEM 748549)	0 LF
(M)	5" PERMANENT PAVEMENT STRIPING, EPOXY RESIN PAINT, WHITE, 2' LINE & 6' GAP (ITEM 748548)	0 LF
(N)	5" PERMANENT PAVEMENT STRIPING, EPOXY RESIN PAINT, DOUBLE YELLOW (ITEM 748548)	0 LF
(O)	12" PERMANENT PAVEMENT STRIPING, EPOXY RESIN PAINT, YELLOW (ITEM 748509)	0 LF
(P)	10" REFLECTIVE PREFORMED PATTERNED CONTRAST MARKINGS, 2' LINE & 6' GAP (ITEM 748565)	0 LF
(R)	5" REFLECTIVE PREFORMED PATTERNED CONTRAST MARKINGS, 2' LINE & 6' GAP (ITEM 748564)	0 LF
(S)	5" PERMANENT PAVEMENT STRIPING, EPOXY RESIN PAINT, YELLOW, 10' LINE 30' GAP (ITEM 748548)	0 LF

SIGNING LEGEND	
①	REMOVE EXISTING SIGN
②	EXISTING SIGN TO REMAIN
③	PLACE NEW SIGN
④	RENEW EXISTING SIGN
⑤	REPOSITION EXISTING SIGN

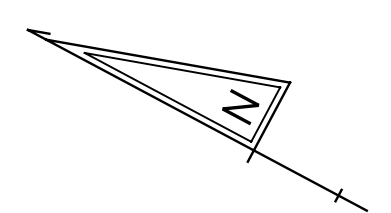

MATCH LINE STA 741+00 SHEET MD-62


DRAFT

NOT FOR BIDDING

AUGUST 2015

MATCH LINE STA 1311+00 SHEET MD-58

MATCH LINE STA 662+00 SHEET MD-60

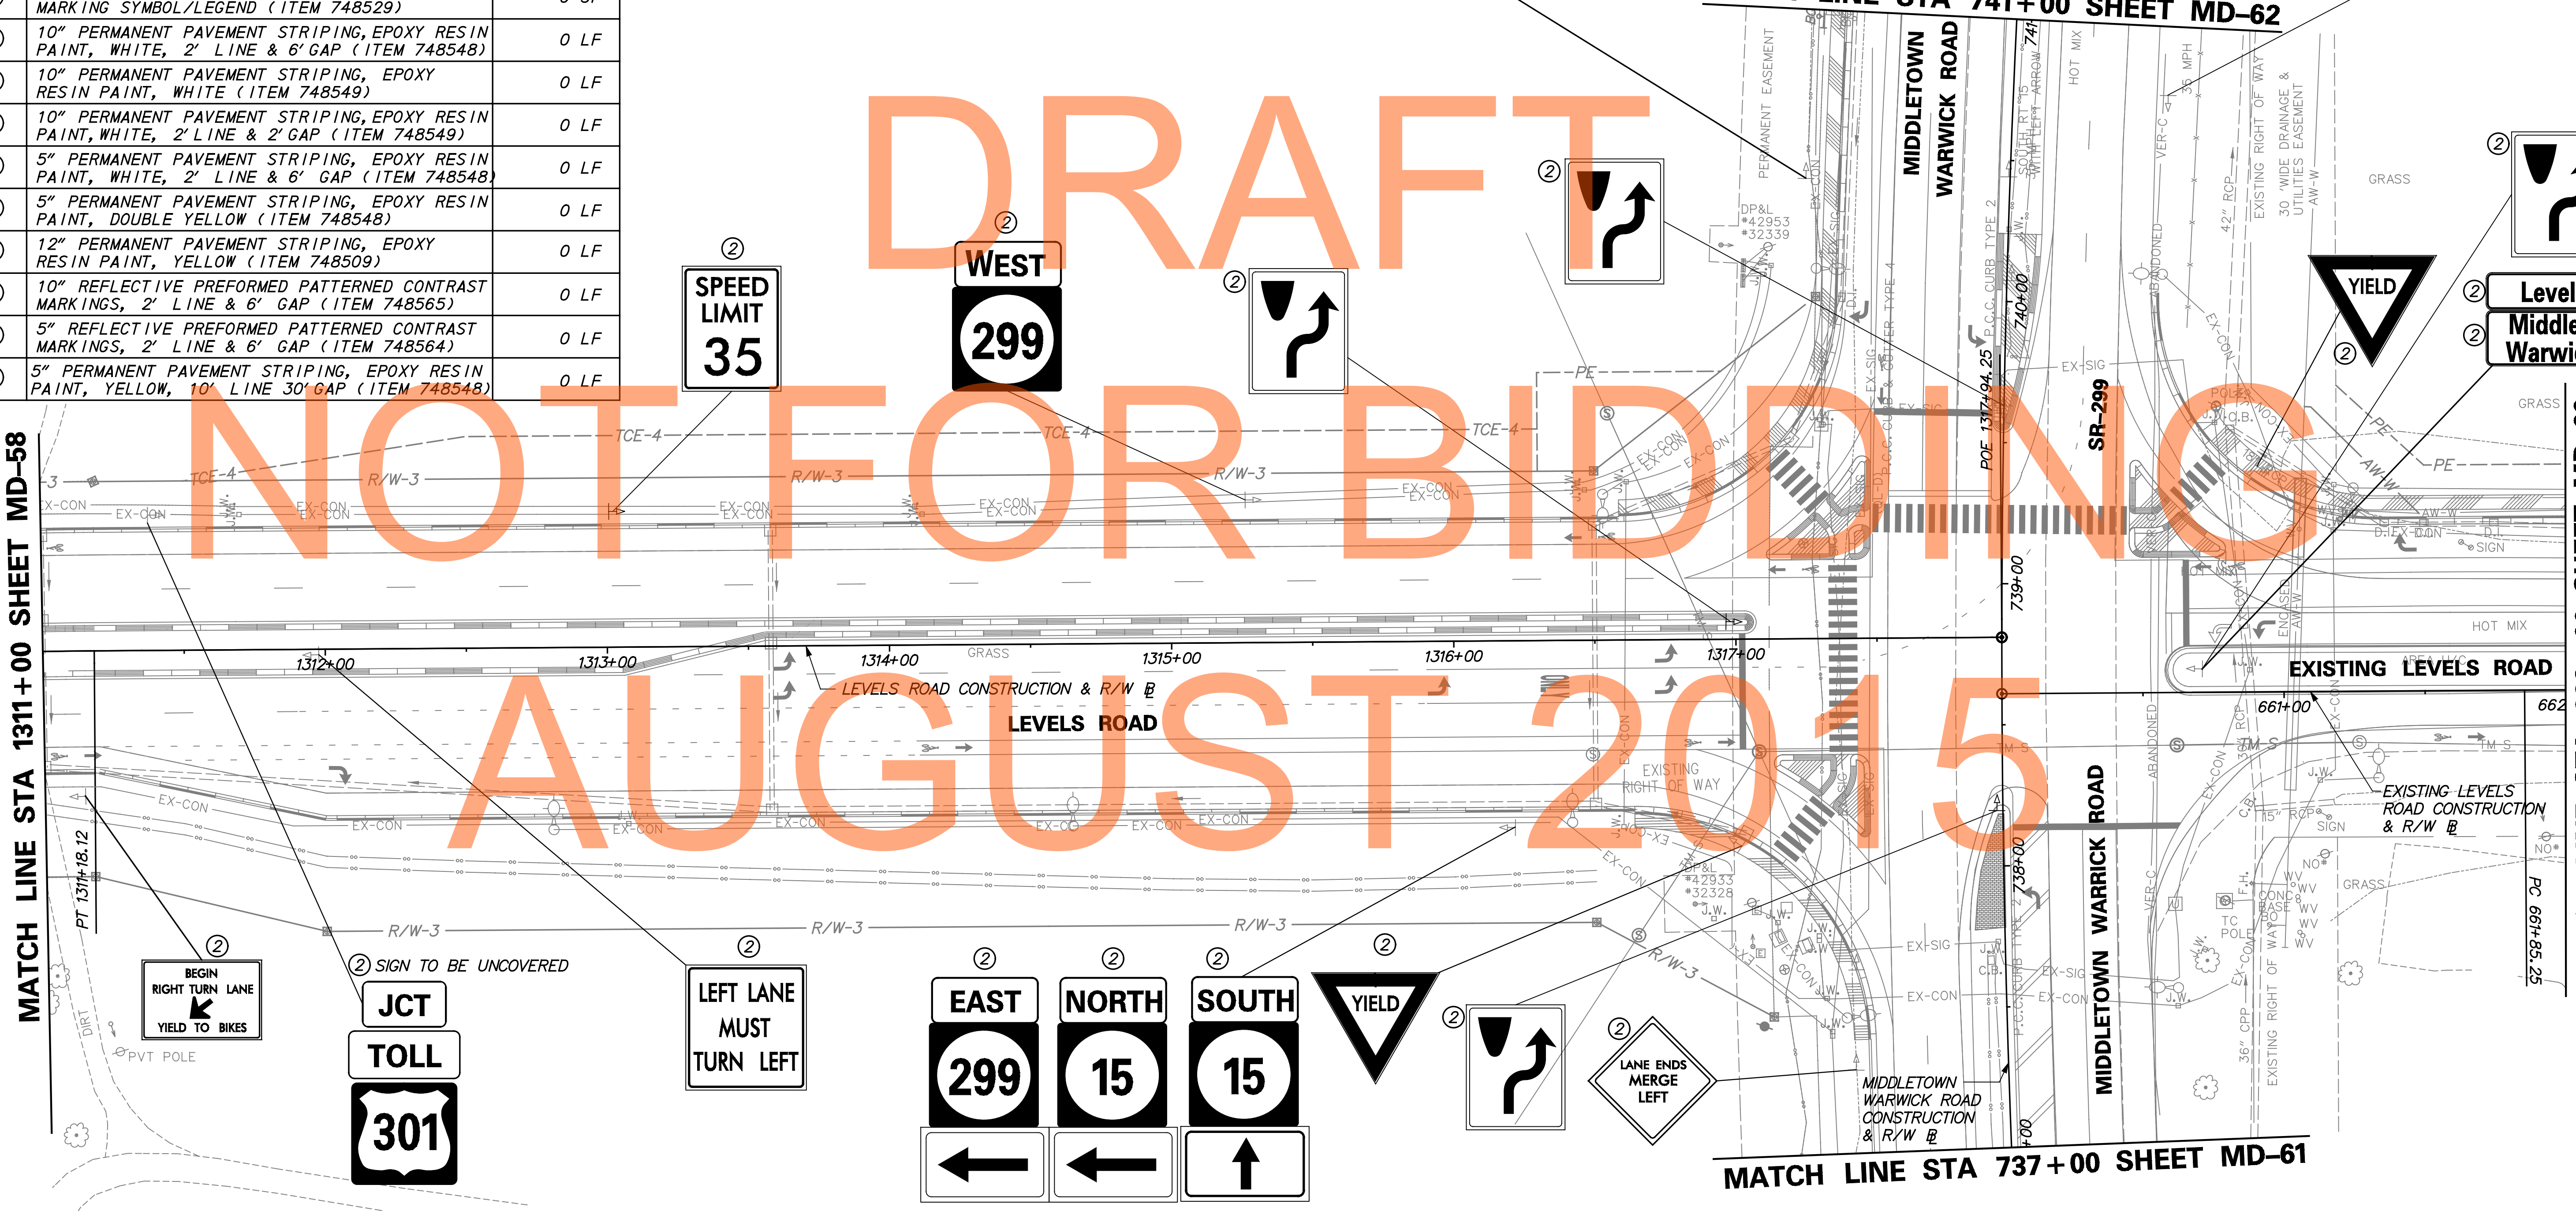


MATCH LINE STA 737+00 SHEET MD-61


PAVEMENT MARKINGS LEGEND		
SYMBOL	ITEM	QUANTITY
(A)	5" PERMANENT PAVEMENT STRIPING, EPOXY RESIN PAINT, WHITE (ITEM 748548)	0 LF
(B)	5" PERMANENT PAVEMENT STRIPING, EPOXY RESIN PAINT, YELLOW (ITEM 748548)	0 LF
(C)	PERMANENT PAVEMENT STRIPING, SYMBOL/LEGEND, ALKYD THERMOPLASTIC, WHITE (ITEM 748015)	0 SF
(D)	13" REFLECTIVE PREFORMED PATTERNED CONTRAST MARKINGS, 3' LINE & 9' GAP (ITEM 748567)	0 LF
(E)	8" REFLECTIVE PREFORMED PATTERNED CONTRAST MARKINGS, 10' LINE & 30' GAP (ITEM 748566)	0 LF
(F)	12' SOLID WHITE RETROREFLECTIVE PREFORMED PATTERNED MARKING (TAPE) (ITEM 748513)	0 LF
(G)	3" PERMANENT PAVEMENT STRIPING, EPOXY RESIN PAINT, BLACK (ITEM 748557)	0 LF
(H)	5" PERMANENT PAVEMENT STRIPING, EPOXY RESIN PAINT, WHITE, 10' LINE 30' GAP (ITEM 748548)	0 LF
(I)	RETROREFLECTIVE PREFORMED PATTERNED MARKING SYMBOL/LEGEND (ITEM 748529)	0 SF

PAVEMENT MARKINGS LEGEND		
SYMBOL	ITEM	QUANTITY
(J)	10" PERMANENT PAVEMENT STRIPING, EPOXY RESIN PAINT, WHITE, 2' LINE & 6' GAP (ITEM 748548)	0 LF
(K)	10" PERMANENT PAVEMENT STRIPING, EPOXY RESIN PAINT, WHITE (ITEM 748549)	0 LF
(L)	10" PERMANENT PAVEMENT STRIPING, EPOXY RESIN PAINT, WHITE, 2' LINE & 2' GAP (ITEM 748549)	0 LF
(M)	5" PERMANENT PAVEMENT STRIPING, EPOXY RESIN PAINT, WHITE, 2' LINE & 6' GAP (ITEM 748548)	0 LF
(N)	5" PERMANENT PAVEMENT STRIPING, EPOXY RESIN PAINT, DOUBLE YELLOW (ITEM 748548)	0 LF
(O)	12" PERMANENT PAVEMENT STRIPING, EPOXY RESIN PAINT, YELLOW (ITEM 748509)	0 LF
(P)	10" REFLECTIVE PREFORMED PATTERNED CONTRAST MARKINGS, 2' LINE & 6' GAP (ITEM 748565)	0 LF
(R)	5" REFLECTIVE PREFORMED PATTERNED CONTRAST MARKINGS, 2' LINE & 6' GAP (ITEM 748564)	0 LF
(S)	5" PERMANENT PAVEMENT STRIPING, EPOXY RESIN PAINT, YELLOW, 10' LINE 30' GAP (ITEM 748548)	0 LF

SIGNING LEGEND	
①	REMOVE EXISTING SIGN
②	EXISTING SIGN TO REMAIN
③	PLACE NEW SIGN
④	RENEW EXISTING SIGN
⑤	REPOSITION EXISTING SIGN

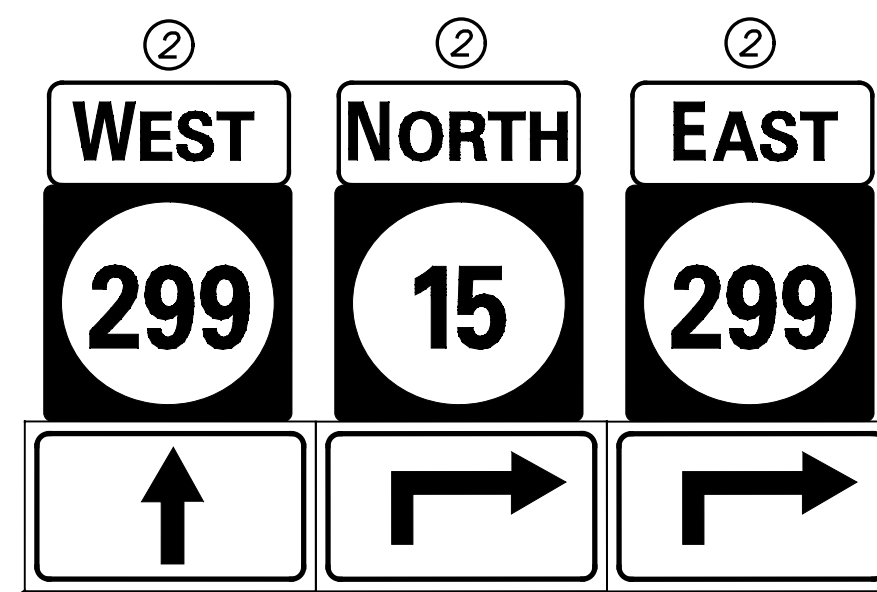





MATCH LINE STA 662+00 SHEET MD-59

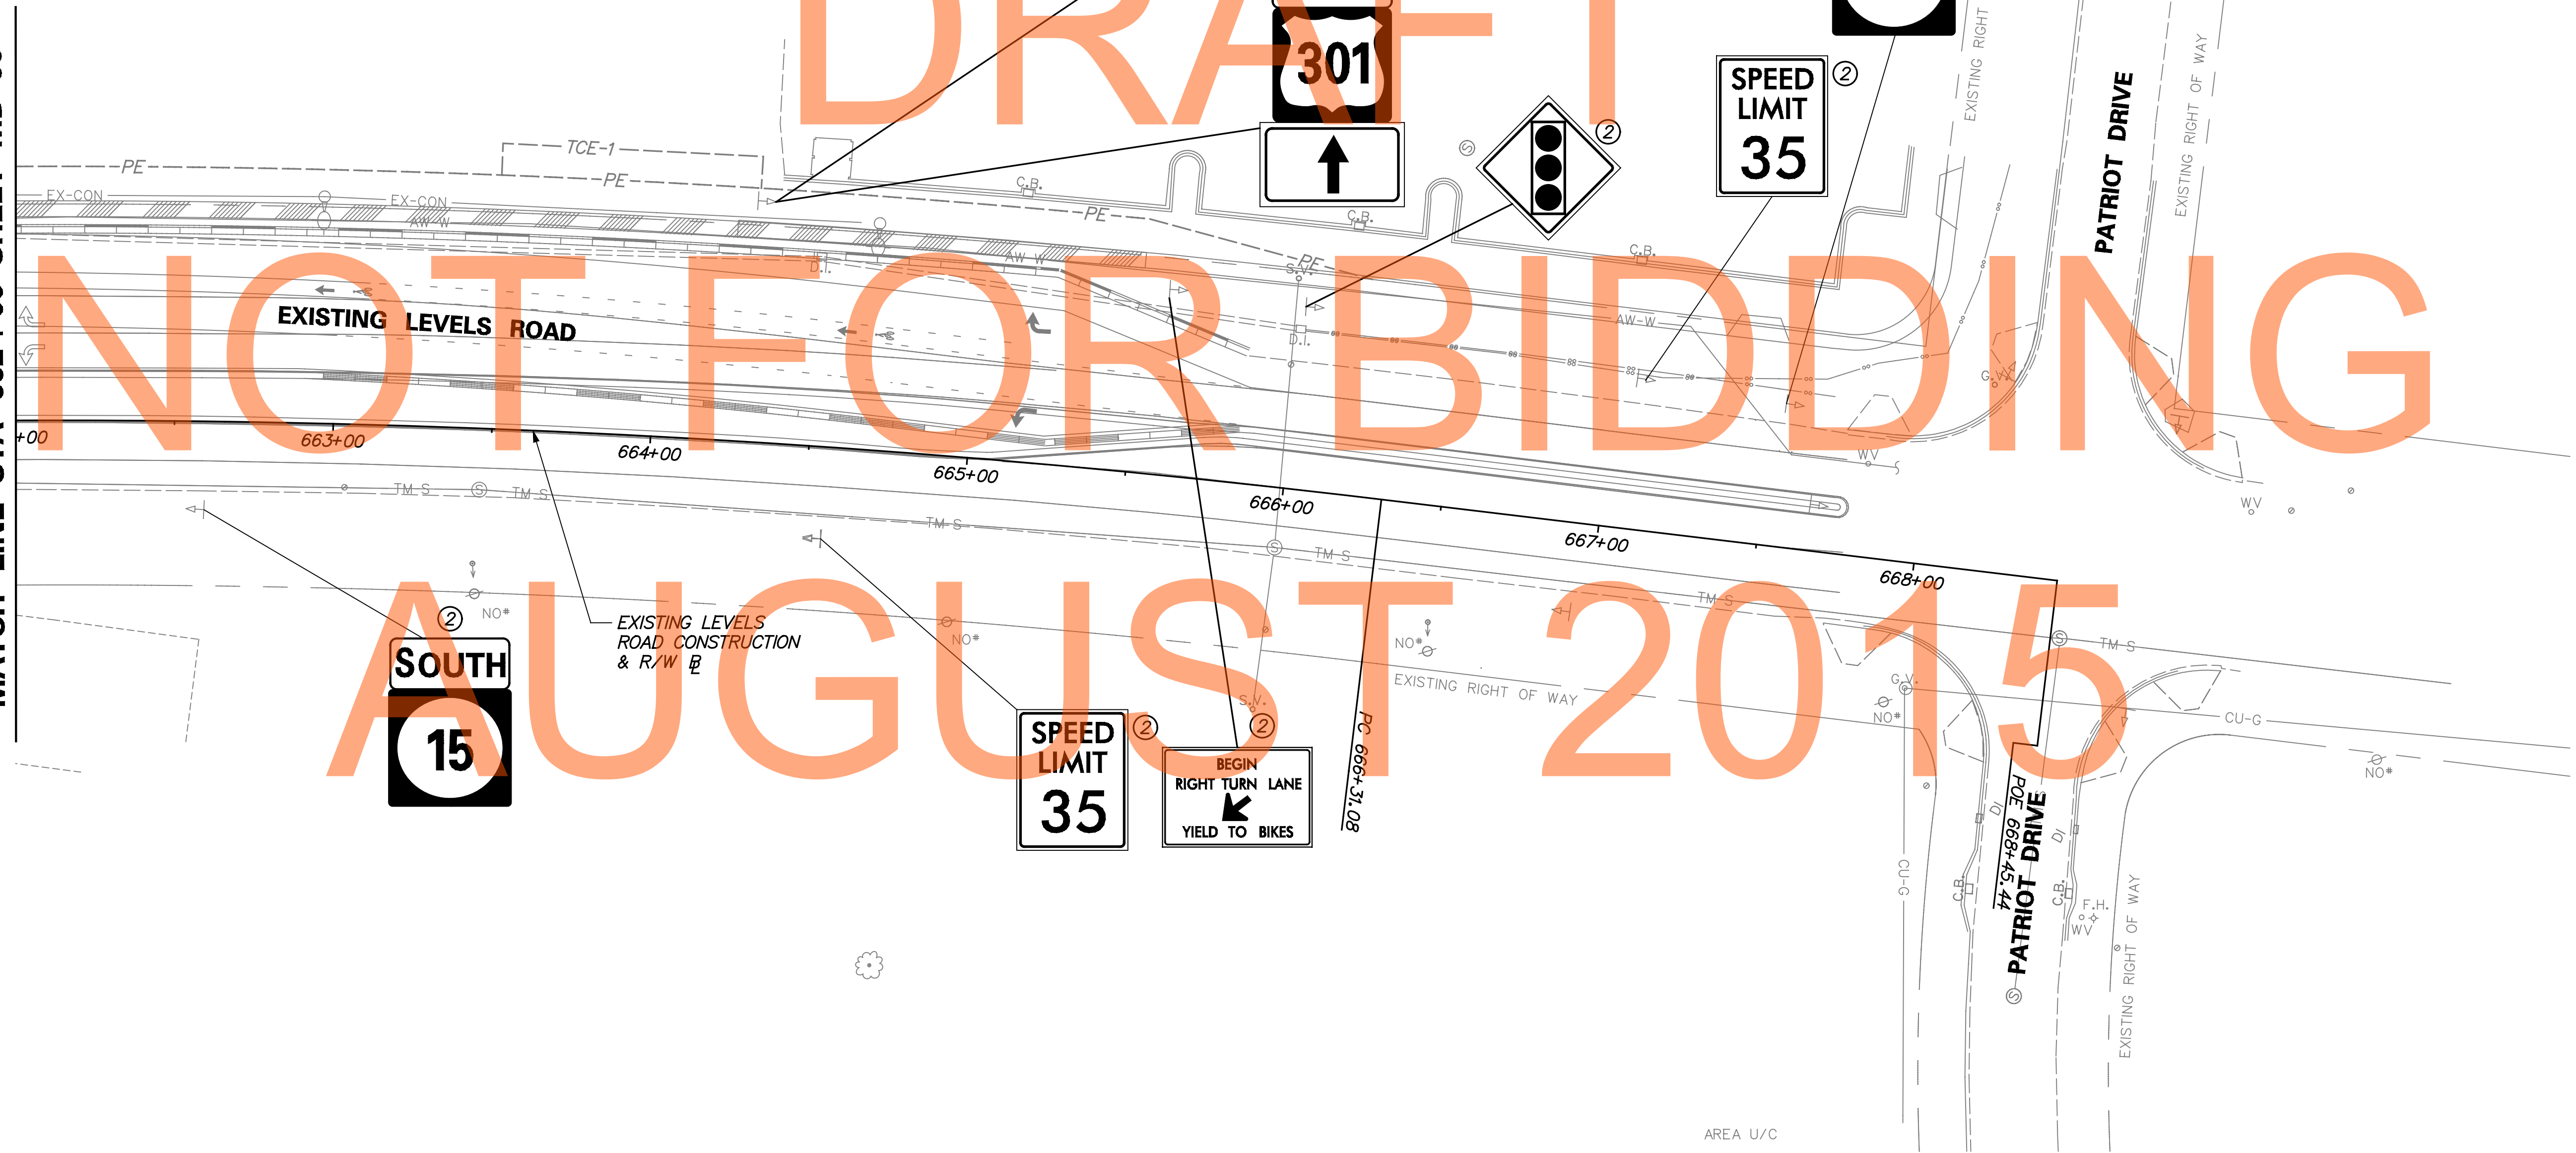





PAVEMENT MARKINGS LEGEND		
SYMBOL	ITEM	QUANTITY
(A)	5" PERMANENT PAVEMENT STRIPING, EPOXY RESIN PAINT, WHITE (ITEM 748548)	0 LF
(B)	5" PERMANENT PAVEMENT STRIPING, EPOXY RESIN PAINT, YELLOW (ITEM 748548)	0 LF
(C)	PERMANENT PAVEMENT STRIPING, SYMBOL/LEGEND, ALKYD THERMOPLASTIC, WHITE (ITEM 748015)	0 SF
(D)	13" REFLECTIVE PREFORMED PATTERNED CONTRAST MARKINGS, 3' LINE & 9' GAP (ITEM 748567)	0 LF
(E)	8" REFLECTIVE PREFORMED PATTERNED CONTRAST MARKINGS, 10' LINE & 30' GAP (ITEM 748566)	0 LF
(F)	12" SOLID WHITE RETROREFLECTIVE PREFORMED PATTERNED MARKING (TAPE) (ITEM 748513)	0 LF
(G)	3" PERMANENT PAVEMENT STRIPING, EPOXY RESIN PAINT, BLACK (ITEM 748557)	0 LF
(H)	5" PERMANENT PAVEMENT STRIPING, EPOXY RESIN PAINT, WHITE, 10' LINE 30' GAP (ITEM 748548)	0 LF
(I)	RETROREFLECTIVE PREFORMED PATTERNED MARKING SYMBOL/LEGEND (ITEM 748529)	0 SF
(J)	10" PERMANENT PAVEMENT STRIPING, EPOXY RESIN PAINT, WHITE, 2' LINE & 6' GAP (ITEM 748548)	0 LF
(K)	10" PERMANENT PAVEMENT STRIPING, EPOXY RESIN PAINT, WHITE (ITEM 748549)	0 LF
(L)	10" PERMANENT PAVEMENT STRIPING, EPOXY RESIN PAINT, WHITE, 2' LINE & 2' GAP (ITEM 748549)	0 LF
(M)	5" PERMANENT PAVEMENT STRIPING, EPOXY RESIN PAINT, WHITE, 2' LINE & 6' GAP (ITEM 748548)	0 LF
(N)	5" PERMANENT PAVEMENT STRIPING, EPOXY RESIN PAINT, DOUBLE YELLOW (ITEM 748548)	0 LF
(O)	12" PERMANENT PAVEMENT STRIPING, EPOXY RESIN PAINT, YELLOW (ITEM 748509)	0 LF
(P)	10" REFLECTIVE PREFORMED PATTERNED CONTRAST MARKINGS, 2' LINE & 6' GAP (ITEM 748565)	0 LF
(R)	5" REFLECTIVE PREFORMED PATTERNED CONTRAST MARKINGS, 2' LINE & 6' GAP (ITEM 748564)	0 LF
(S)	5" PERMANENT PAVEMENT STRIPING, EPOXY RESIN PAINT, YELLOW, 10' LINE 30' GAP (ITEM 748548)	0 LF

SIGNING LEGEND	
①	REMOVE EXISTING SIGN
②	EXISTING SIGN TO REMAIN
③	PLACE NEW SIGN
④	RENEW EXISTING SIGN
⑤	REPOSITION EXISTING SIGN

SIGN TO BE UNCOVERED ②

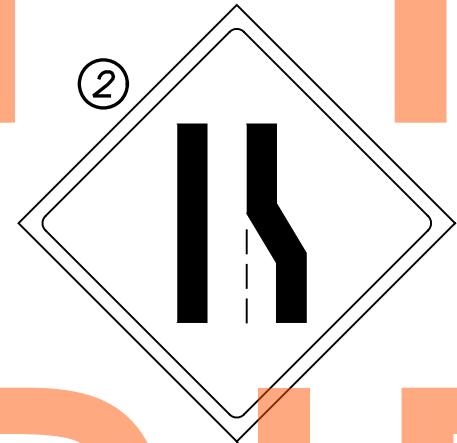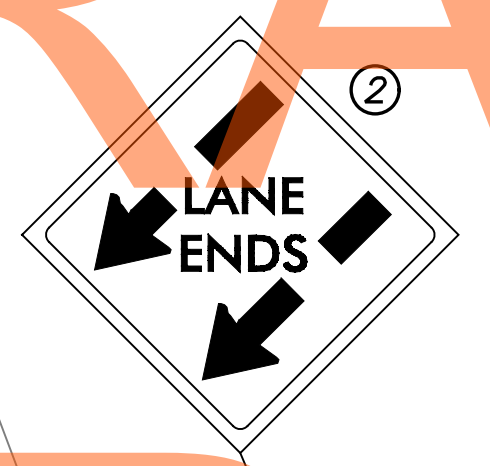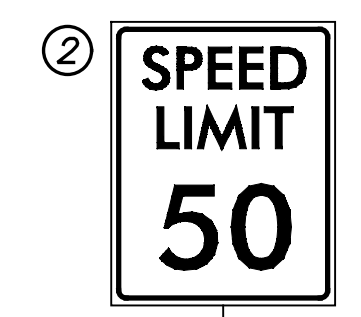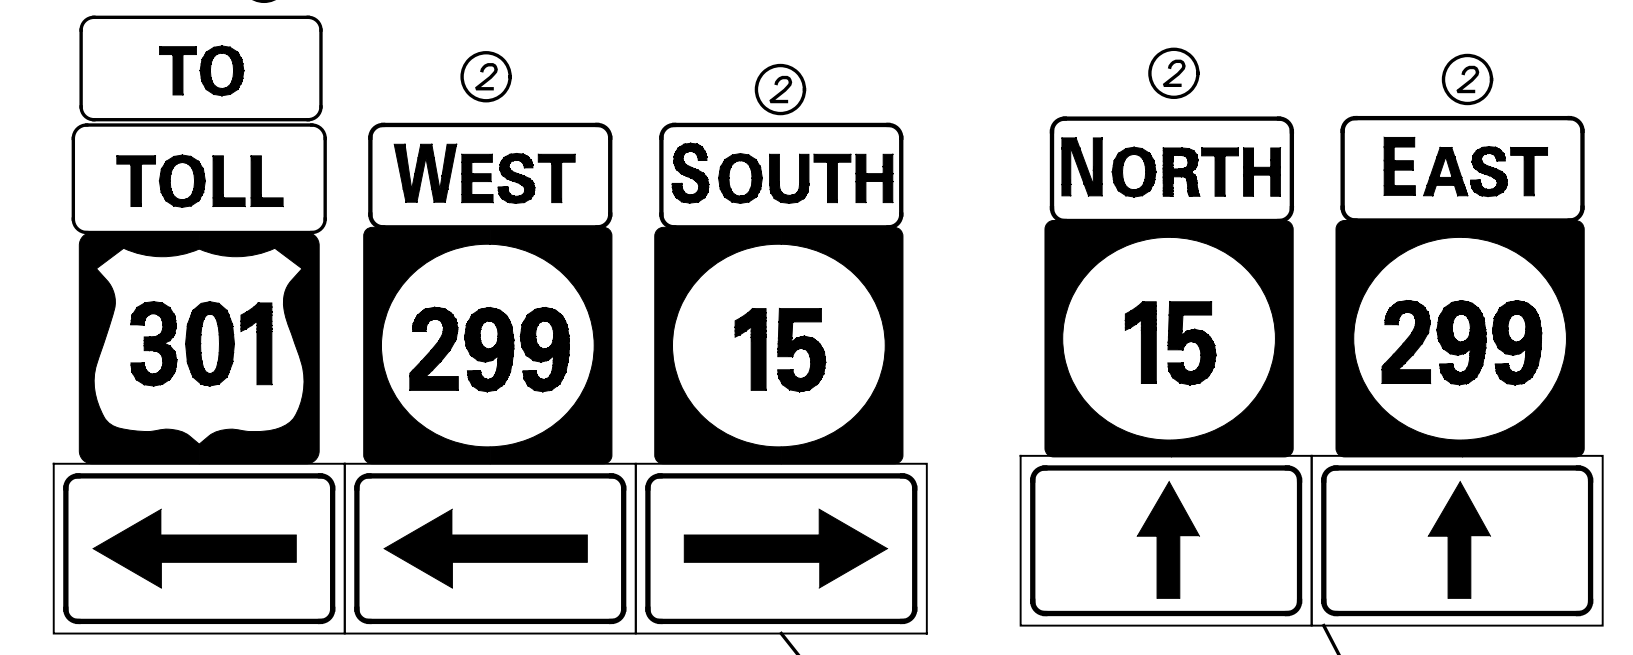

DRAFT
NOT FOR BIDDING
AUGUST 2015

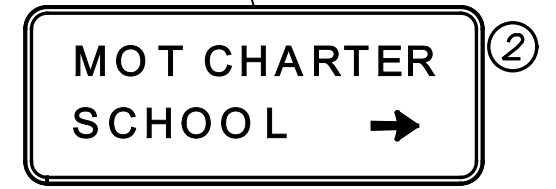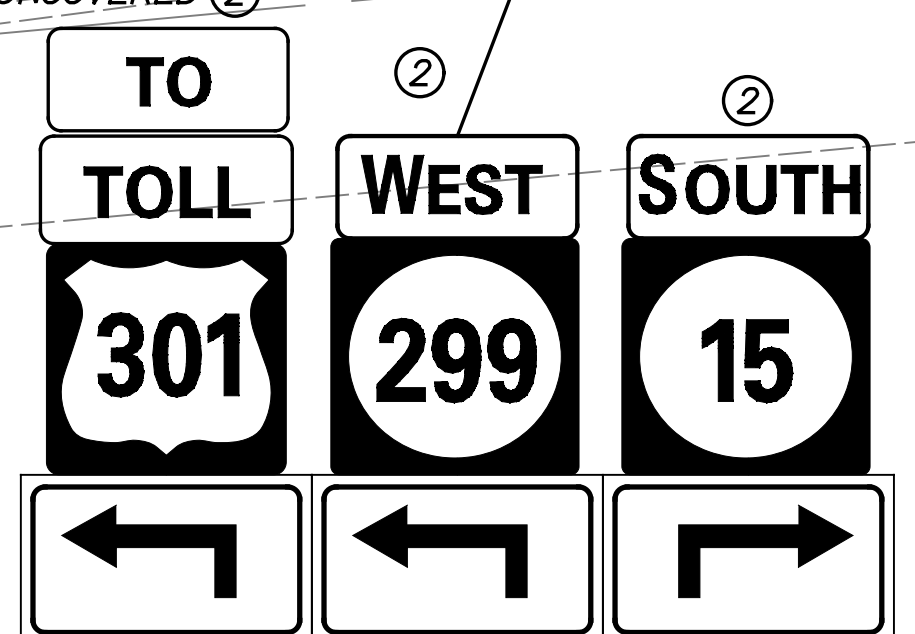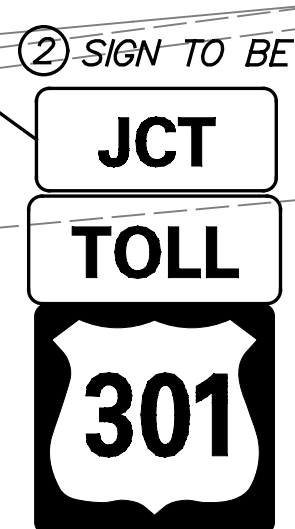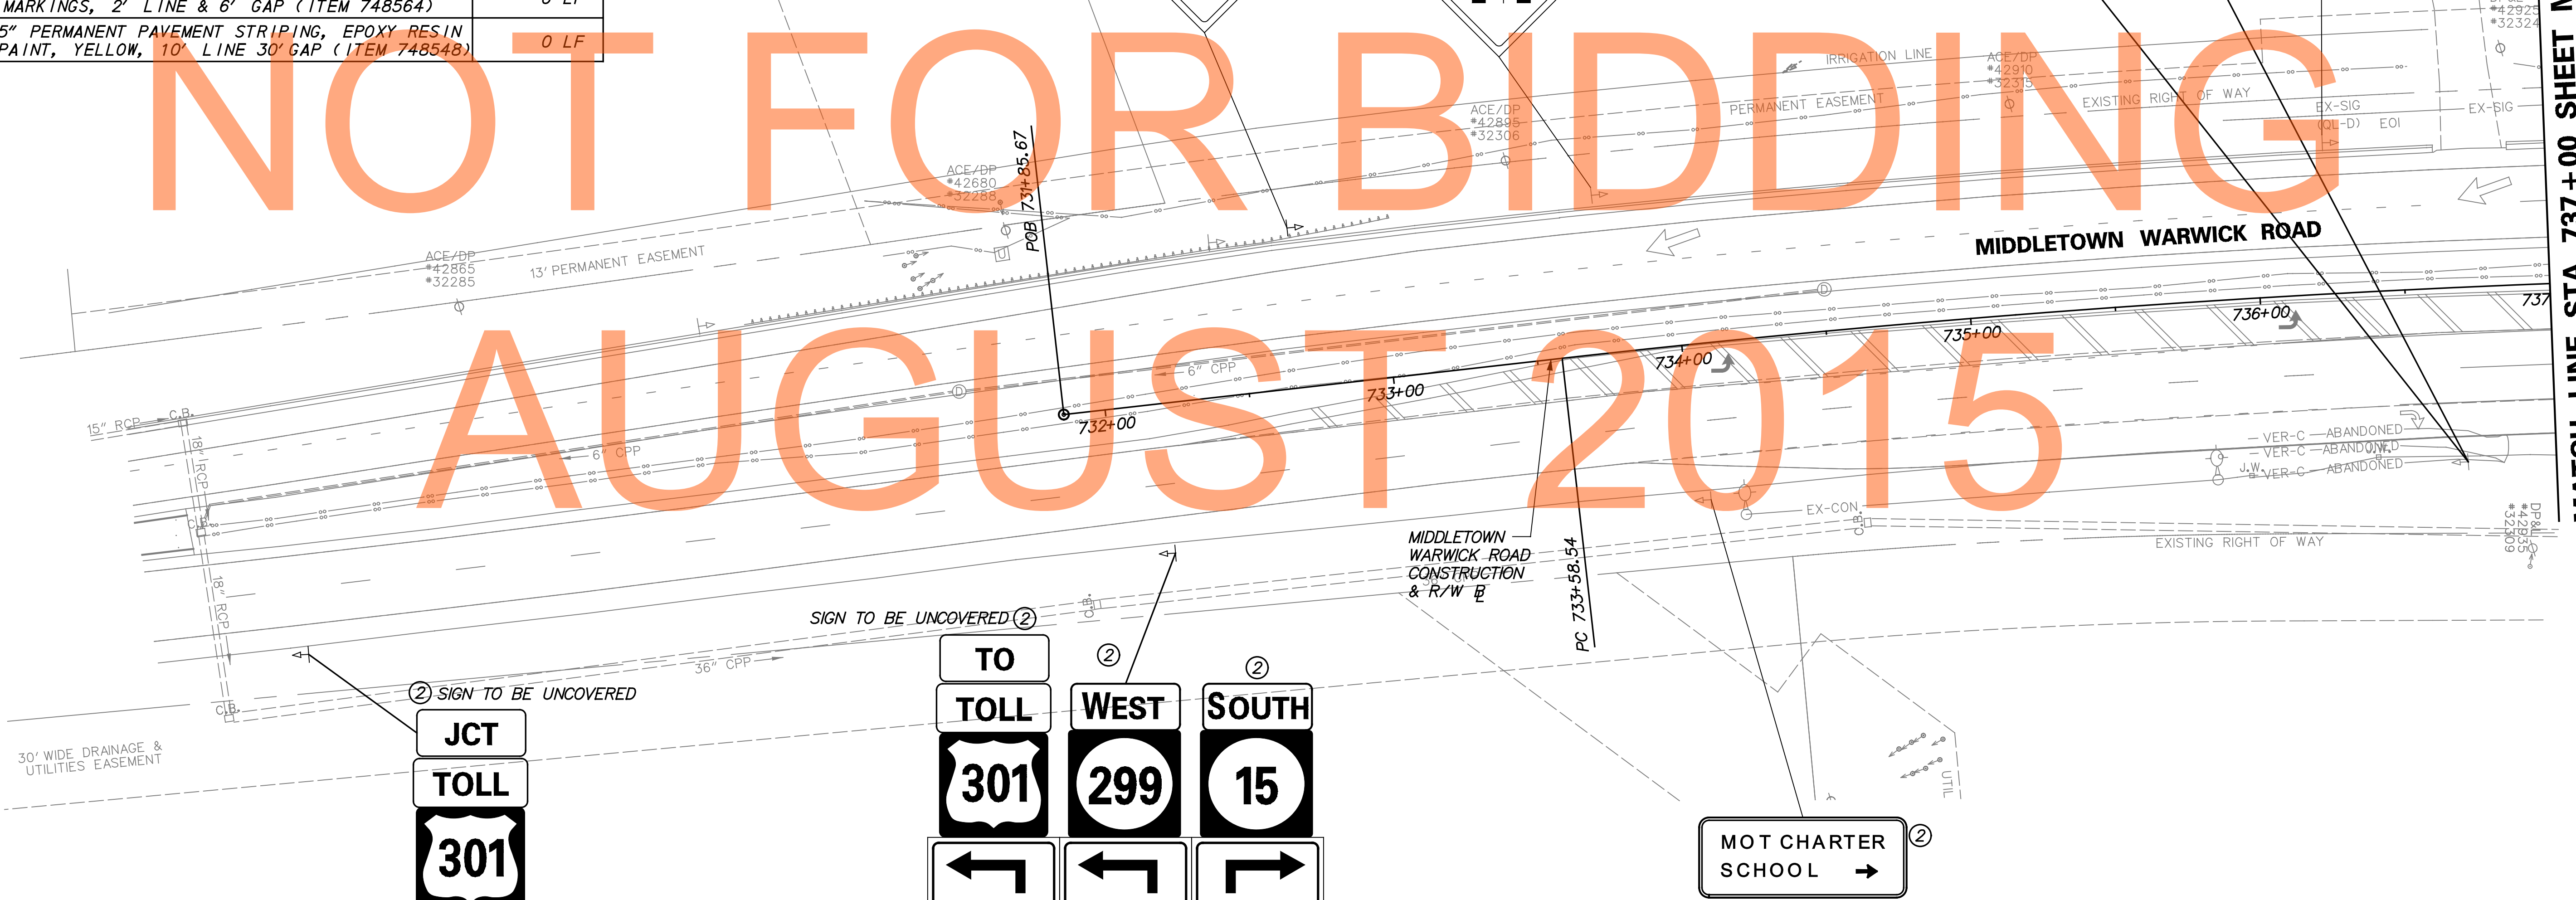


MATCH LINE STA 737+00 SHEET MD-59

PAVEMENT MARKINGS LEGEND		
SYMBOL	ITEM	QUANTITY
(A)	5" PERMANENT PAVEMENT STRIPING, EPOXY RESIN PAINT, WHITE (ITEM 748548)	0 LF
(B)	5" PERMANENT PAVEMENT STRIPING, EPOXY RESIN PAINT, YELLOW (ITEM 748548)	0 LF
(C)	PERMANENT PAVEMENT STRIPING, SYMBOL/LEGEND, ALKYD THERMOPLASTIC, WHITE (ITEM 748015)	0 SF
(D)	13" REFLECTIVE PREFORMED PATTERNED CONTRAST MARKINGS, 3' LINE & 9' GAP (ITEM 748567)	0 LF
(E)	8" REFLECTIVE PREFORMED PATTERNED CONTRAST MARKINGS, 10' LINE & 30' GAP (ITEM 748566)	0 LF
(F)	12" SOLID WHITE RETROREFLECTIVE PREFORMED PATTERNED MARKING (TAPE) (ITEM 748513)	0 LF
(G)	3" PERMANENT PAVEMENT STRIPING, EPOXY RESIN PAINT, BLACK (ITEM 748557)	0 LF
(H)	5" PERMANENT PAVEMENT STRIPING, EPOXY RESIN PAINT, WHITE, 10' LINE 30' GAP (ITEM 748548)	0 LF
(I)	RETROREFLECTIVE PREFORMED PATTERNED MARKING SYMBOL/LEGEND (ITEM 748529)	0 SF

PAVEMENT MARKINGS LEGEND		
SYMBOL	ITEM	QUANTITY
(J)	10" PERMANENT PAVEMENT STRIPING, EPOXY RESIN PAINT, WHITE, 2' LINE & 6' GAP (ITEM 748548)	0 LF
(K)	10" PERMANENT PAVEMENT STRIPING, EPOXY RESIN PAINT, WHITE (ITEM 748549)	0 LF
(L)	10" PERMANENT PAVEMENT STRIPING, EPOXY RESIN PAINT, WHITE, 2' LINE & 2' GAP (ITEM 748549)	0 LF
(M)	5" PERMANENT PAVEMENT STRIPING, EPOXY RESIN PAINT, WHITE, 2' LINE & 6' GAP (ITEM 748548)	0 LF
(N)	5" PERMANENT PAVEMENT STRIPING, EPOXY RESIN PAINT, DOUBLE YELLOW (ITEM 748548)	0 LF
(O)	12" PERMANENT PAVEMENT STRIPING, EPOXY RESIN PAINT, YELLOW (ITEM 748509)	0 LF
(P)	10" REFLECTIVE PREFORMED PATTERNED CONTRAST MARKINGS, 2' LINE & 6' GAP (ITEM 748565)	0 LF
(R)	5" REFLECTIVE PREFORMED PATTERNED CONTRAST MARKINGS, 2' LINE & 6' GAP (ITEM 748564)	0 LF
(S)	5" PERMANENT PAVEMENT STRIPING, EPOXY RESIN PAINT, YELLOW, 10' LINE 30' GAP (ITEM 748548)	0 LF

SIGNING LEGEND	
①	REMOVE EXISTING SIGN
②	EXISTING SIGN TO REMAIN
③	PLACE NEW SIGN
④	RENEW EXISTING SIGN
⑤	REPOSITION EXISTING SIGN

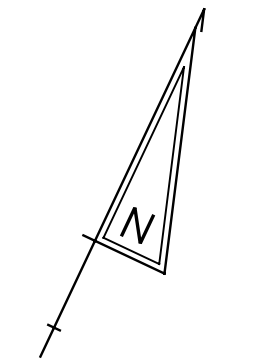

DRAFT
NOT FOR BIDDING
AUGUST 2015

